




NOTES

E	11.11.15	ISSUED FOR INFORMATION	SA	DGB	DGB
D	11.11.15	MINOR REVISIONS	CH	DGB	MH
C	11.11.15	MINOR REVISIONS	LW	DGB	MH
B	11.11.15	ISSUED FOR INFORMATION	TF	DGB	MH
A	11.11.15	ISSUED FOR INFORMATION	LW	DGB	SM
REV	DATE	DESCRIPTION	BY	CHK	APP

REVISIONS

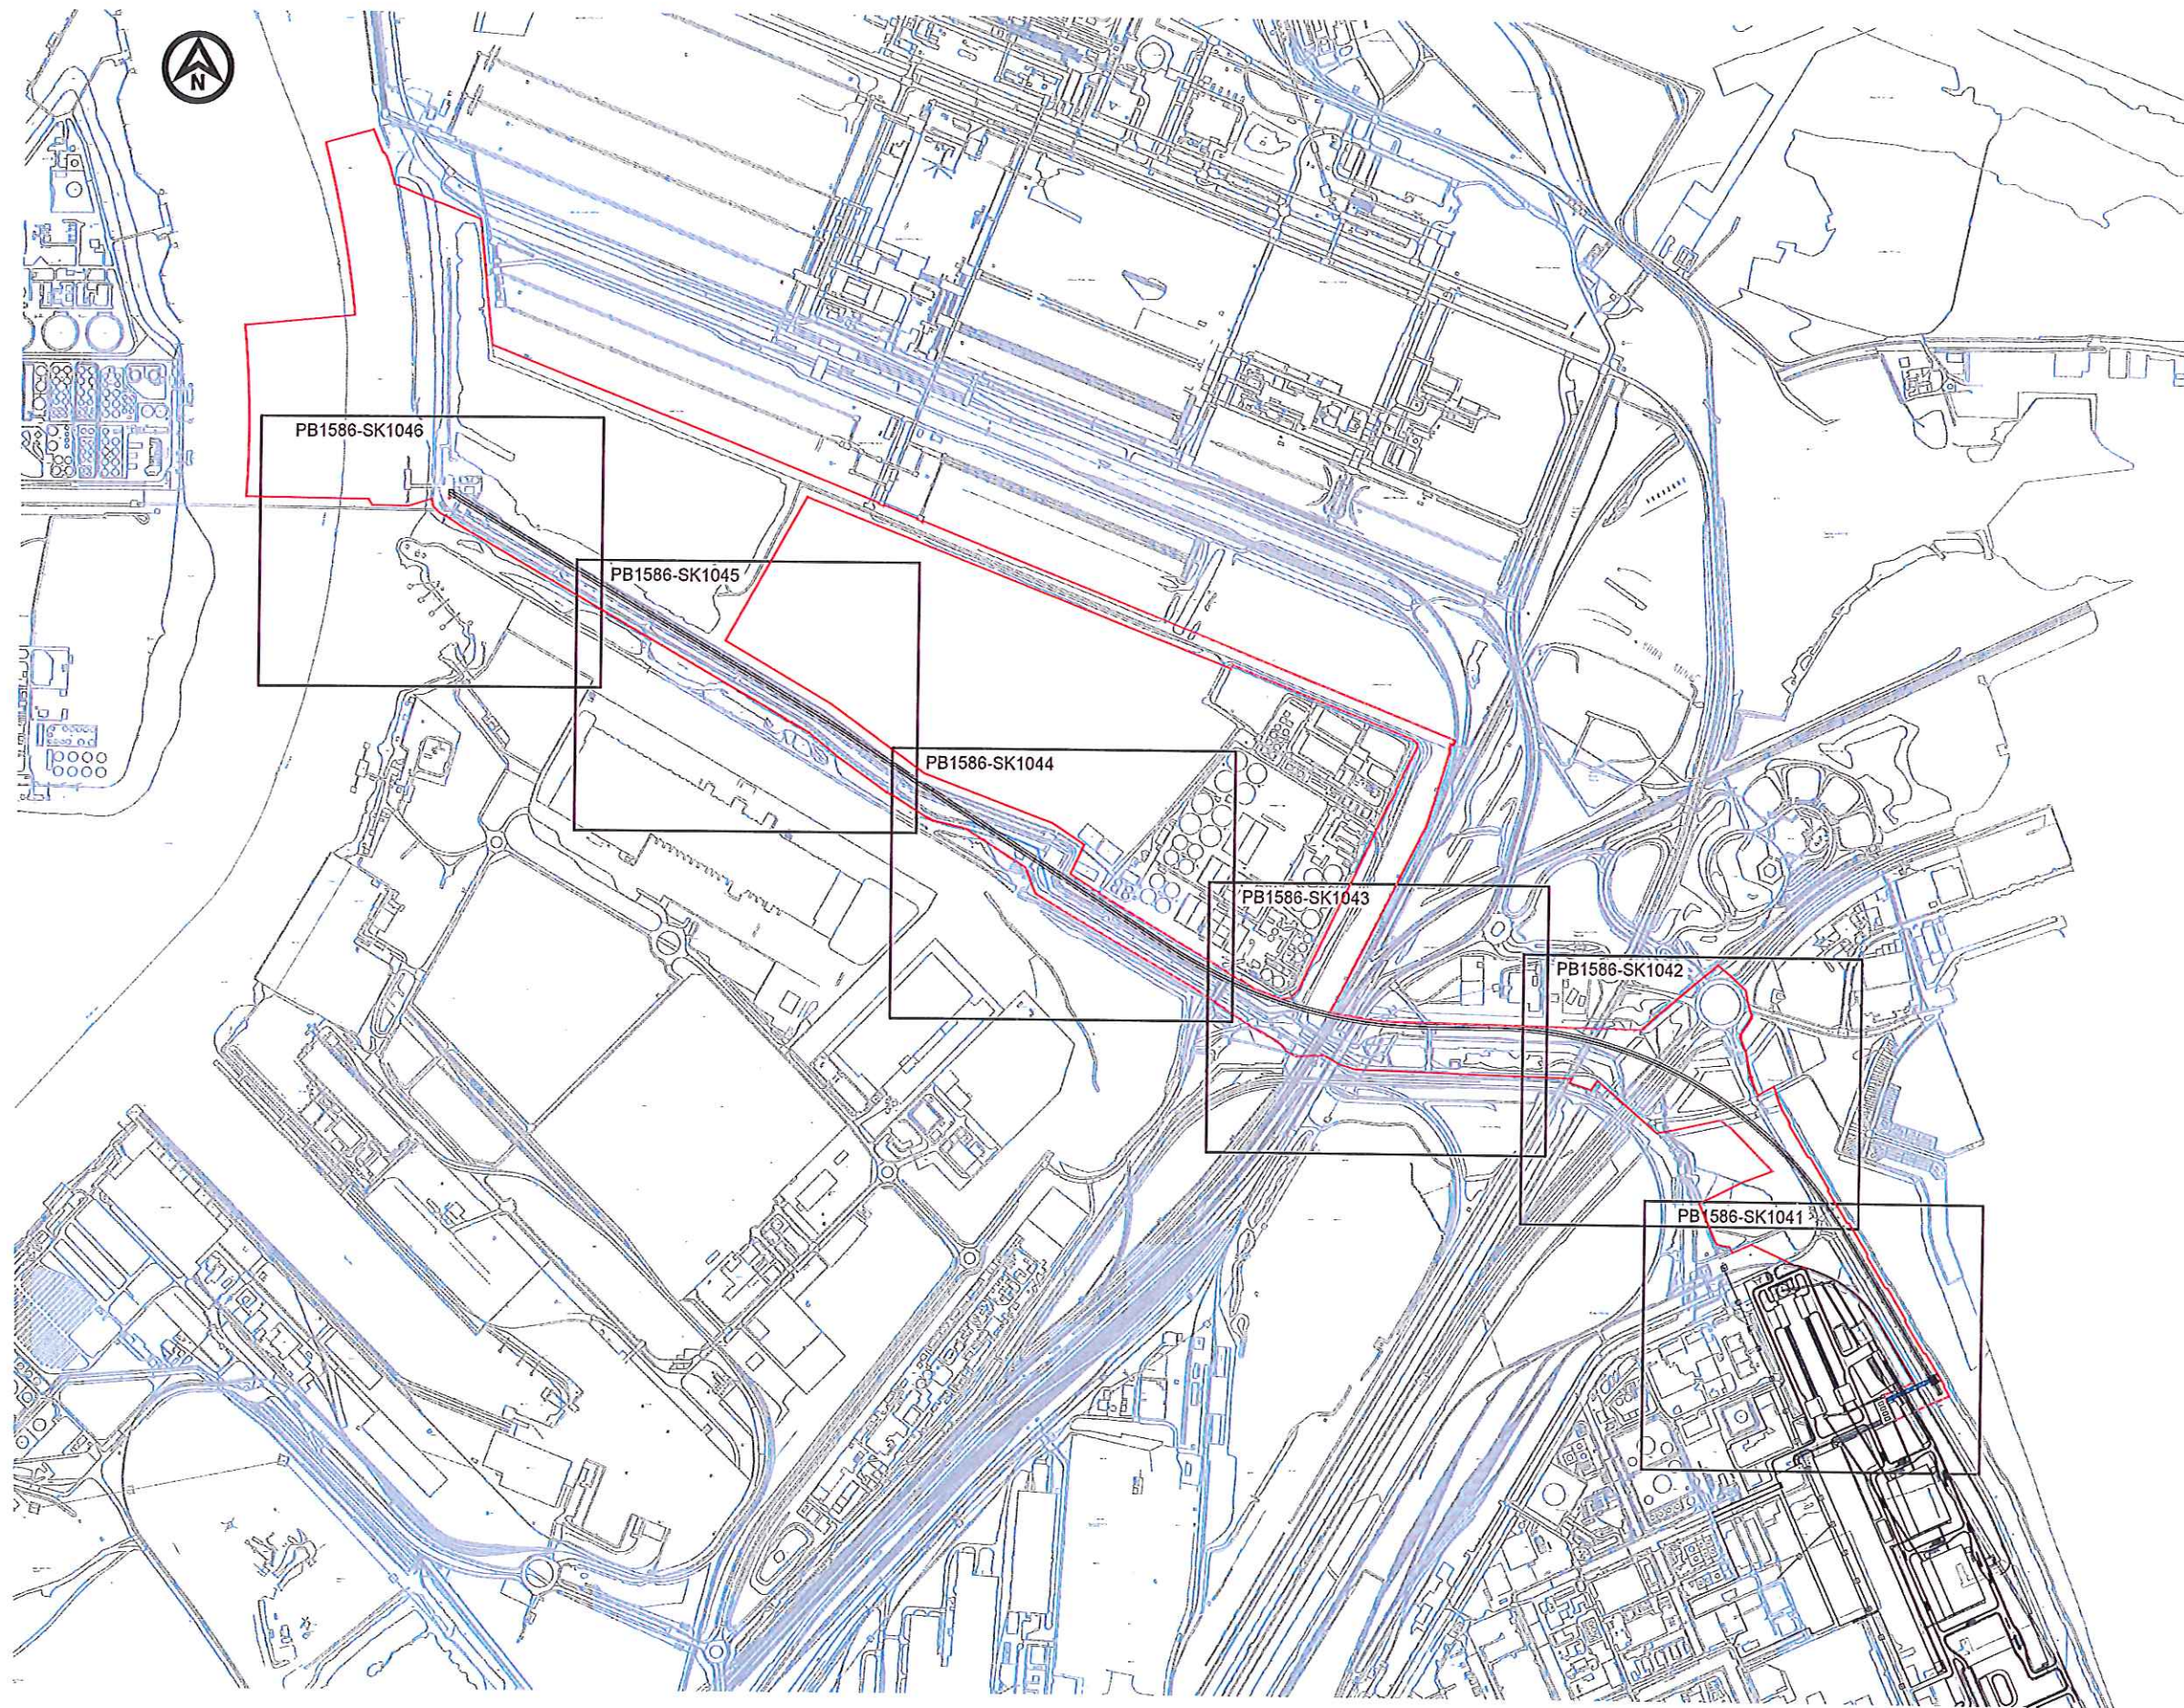

PROJECT

YORK POTASH

TITLE

THE YORK POTASH
HARBOUR FACILITIES ORDER 201X
CONVEYOR ROUTE
SOUTHERN ROUTE - KEY PLAN
REGULATION 5(2)(c) DOCUMENT 3.3A



DRAWN	LW	CHECKED	DGB	PASSED	SM
DATE	JAN15	CLIENT'S REF.			
SCALE AT A1	NTS	AUTOCAD REF.	PB1586-SK1040		
DRAWING No.	PB1586-SK1040				REVISION
					E



NOTES

MAJOR CROSSINGS

- | | |
|---------------------------------|----------------------------|
| MC 0: Eastern Boundary Road | - Pass over in bridge |
| MC 1: Highway A1055 | - Pass over in bridge |
| MC 2: YPL 1st access road | - Pass over in bridge |
| MC 3: Hot metal rail | - Pass over in bridge |
| MC 4: NWL 2nd access road | - Pass over in bridge |
| MC 5: National power grid lines | - Pass under 10m clearance |
| MC 6: SSI road bridge | - Pass over in bridge |
| MC 7: National rail way | - Pass over in bridge |
| MC 8: Access NWL W.T.P. | - Pass over in bridge |
| MC 9: Outfall | - Pass over in bridge |



KEY PLAN
SCALE 1:50000

LEGEND - CONVEYOR

- TYPE 3 - OPEN CONVEYOR - 2 LEGS
- TYPE 4 - OVAL ENCLOSED CONVEYOR - 2 LEGS
- TRANSFER TOWER
- ACCESS ROADS
- CONVEYOR FOOTINGS
- CONVEYOR AT THE QUAY

LEGEND - EXISTING SERVICES

- EASEMENT ZONES
 - GAS - BP CATS
 - GAS - GDF SUEZ
 - GAS - RWE
- FIBRE OPTIC CABLE
- MISC - DRAINS, CABLES, DUCTS
- FOUL WATER - SEMBCORP
- WATER - NWL
- GAS - ABANDONED
- ABOVEGROUND PIPELINE CORRIDOR
- OVERHEAD POWER CABLES
- CONVEYOR LIMITS OF DEVIATION

E	11.03.15	PLANNING ISSUE	LW	DGB	MH
D	11.03.15	MINOR REVISIONS	CH	DGB	MH
C	11.03.15	MINOR REVISIONS	LW	DGB	MH
B	07.03.15	ISSUED FOR INFORMATION	TF	DGB	MH
A	07.03.15	ISSUED FOR INFORMATION	LW	DGB	SH
REV	DATE	DESCRIPTION	BY	CHK	APP

REVISIONS




PROJECT
YORK POTASH

TITLE
**THE YORK POTASH
HARBOUR FACILITIES ORDER 201X
CONVEYOR ROUTE PLANS
SOUTHERN ROUTE - SHEET 1
REGULATION 5(2)(a) DOCUMENT 3.3B**




DRAWN	LW	CHECKED	DGB	PASSED	SM
DATE	JAN 15	CLIENT'S REF.			
SCALE	ATA1	1:1000	AUTOCAD REF.	PB1586-SK1041	
DRAWING No.	PB1586-SK1041	REVISION			E

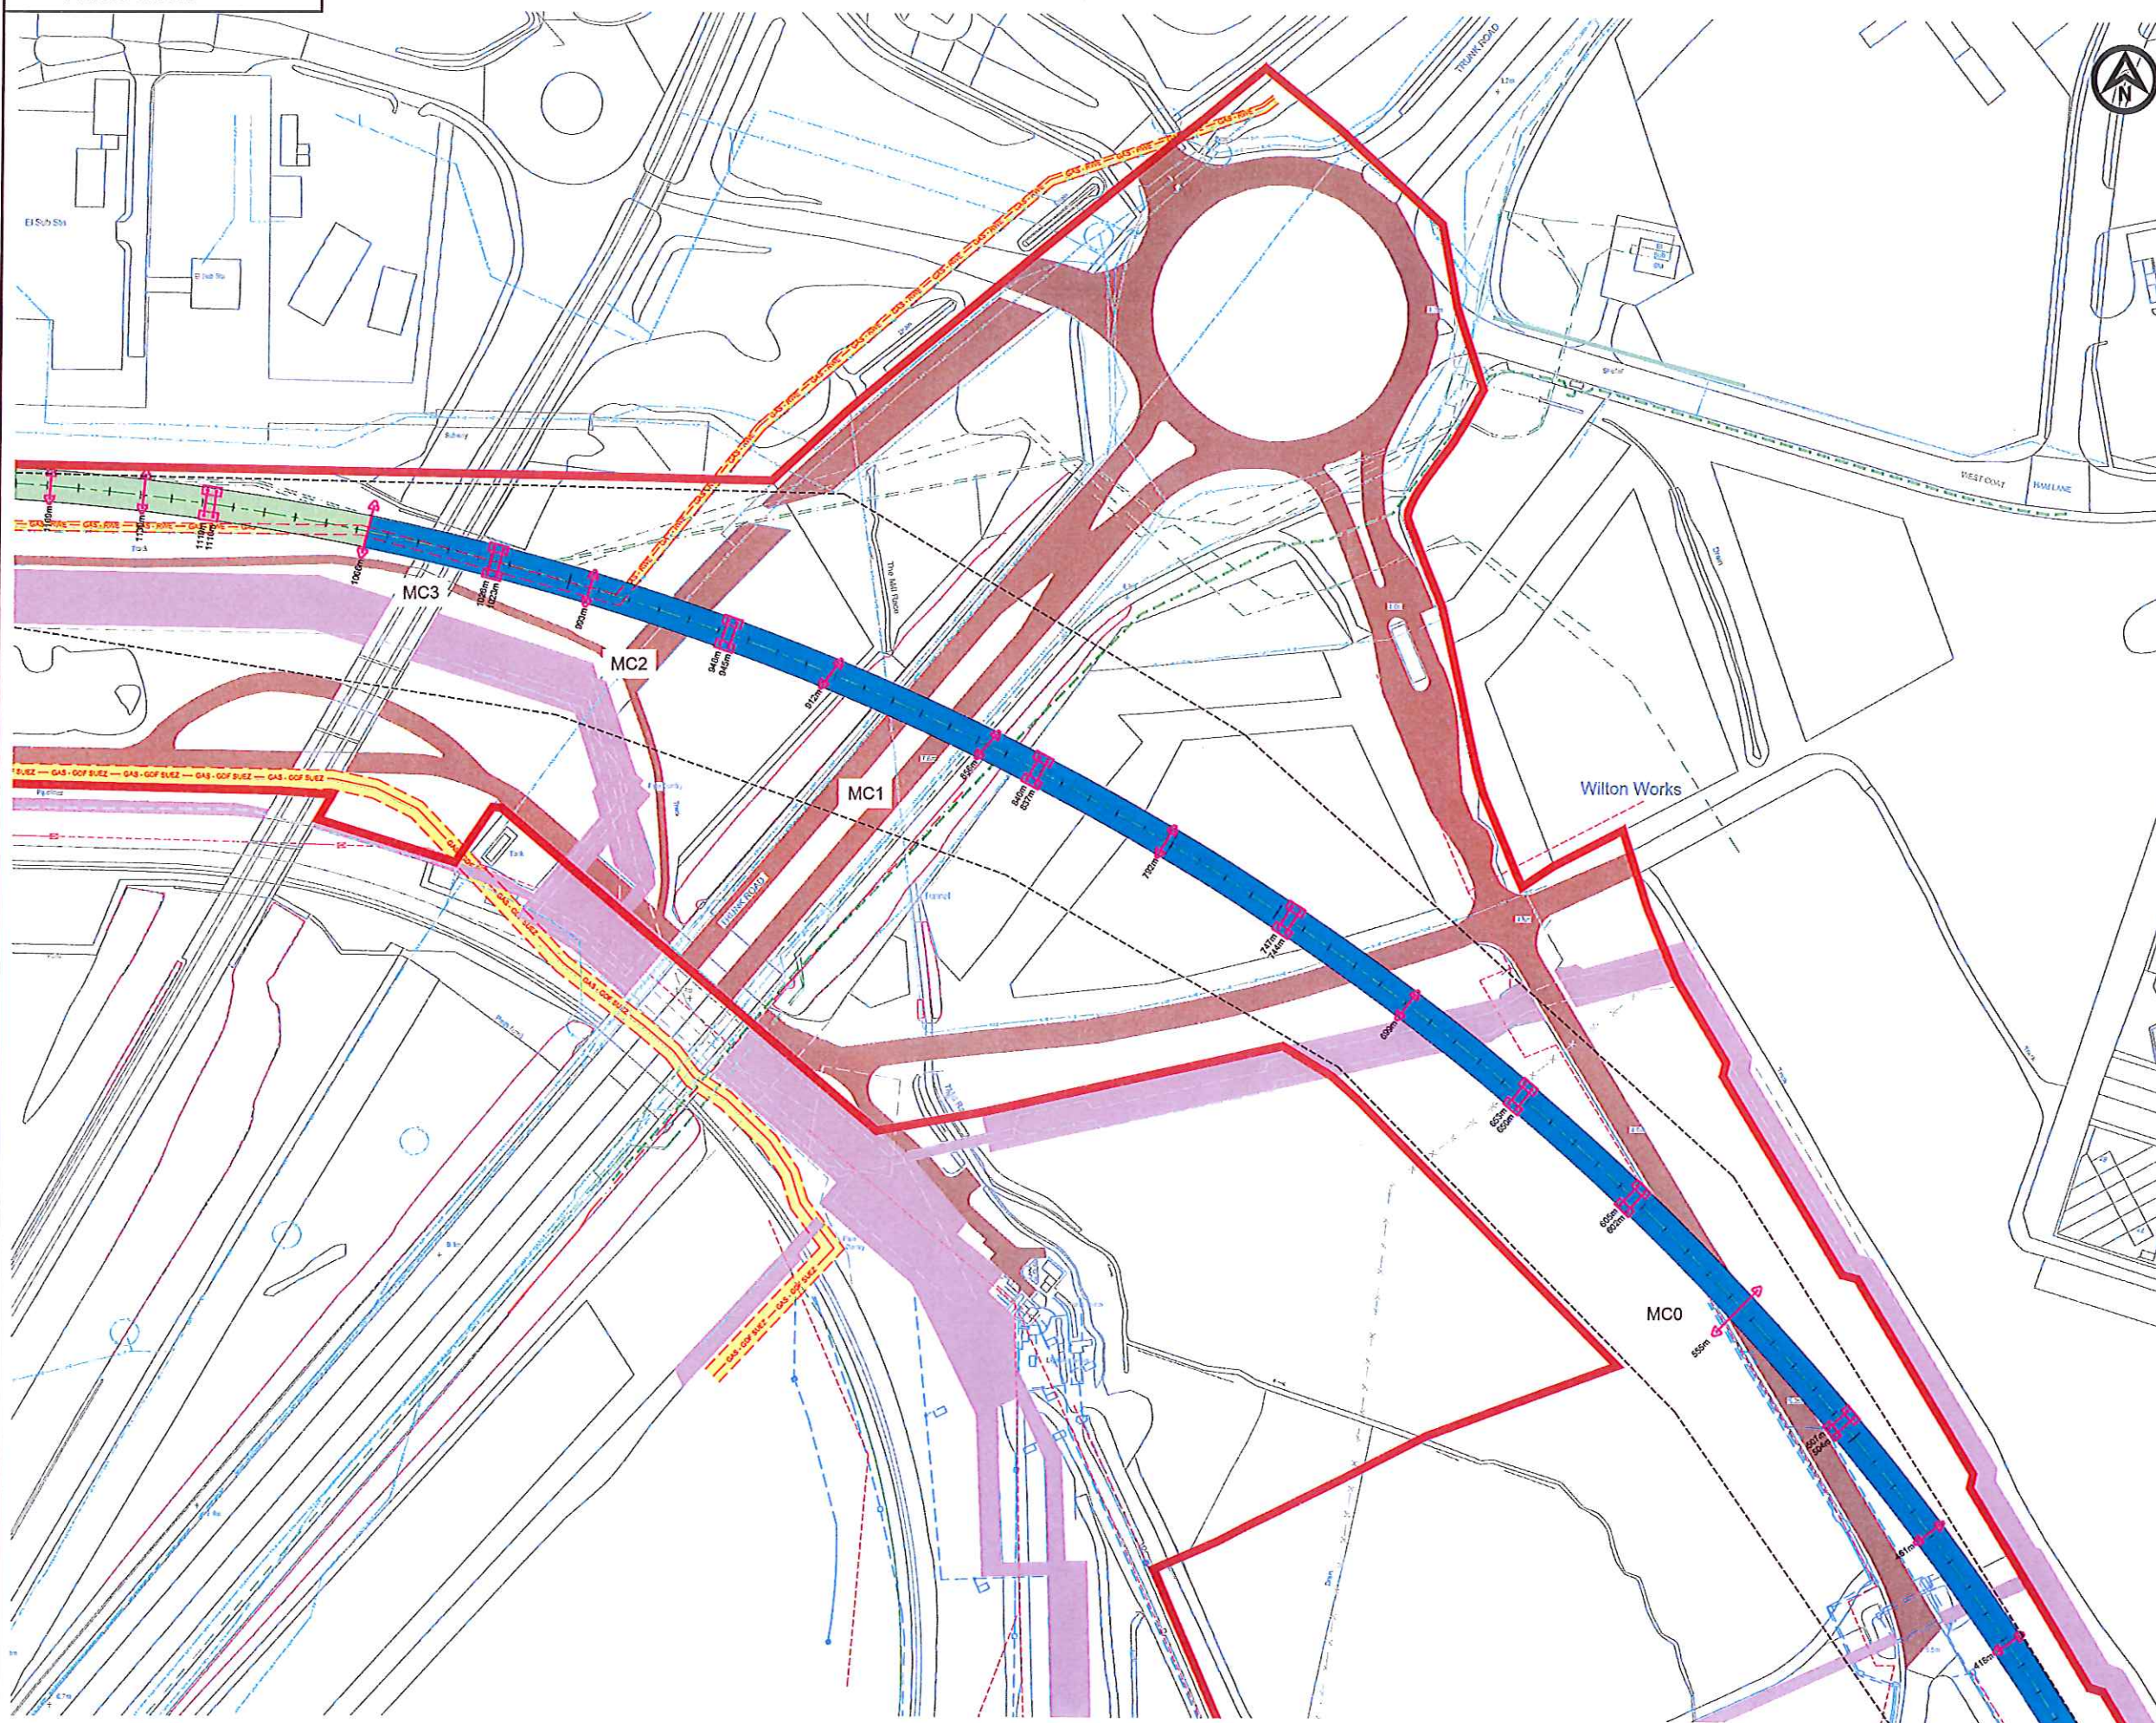

NOTES

MAJOR CROSSINGS

- | | |
|----------------------------------|-----------------------------|
| MC 0 : Eastern Boundary Road | - Pass over in bridge |
| MC 1 : Highway A1085 | - Pass over in bridge |
| MC 2 : VTL 1st access road | - Pass over in bridge |
| MC 3 : Hot metal rail | - Pass over in bridge |
| MC 4 : NWL 2nd access road | - Pass over in bridge |
| MC 5 : National power grid lines | - Pass under 10 m clearance |
| MC 6 : SSI road bridge | - Pass over in bridge |
| MC 7 : National rail way | - Pass over in bridge |
| MC 8 : Access NWL W.T.P. | - Pass over in bridge |
| MC 9 : Outfall | - Pass over in bridge |

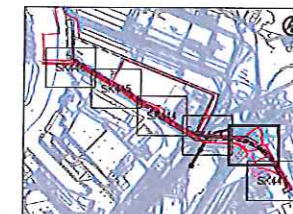

KEY PLAN
SCALE 1:50000

LEGEND - CONVEYOR

- TYPE 3 - OPEN CONVEYOR - 2 LEGS
- TYPE 4 - OVAL ENCLOSED CONVEYOR - 2 LEGS
- TRANSFER TOWER
- ACCESS ROADS
- CONVEYOR FOOTINGS
- CONVEYOR AT THE QUAY

LEGEND - EXISTING SERVICES

- EASEMENT ZONES
- GAS - BP CATS
- GAS - GDF SUEZ
- GAS - RWE
- FIBRE OPTIC CABLE
- MISC - DRAINS, CABLES, DUCTS
- FOUL WATER - SEMSCORP
- WATER - NWL
- GAS - ABANDONED
- ABOVEGROUND PIPELINE CORRIDOR
- OVERHEAD POWER CABLES
- CONVEYOR LIMITS OF DEVIATION

E	19.01.15	PLANNING ISSUE	LW	DGB	M51
D	11.01.15	MINOR REVISIONS	CH	DGB	M51
C	11.01.15	MINOR REVISIONS	LW	DGB	M51
B	01.01.15	ISSUED FOR INFORMATION	TF	DGB	M51
A	01.01.15	ISSUED FOR INFORMATION	LW	DGB	M51
REV	DATE	DESCRIPTION	BY	CHK	APP

REVISIONS




PROJECT
YORK POTASH

TITLE
**THE YORK POTASH
HARBOUR FACILITIES ORDER 201X
CONVEYOR ROUTE PLANS
SOUTHERN ROUTE - SHEET 2
REGULATION 5(2)(c) DOCUMENT 3.3C**

HASKONPOTASH/UK LTD
MARITIME & WATERWAYS
Maritime House
Newcastle upon Tyne NE1 7EE
+44 (0) 191 211 1300 Telephone
+44 (0) 191 211 1313 Fax
info@haskonpotash.co.uk E-mail
www.haskonpotash.co.uk Internet


DRAWN	LW	CHECKED	DGB	PASSED	SM
DATE	JAN 15	CLIENT'S REF.			
SCALE AT A1	1:1000	AUTOCAD REF.	PB1586-SK1042		
DRAWING NO.	PB1586-SK1042	REVISION	E		

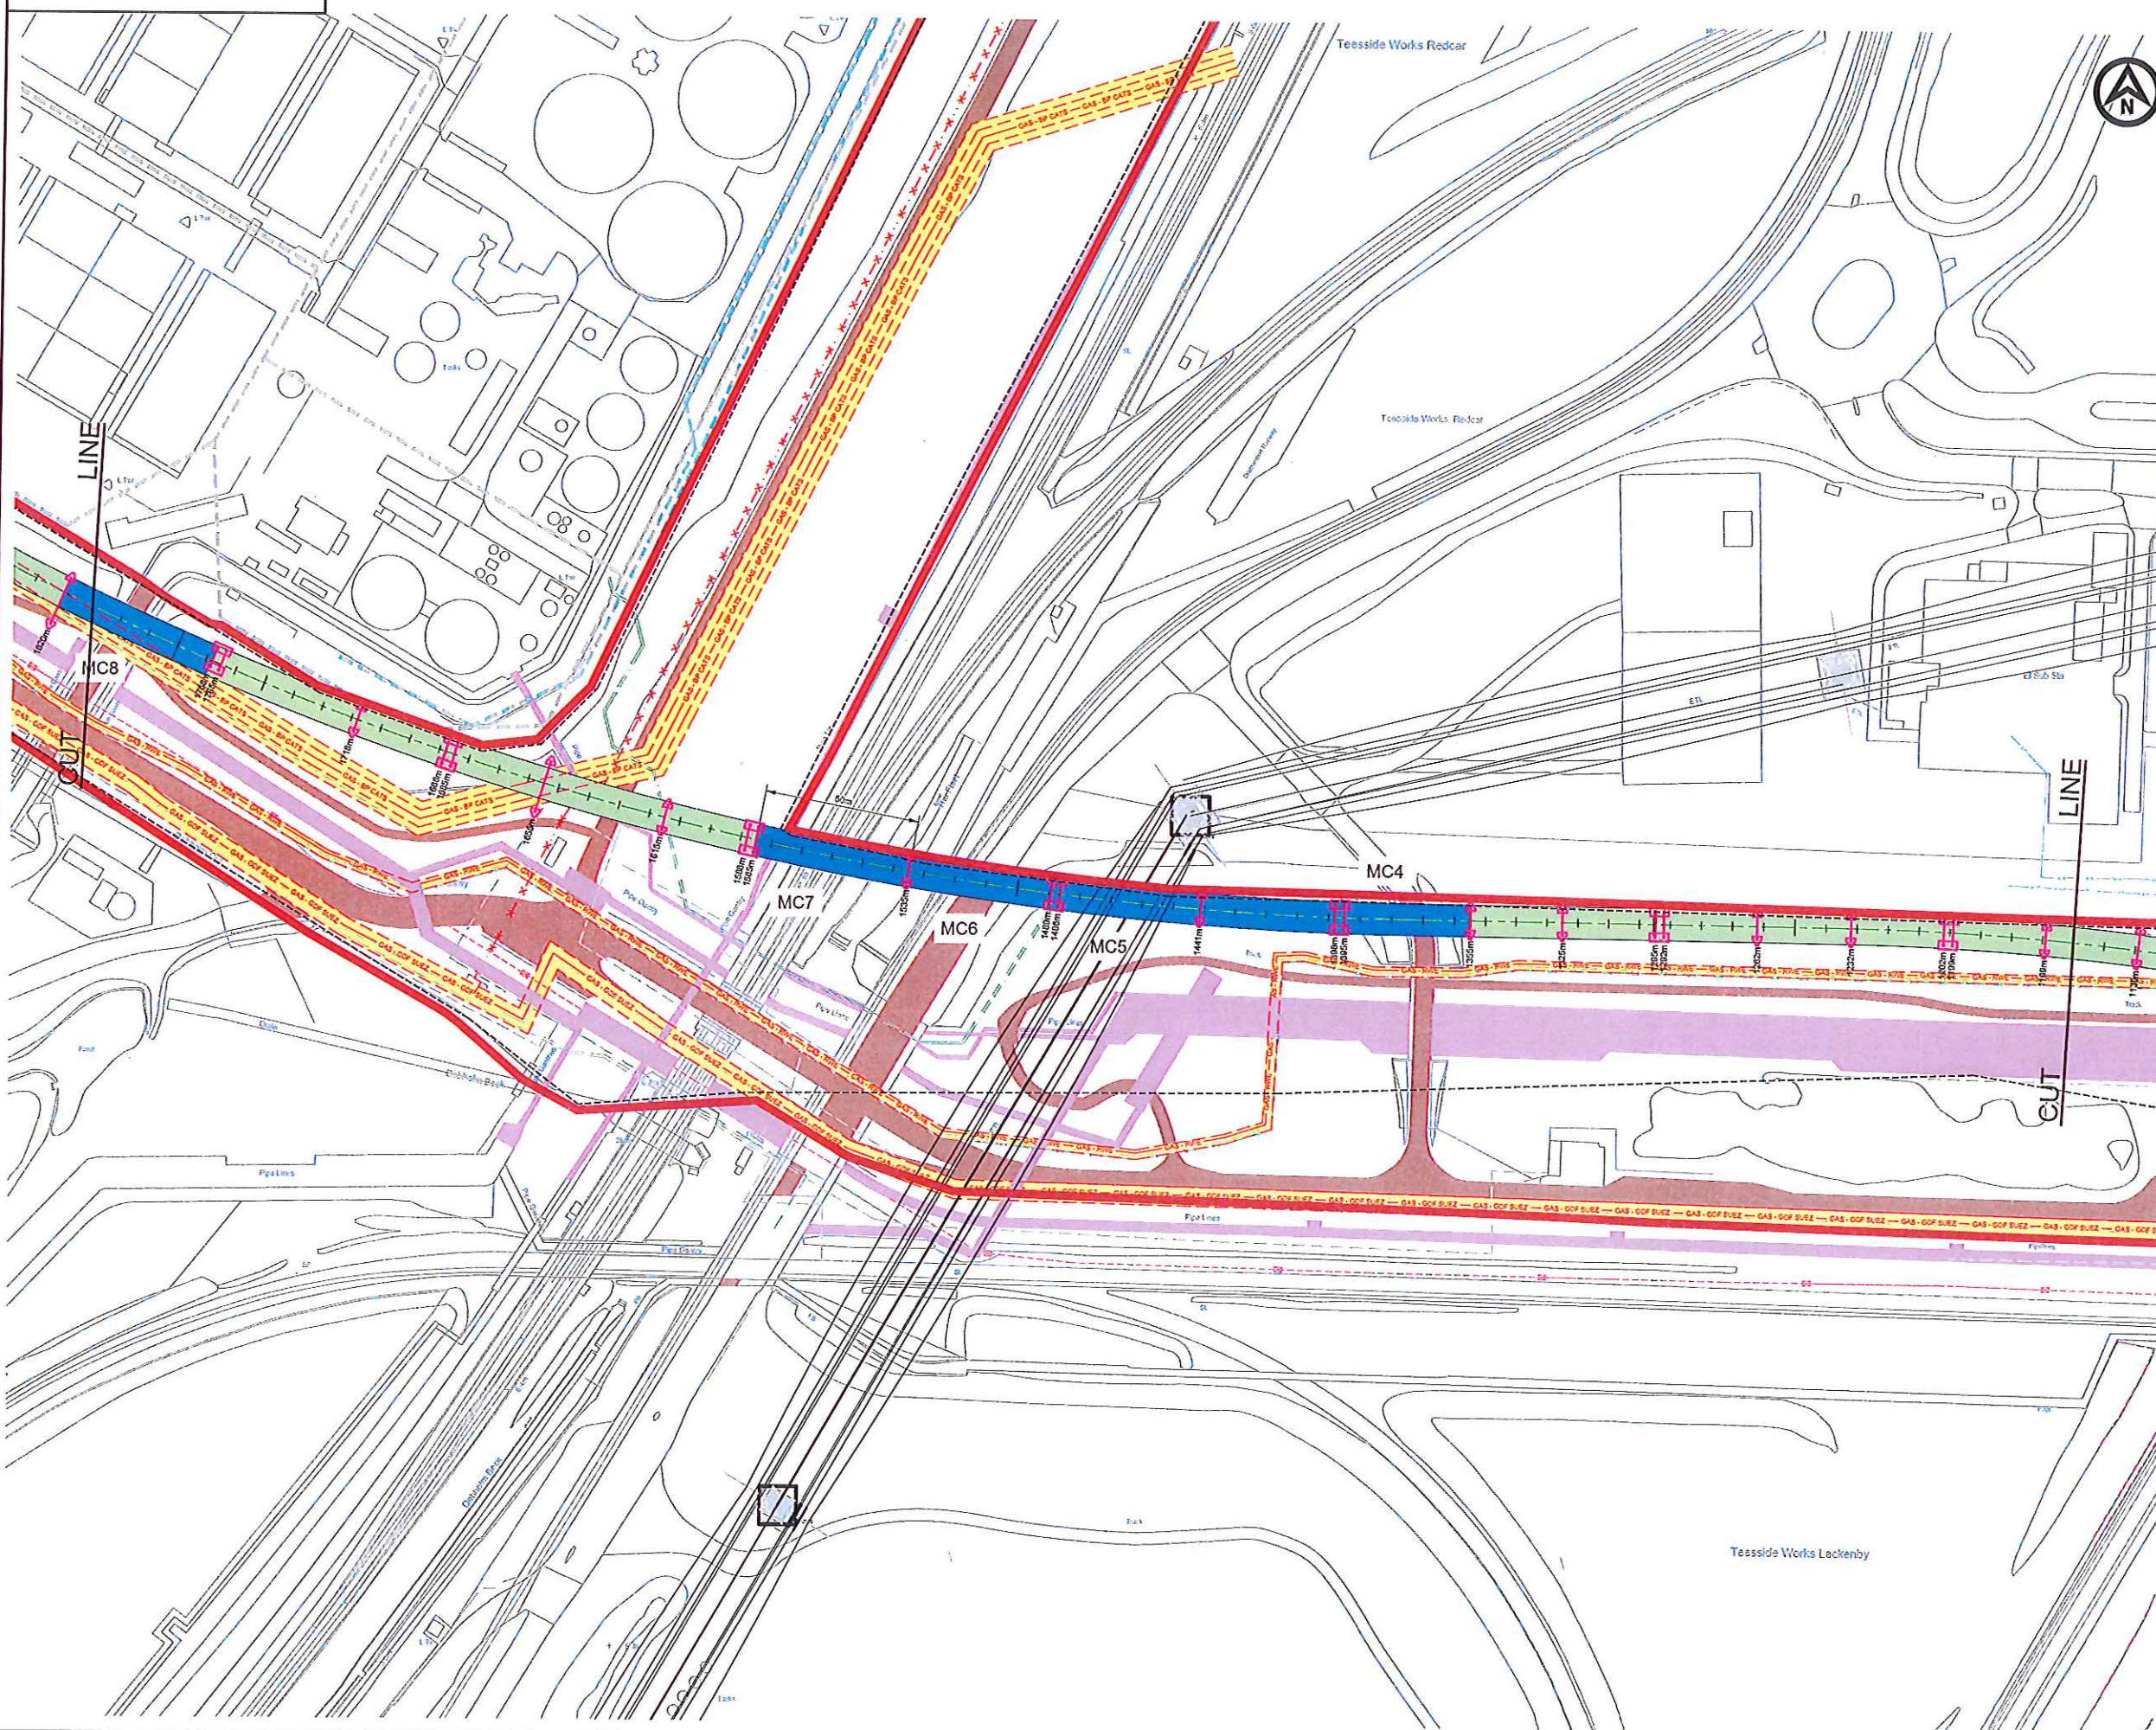

NOTES

MAJOR CROSSINGS

- MC 0: Eastern Boundary Road - Pass over in bridge
- MC 1: Highway A1665 - Pass over in bridge
- MC 2: YPL 1st access road - Pass over in bridge
- MC 3: Hot metal rail - Pass over in bridge
- MC 4: NWL 2nd access road - Pass over in bridge
- MC 5: National power grid lines - Pass under 10 m clearance
- MC 6: SSI road bridge - Pass over in bridge
- MC 7: National rail way - Pass over in bridge
- MC 8: Access NWL W.T.P. - Pass over in bridge
- MC 9: Outfall - Pass over in bridge

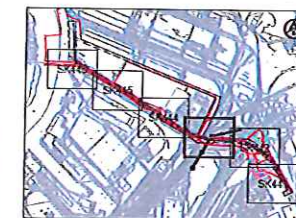

KEY PLAN

SCALE 1:50000

LEGEND - CONVEYOR

- TYPE 3 - OPEN CONVEYOR - 2 LEGS
- TYPE 4 - OVAL ENCLOSED CONVEYOR - 2 LEGS
- TRANSFER TOWER
- ACCESS ROADS
- CONVEYOR FOOTINGS
- CONVEYOR AT THE QUAY

LEGEND - EXISTING SERVICES

- EASEMENT ZONES
- GAS - EP CATS
- GAS - GOF SUEZ
- GAS - RWE
- FIBRE OPTIC CABLE
- MSC - DRAINS, CABLES, DUCTS
- FOUL WATER - SEMCORP
- WATER - NWL
- GAS - ABANDONED
- ABOVEGROUND PIPELINE CORRIDOR
- OVERHEAD POWER CABLES
- CONVEYOR LIMITS OF DEVIATION


E	14.04.14	PLANNING ISSUE	LW	DGB	MH
D	14.04.14	MINOR REVISIONS	CH	DGB	MH
C	14.04.14	MINOR REVISIONS	LW	DGB	MH
B	14.04.14	ISSUED FOR INFORMATION	TP	DGB	MH
A	14.04.14	ISSUED FOR INFORMATION	LW	DGB	SM
REV	DATE	DESCRIPTION	BY	CHK	APP



PROJECT	YORK POTASH
TITLE	THE YORK POTASH HARBOUR FACILITIES ORDER 201X CONVEYOR ROUTE PLANS SOUTHERN ROUTE - SHEET 3 REGULATION 5(2)(e) DOCUMENT 3.3D

HASKONINGDHV UK LTD MARITIME & WATERWAYS Marine House Newcastle upon Tyne NE1 4EE +44 (0) 191 251 1325 Telephone +44 (0) 191 251 1313 Fax info@newcastle.yorkpotash.com E-mail www.yorkpotash.com Website
--

DRAWN	LW	CHECKED	DGB	PASSED	SM
DATE	JAN15	CLIENT'S REF.			
SCALE AT A1	1:1000	AUTOCAD REF.	PB1586-SK1043		
DRAWING No.	PB1586-SK1043	REVISION	E		

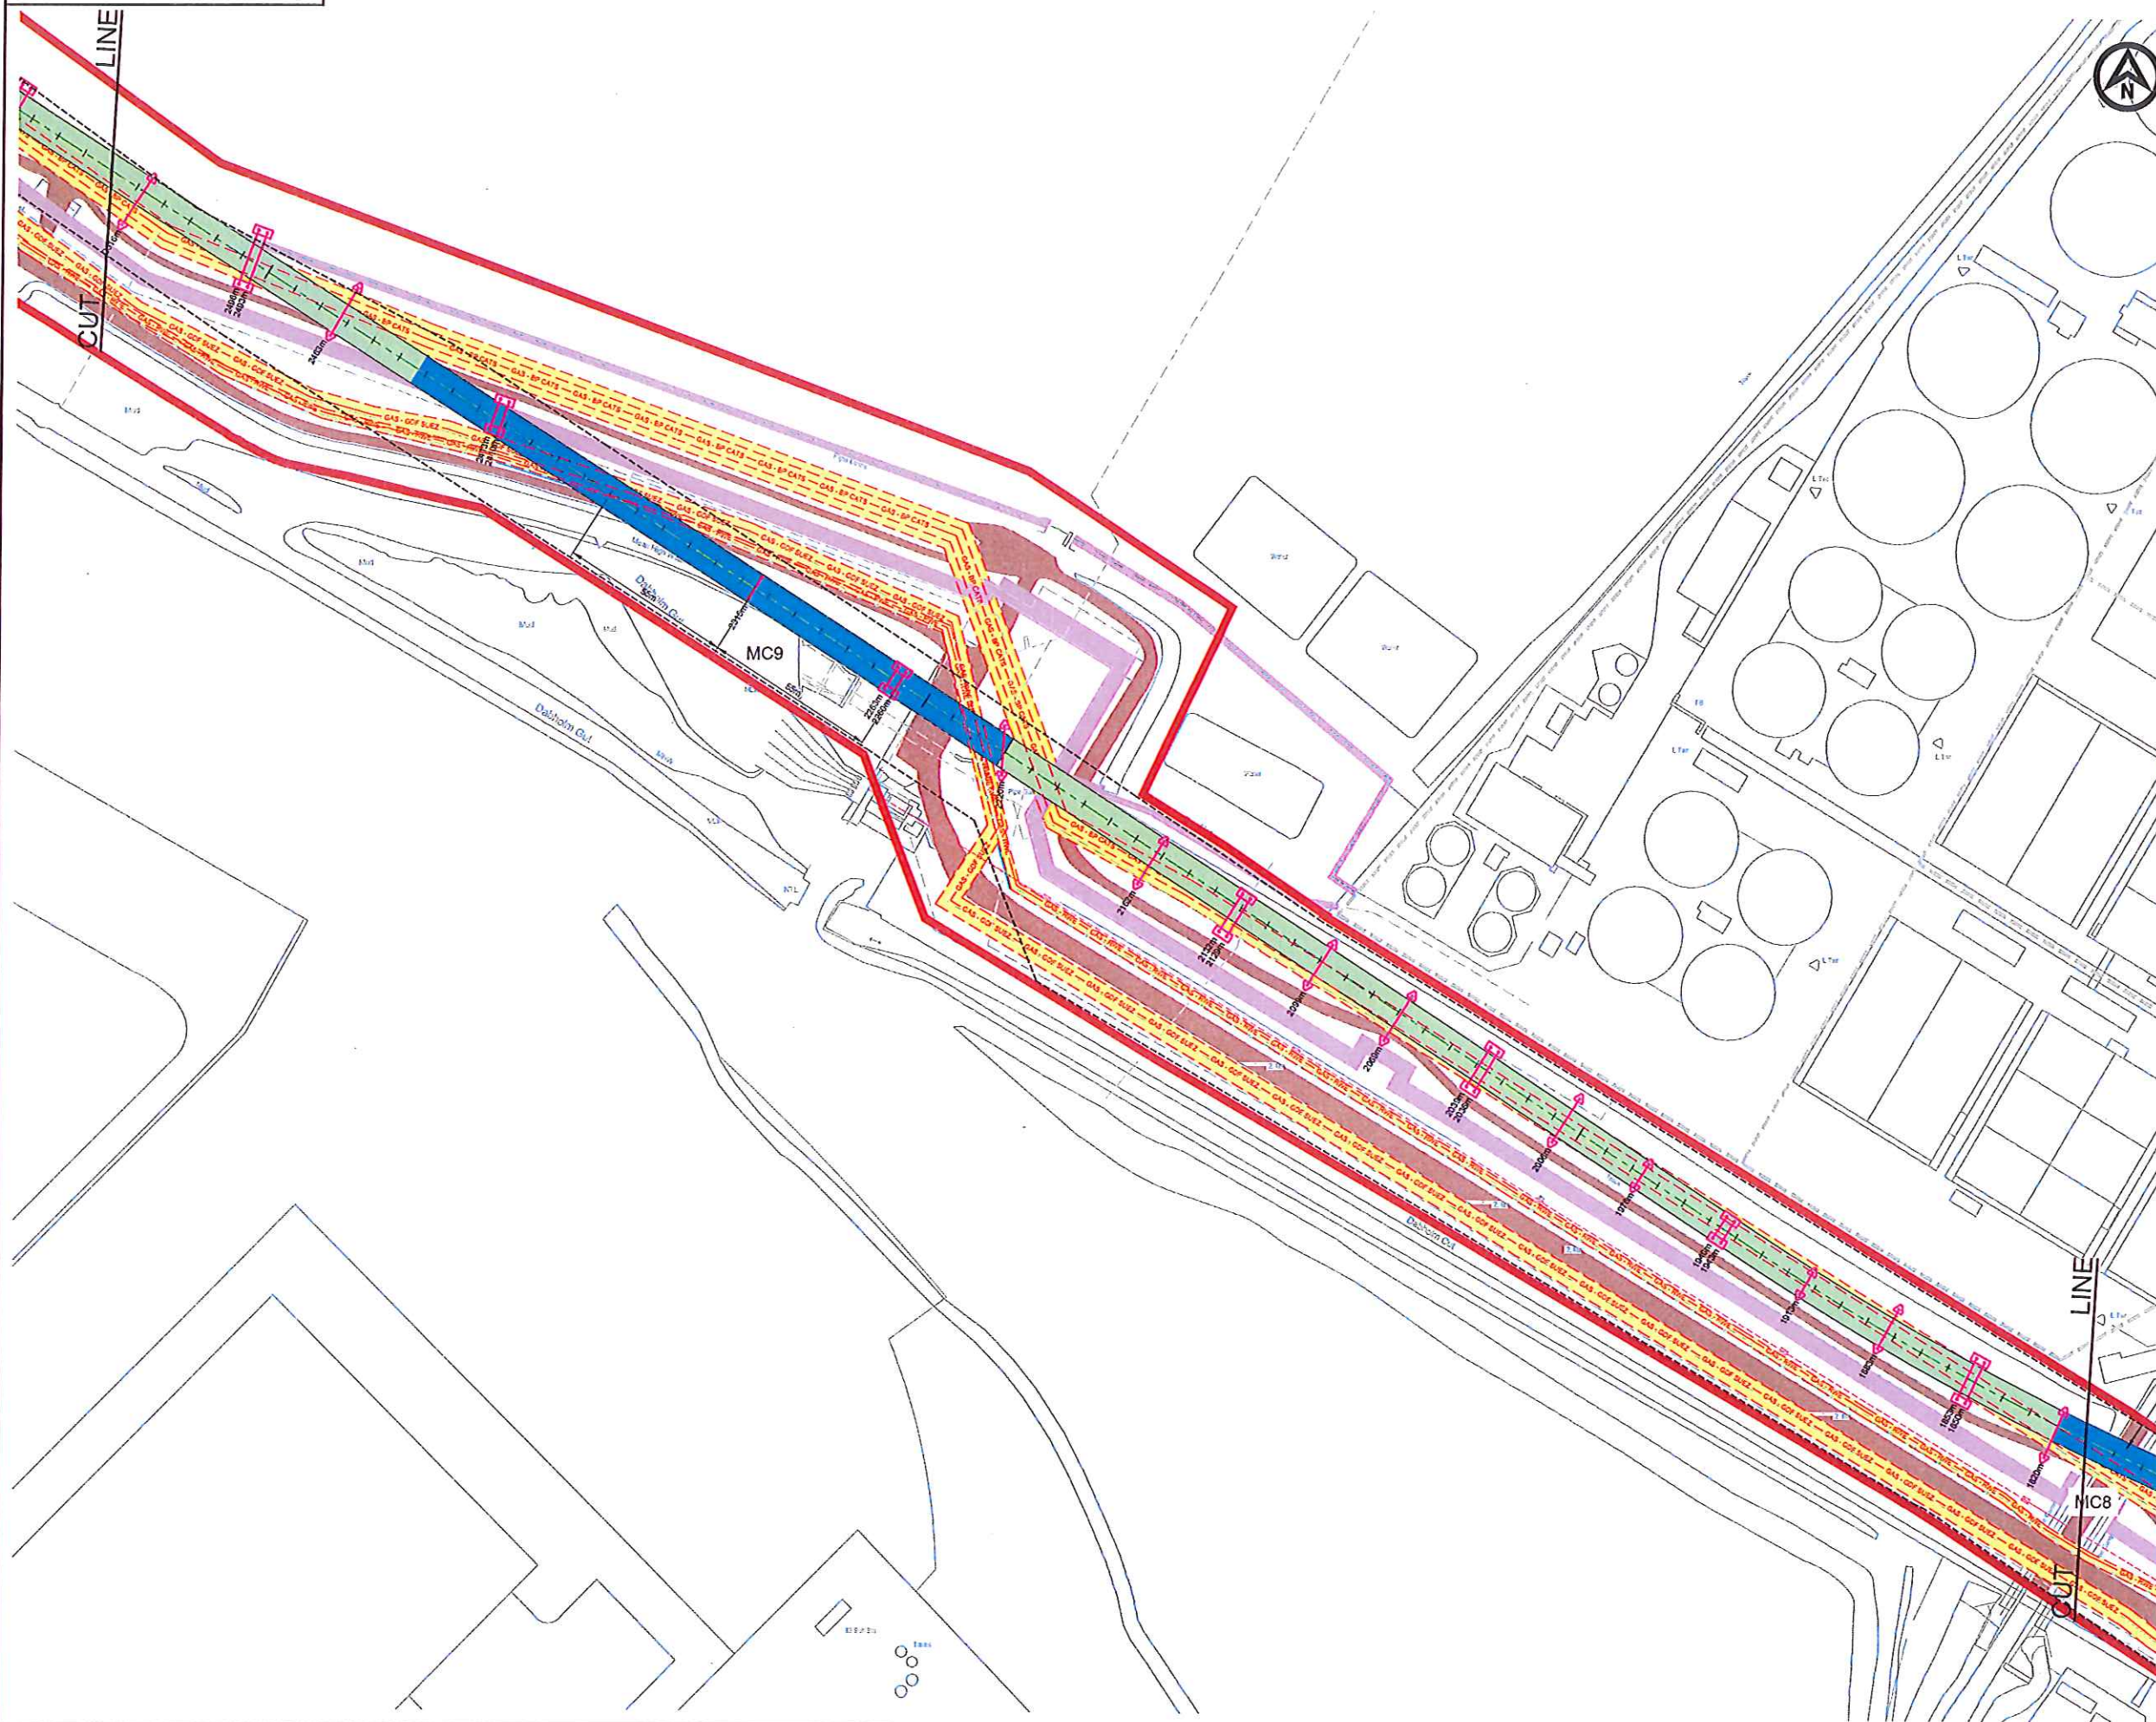

NOTES

MAJOR CROSSINGS

- MC 0 : Easton Boundary Road - Pass over in bridge
- MC 1 : Highway A1055 - Pass over in bridge
- MC 2 : YPL 1st access road - Pass over in bridge
- MC 3 : YPL 2nd access road - Pass over in bridge
- MC 4 : NWL 2nd access road - Pass over in bridge
- MC 5 : National power grid lines - Pass under 10 m clearance
- MC 6 : SSI road bridge - Pass over in bridge
- MC 7 : National rail way - Pass over in bridge
- MC 8 : Access NWL V.T.P. - Pass over in bridge
- MC 9 : Outfall - Pass over in bridge



KEY PLAN
SCALE 1:50,000

LEGEND - CONVEYOR

- TYPE 3 - OPEN CONVEYOR - 2 LEGS
- TYPE 4 - OVAL ENCLOSED CONVEYOR - 2 LEGS
- TRANSFER TOWER
- ACCESS ROADS
- CONVEYOR FOOTINGS
- CONVEYOR AT THE QUAY

LEGEND - EXISTING SERVICES

- EASEMENT ZONES
- GAS - EP CATS
- GAS - GDF SUEZ
- GAS - RWE
- FIBRE OPTIC CABLE
- MISC - DRAINS, CABLES, DUCTS
- FOUL WATER - SEMSCORP
- WATER - NWL
- GAS - ABANDONED
- ABOVEGROUND PIPELINE CORRIDOR
- OVERHEAD POWER CABLES
- CONVEYOR LIMITS OF DEVIATION

REV	DATE	DESCRIPTION	BY	CHK	APP
E	11/11/15	PLANNING ISSUE	LW	DGB	MM
D	11/11/15	MINOR REVISIONS	CH	DGB	MM
C	11/11/15	MINOR REVISIONS	LW	DGB	MM
B	11/11/15	ISSUED FOR INFORMATION	TF	DGB	MM
A	11/11/15	ISSUED FOR INFORMATION	LW	DGB	SM

REVISIONS



PROJECT
YORK POTASH

TITLE
**THE YORK POTASH
HARBOUR FACILITIES ORDER 201X
CONVEYOR ROUTE PLANS
SOUTHERN ROUTE - SHEET 4
REGULATION 5(2)(o) DOCUMENT 3.3E**

ROYAL HASKONINGDHV
Enhancing Society Together
HASKONINGDHV UK LTD
MARITIME & WATERWAYS
Maritime House
Maritime Quay
Newcastle upon Tyne NE1 4EX
+44 (0) 191 211 1300
+44 (0) 191 211 1313
www.royalhaskoningdhv.com


DRAWN	CHECKED	DATE	CLIENT'S REF.	AUTOCAD REF.	REVISION
LW	DGB	JAN15		PB1586-SK1044	E



NOTES

MAJOR CROSSINGS

- | | |
|---------------------------------|-----------------------------|
| MC 0: Eastern Boundary Road | - Pass over in bridge |
| MC 1: Highway A1585 | - Pass over in bridge |
| MC 2: YPL 1st access road | - Pass over in bridge |
| MC 3: Hot metal rail | - Pass over in bridge |
| MC 4: NWL 2nd access road | - Pass over in bridge |
| MC 5: National power grid lines | - Pass under 10 m clearance |
| MC 6: SSI road bridge | - Pass over in bridge |
| MC 7: National rail way | - Pass over in bridge |
| MC 8: Access NWL W.T.P. | - Pass over in bridge |
| MC 9: Outfall | - Pass over in bridge |

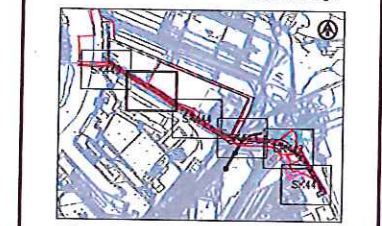

KEY PLAN
SCALE 1:50,000

LEGEND - CONVEYOR

- TYPE 3 - OPEN CONVEYOR - 2 LEGS
- TYPE 4 - OVAL ENCLOSED CONVEYOR - 2 LEGS
- TRANSFER TOWER
- ACCESS ROADS
- CONVEYOR FOOTINGS
- CONVEYOR AT THE QUAY

LEGEND - EXISTING SERVICES

- EASEMENT ZONES
- GAS - BP CATS
- GAS - GDF SUEZ
- GAS - RWE
- FIBRE OPTIC CABLE
- MISC - DRAINS, CABLES, DUCTS
- FOUL WATER - SEMECORP
- WATER - NWL
- GAS - ABANDONED
- ABOVEGROUND PIPELINE CORRIDOR
- OVERHEAD POWER CABLES
- CONVEYOR LIMITS OF DEVIATION

E	10/10/15	PLANNING ISSUE	LW	DGB	MM
D	10/10/15	MINOR REVISIONS	CH	DGB	MM
C	11/01/16	MINOR REVISIONS	LW	DGB	MM
B	10/10/15	ISSUED FOR INFORMATION	TF	DGB	MM
A	10/10/15	ISSUED FOR INFORMATION	LW	DGB	MM
REV	DATE	DESCRIPTION	BY	CHK	APP

REVISIONS

YORKPOTASH
A Sirius Minerals Project


PROJECT
YORK POTASH

TITLE
THE YORK POTASH
HARBOUR FACILITIES ORDER 201X
CONVEYOR ROUTE PLANS
SOUTHERN ROUTE - SHEET 5
REGULATION 5(2)(c) DOCUMENT 3.3F

Royal HaskoningDHV
Delivering Society Together

HASKONINGDHV UK LTD
MARITIME & WATERWAYS
Marlborough House
Marlborough Crescent
Newcastle upon Tyne NE1 4EE
+44 (0) 191 211 1300 Telephone
+44 (0) 191 211 1313 Fax
uk@haskoningdhv.com E-mail
www.haskoningdhv.com Website

DRAWN	LW	CHECKED	DGB	PASSED	SM
DATE	JAN15	CLIENTS REF.			
SCALE AT A1	1:1000	AUTOCAD REF.	PB1586-SK1045		
DRAWING No.	PB1586-SK1045	REVISION	E		

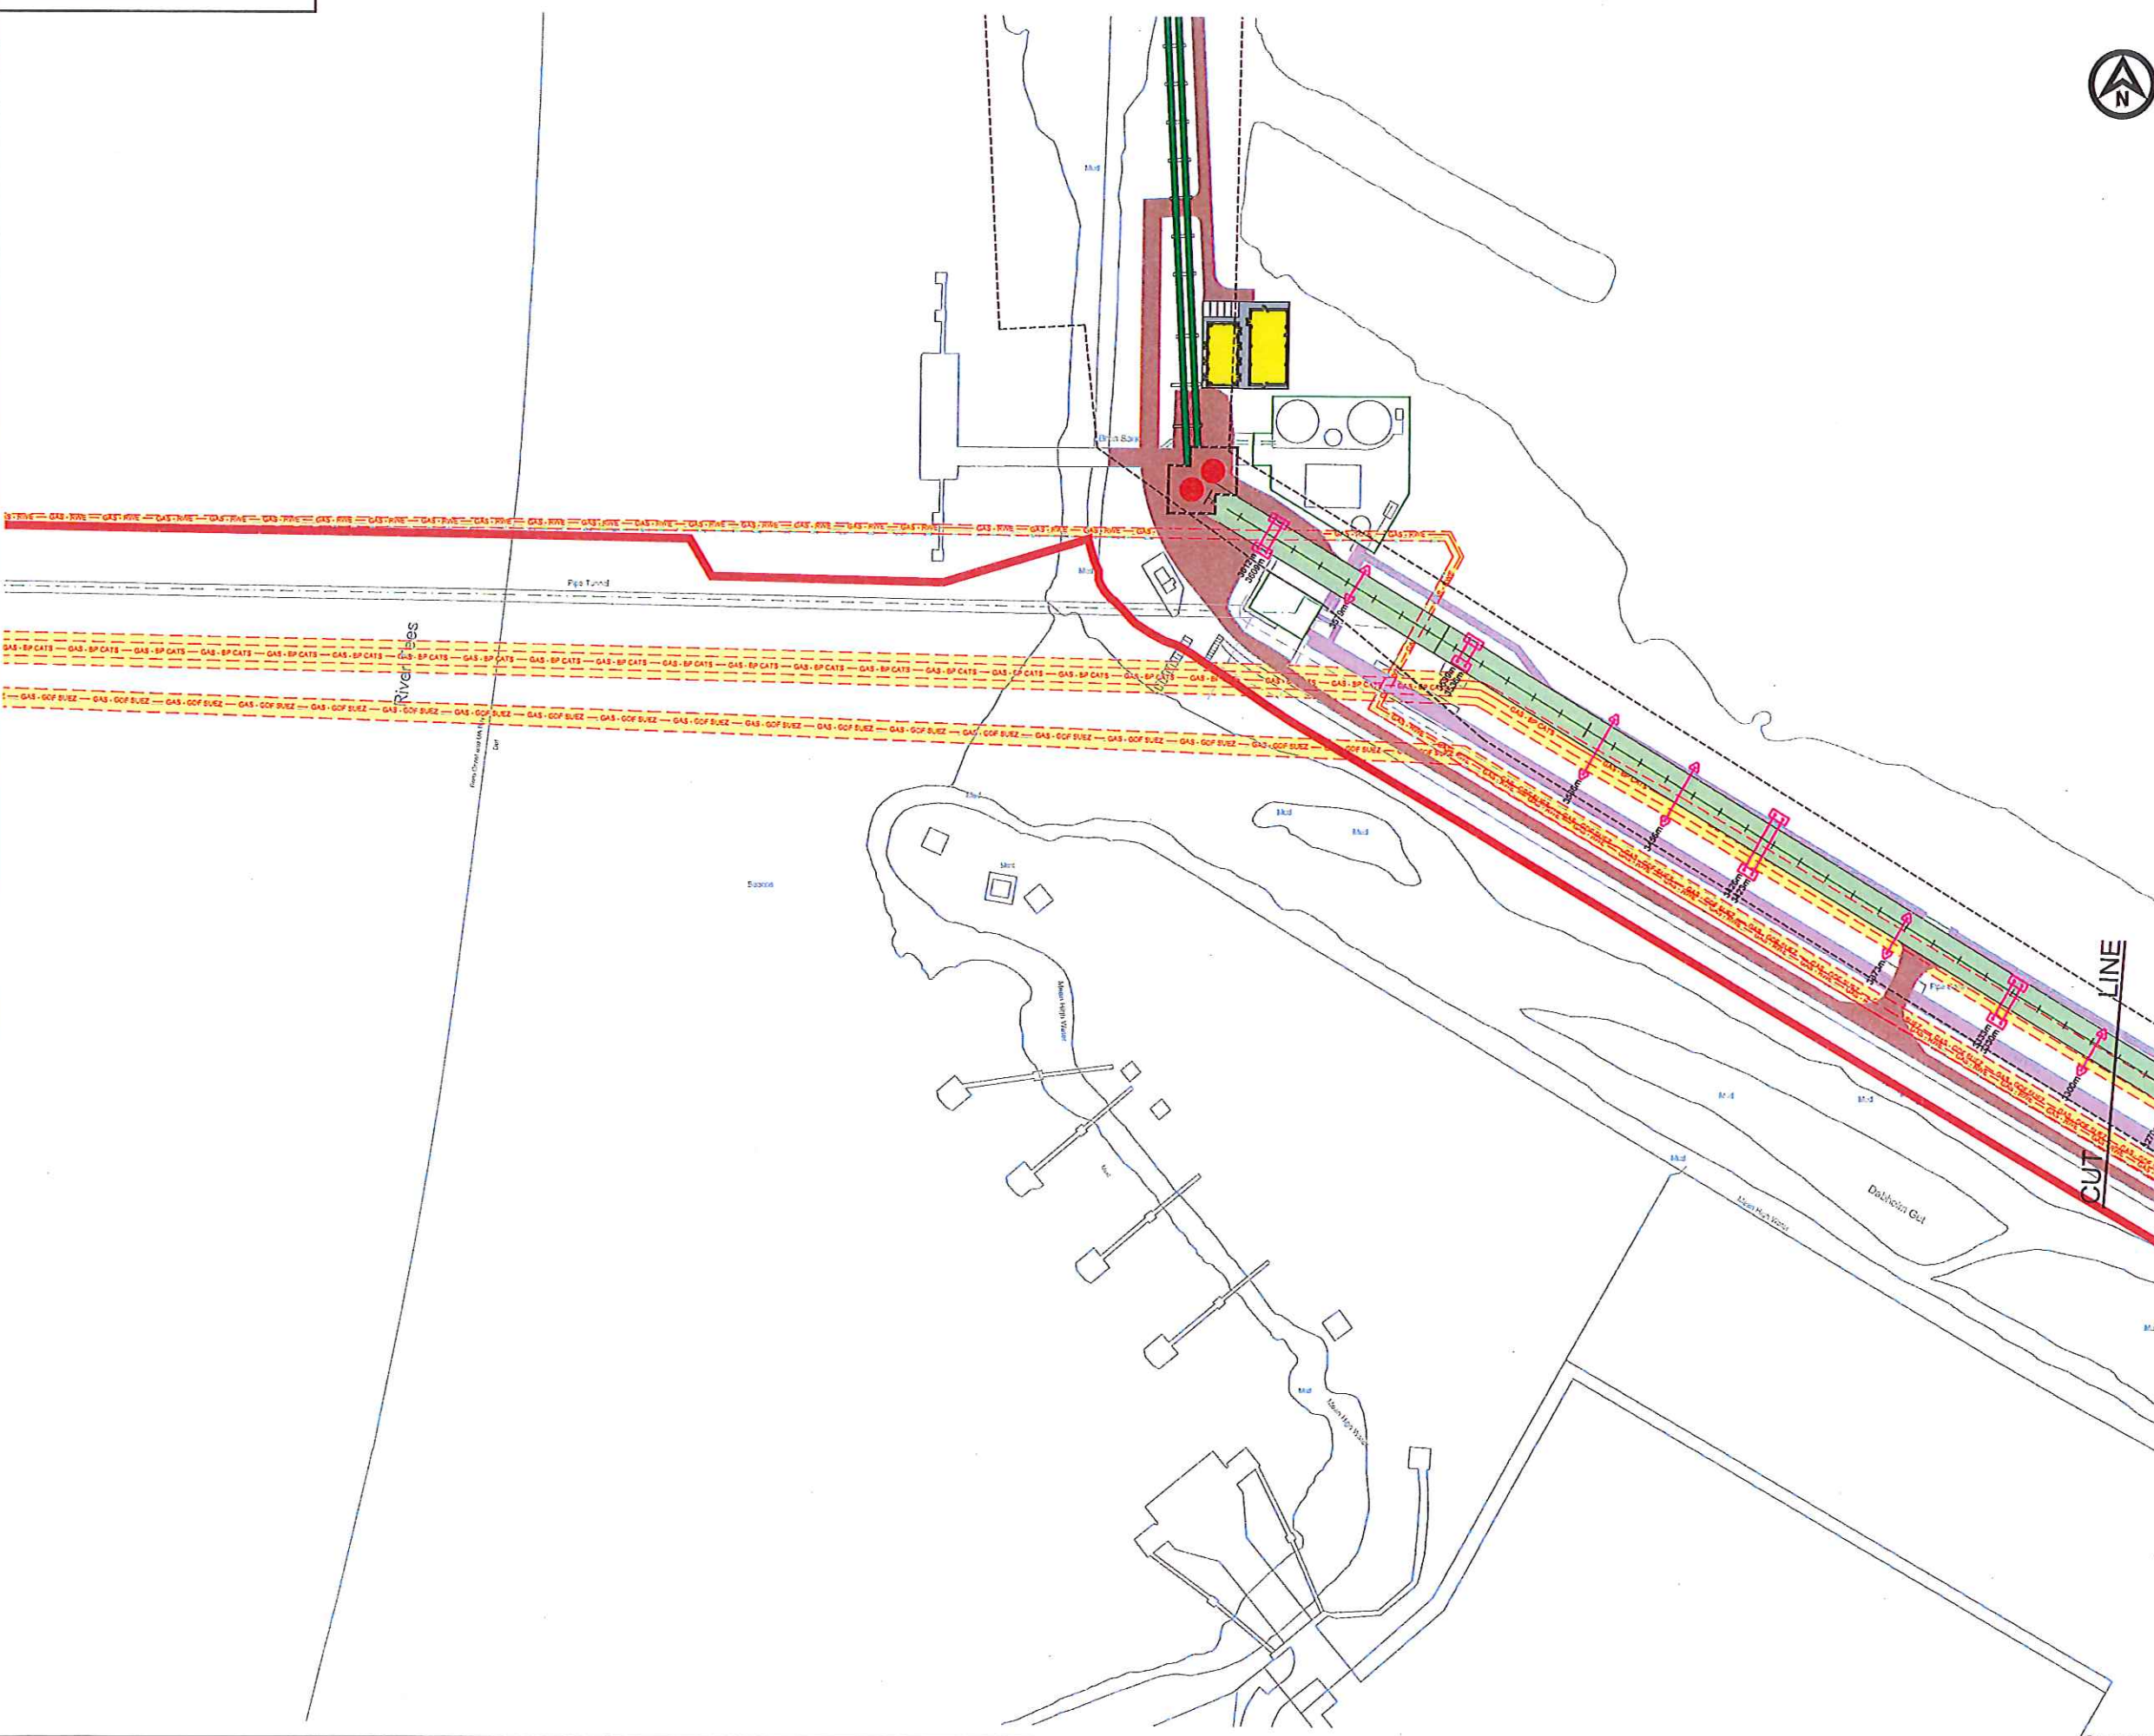

- NOTES
- MAJOR CROSSINGS
- MC 0: Eastern Boundary Road - Pass over in bridge
 - MC 1: Highway A1055 - Pass over in bridge
 - MC 2: YPL 1st access road - Pass over in bridge
 - MC 3: Hot metal rail - Pass over in bridge
 - MC 4: NML 2nd access road - Pass over in bridge
 - MC 5: National power grid lines - Pass under 10 m clearance
 - MC 6: SSI road bridge - Pass over in bridge
 - MC 7: National rail way - Pass over in bridge
 - MC 8: Access NML W.T.P. - Pass over in bridge
 - MC 9: Outfall - Pass over in bridge



- KEY PLAN
SCALE 1:50,000
- LEGEND - CONVEYOR
- TYPE 3 - OPEN CONVEYOR - 2 LEGS
 - TYPE 4 - OVAL ENCLOSED CONVEYOR - 2 LEGS
 - SURGE BINS
 - ACCESS ROADS
 - EXISTING BUILDING
- LEGEND - EXISTING SERVICES
- EASEMENT ZONES
 - GAS - EP CATS
 - GAS - GOF SUEZ
 - GAS - RWE
 - FIBRE OPTIC CABLE
 - MISC - DRAINS, CABLES, DUCTS
 - FOUL WATER - SEMBOCORP
 - WATER - NWL
 - GAS - ABANDONED
 - ABOVEGROUND PIPELINE CORRIDOR
 - OVERHEAD POWER CABLES
 - CONVEYOR FOOTINGS
 - CONVEYOR AT THE QUAY
 - CONVEYOR LIMITS OF DEVIATION

E	10/10/15	PLANNING ISSUE	LW	DGB	MM
D	10/10/15	MINOR REVISIONS	CH	DGB	MM
C	10/10/15	MINOR REVISIONS	LW	DGB	MM
B	10/10/15	ISSUED FOR INFORMATION	TF	DGB	MM
A	10/10/15	ISSUED FOR INFORMATION	LW	DGB	SM
REV	DATE	DESCRIPTION	BY	CHK	APP

REVISIONS




PROJECT
YORK POTASH

TITLE
THE YORK POTASH
HARBOUR FACILITIES ORDER 201X
CONVEYOR ROUTE PLANS
SOUTHERN ROUTE - SHEET 6
REGULATION 5(2)(c) DOCUMENT 3.3G

HASKONINGDHV UK LTD
MARITIME & WATERWAYS
Marborough House
Marborough Crescent
Newcastle upon Tyne NE1 6EE
+44 (0) 191 211 1100 Telephone
+44 (0) 191 211 1103 Fax
info@haskoningdhv.co.uk E-mail
www.haskoningdhv.com Internet

DRAWN	LW	CHECKED	DGB	PASSED	SM
DATE	JAN15	CLIENT'S REF.			
SCALE AT A1	1:1000	AUTOCAD REF.	PB1586-SK1046		
DRAWING NO.	PB1586-SK1046	REVISION	E		

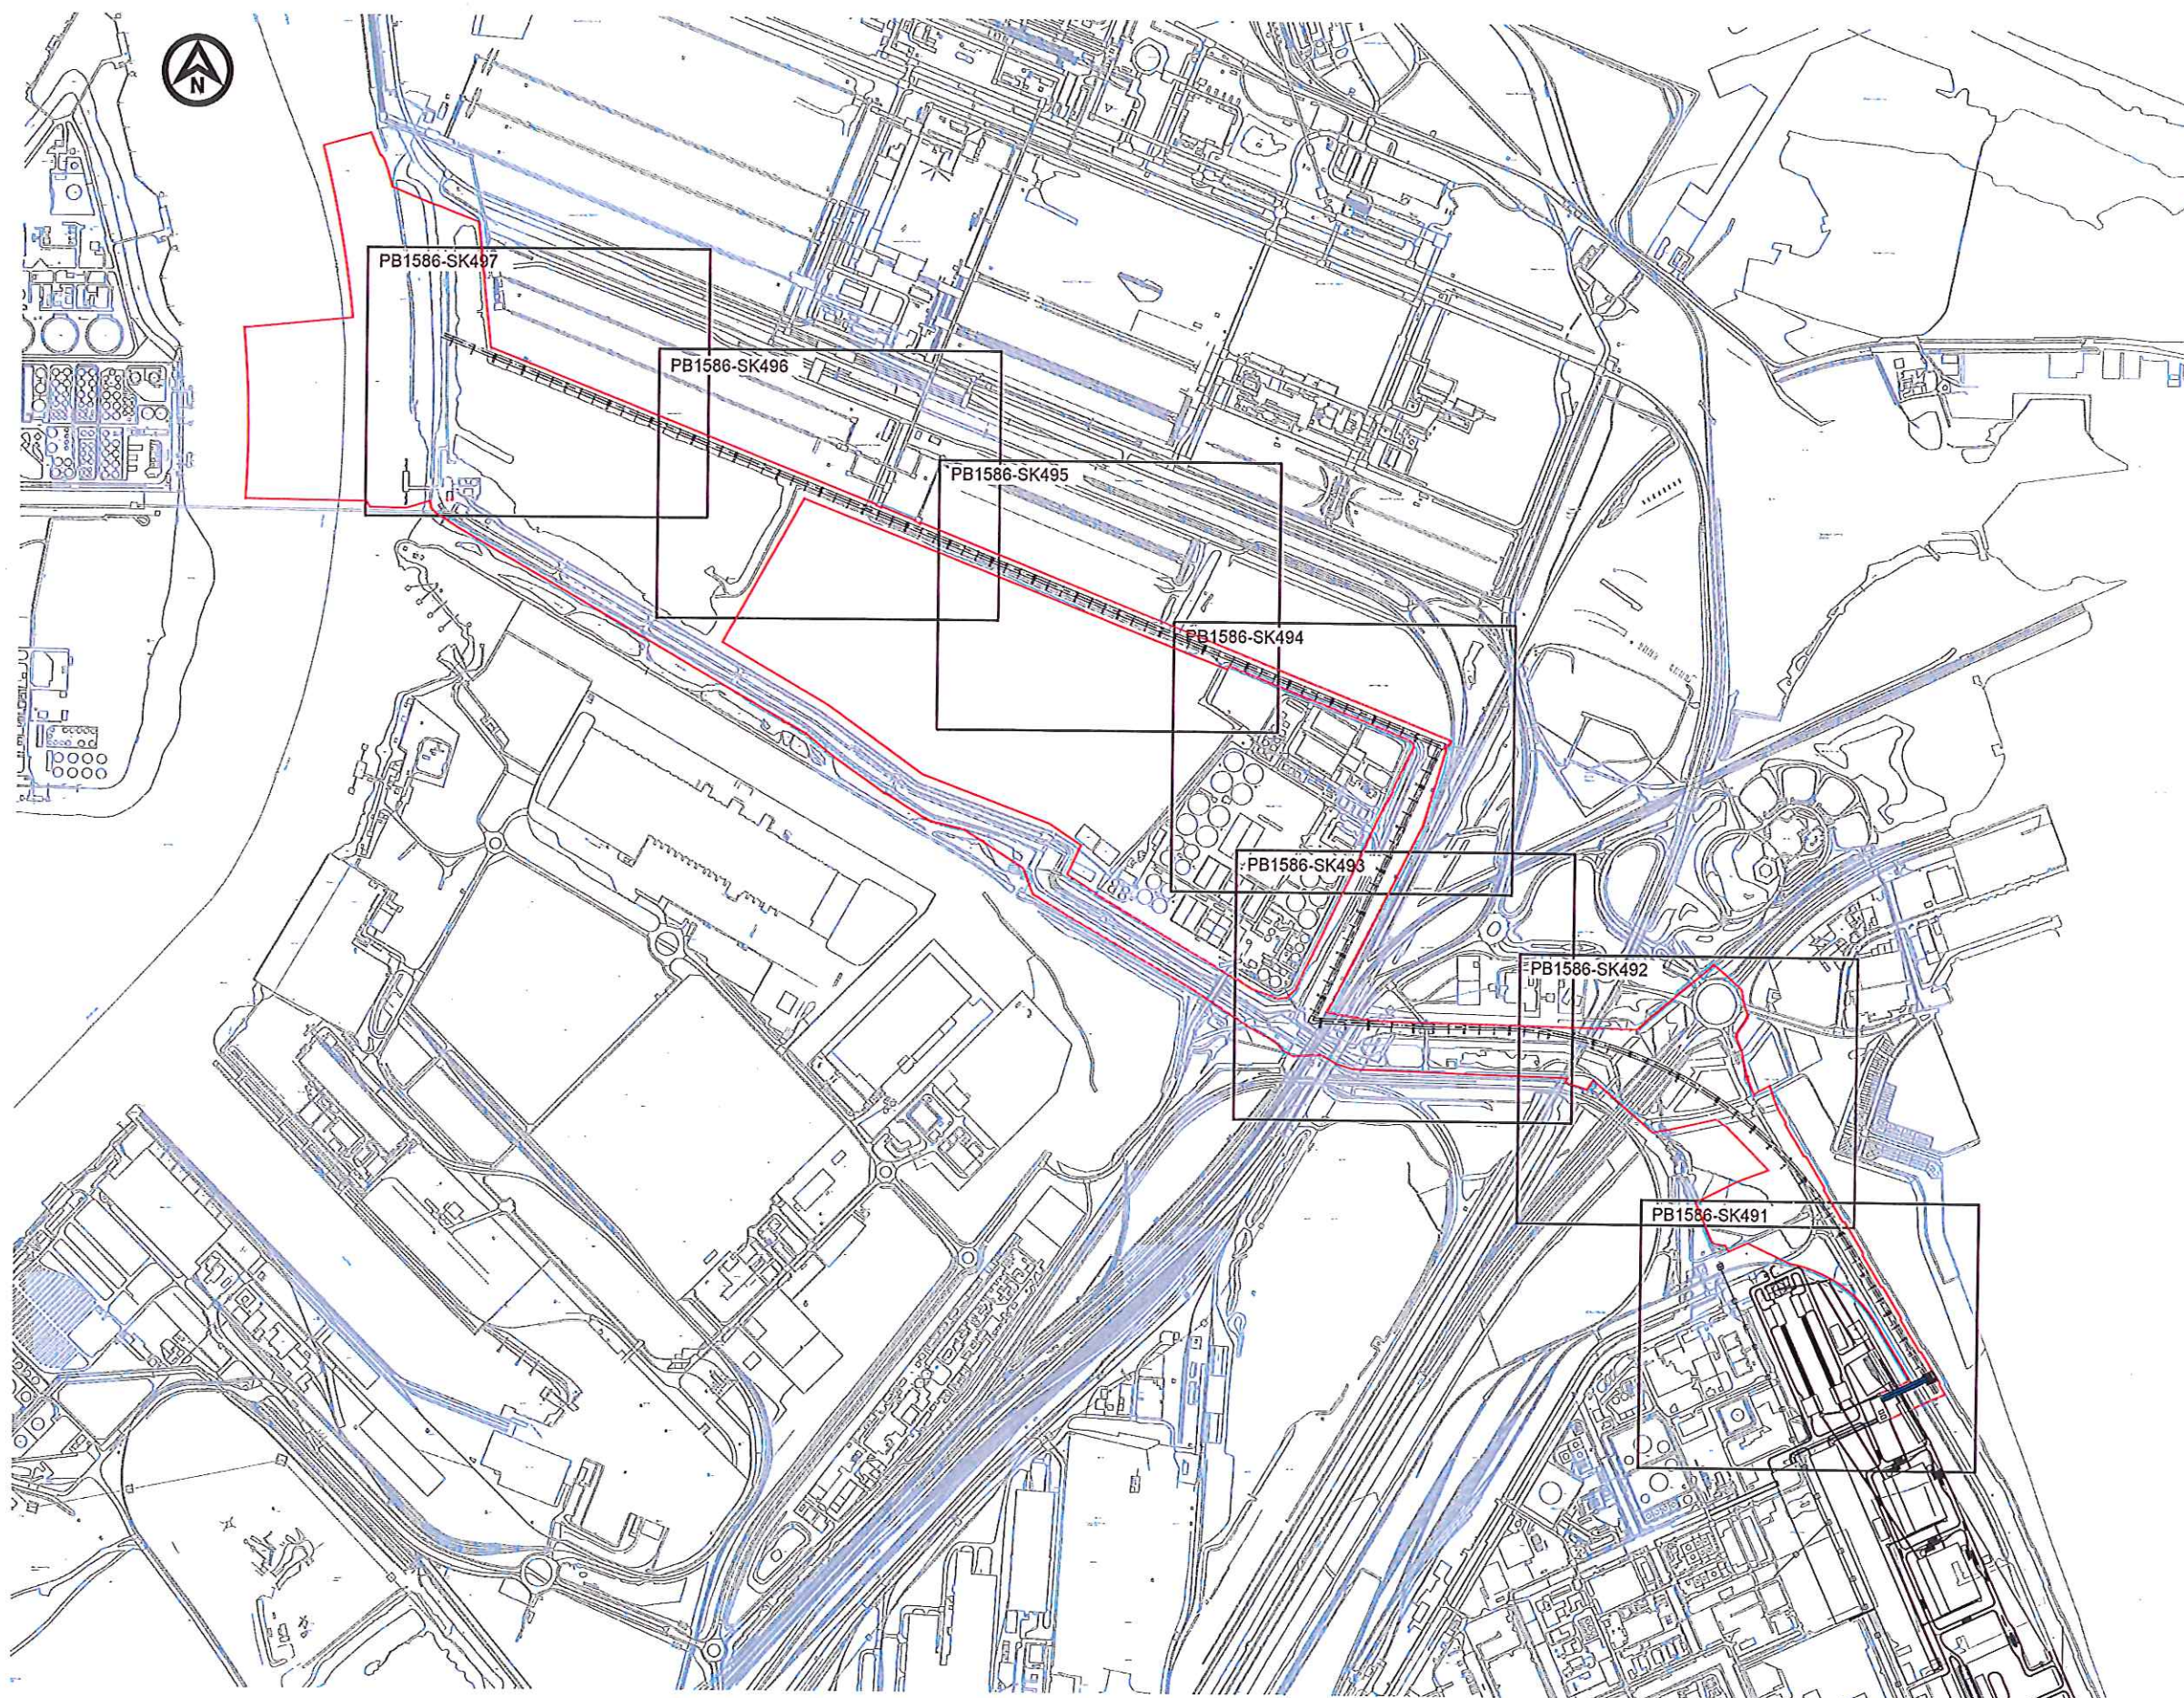

E	14.03.15	PLANNING ISSUE	LW	DGB	MR
D	14.03.15	MINOR REVISIONS	CH	DGB	MR
C	14.03.15	MINOR REVISIONS	LW	DGB	MR
B	14.03.15	ISSUED FOR INFORMATION	TF	DGB	MR
A	14.03.15	FIRST ISSUE	LW	DGB	RAP
REV	DATE	DESCRIPTION	BY	CHK	APP

REVISIONS



PROJECT

YORK POTASH


TITLE

THE YORK POTASH
HARBOUR FACILITIES ORDER 201X
CONVEYOR NORTHERN ROUTE - KEY PLAN
REGULATION 5(2)(c)
DOCUMENT 3.3H



DRAWN	LW	CHECKED	DGB	PASSED	RWP
DATE	FEB 15	CLIENT'S REF.			
SCALE AT A1	1:15	AUTOCAD REF.	PB1586-SK490		


DRAWING No.	PB1586-SK490	REVISION	E
-------------	--------------	----------	---

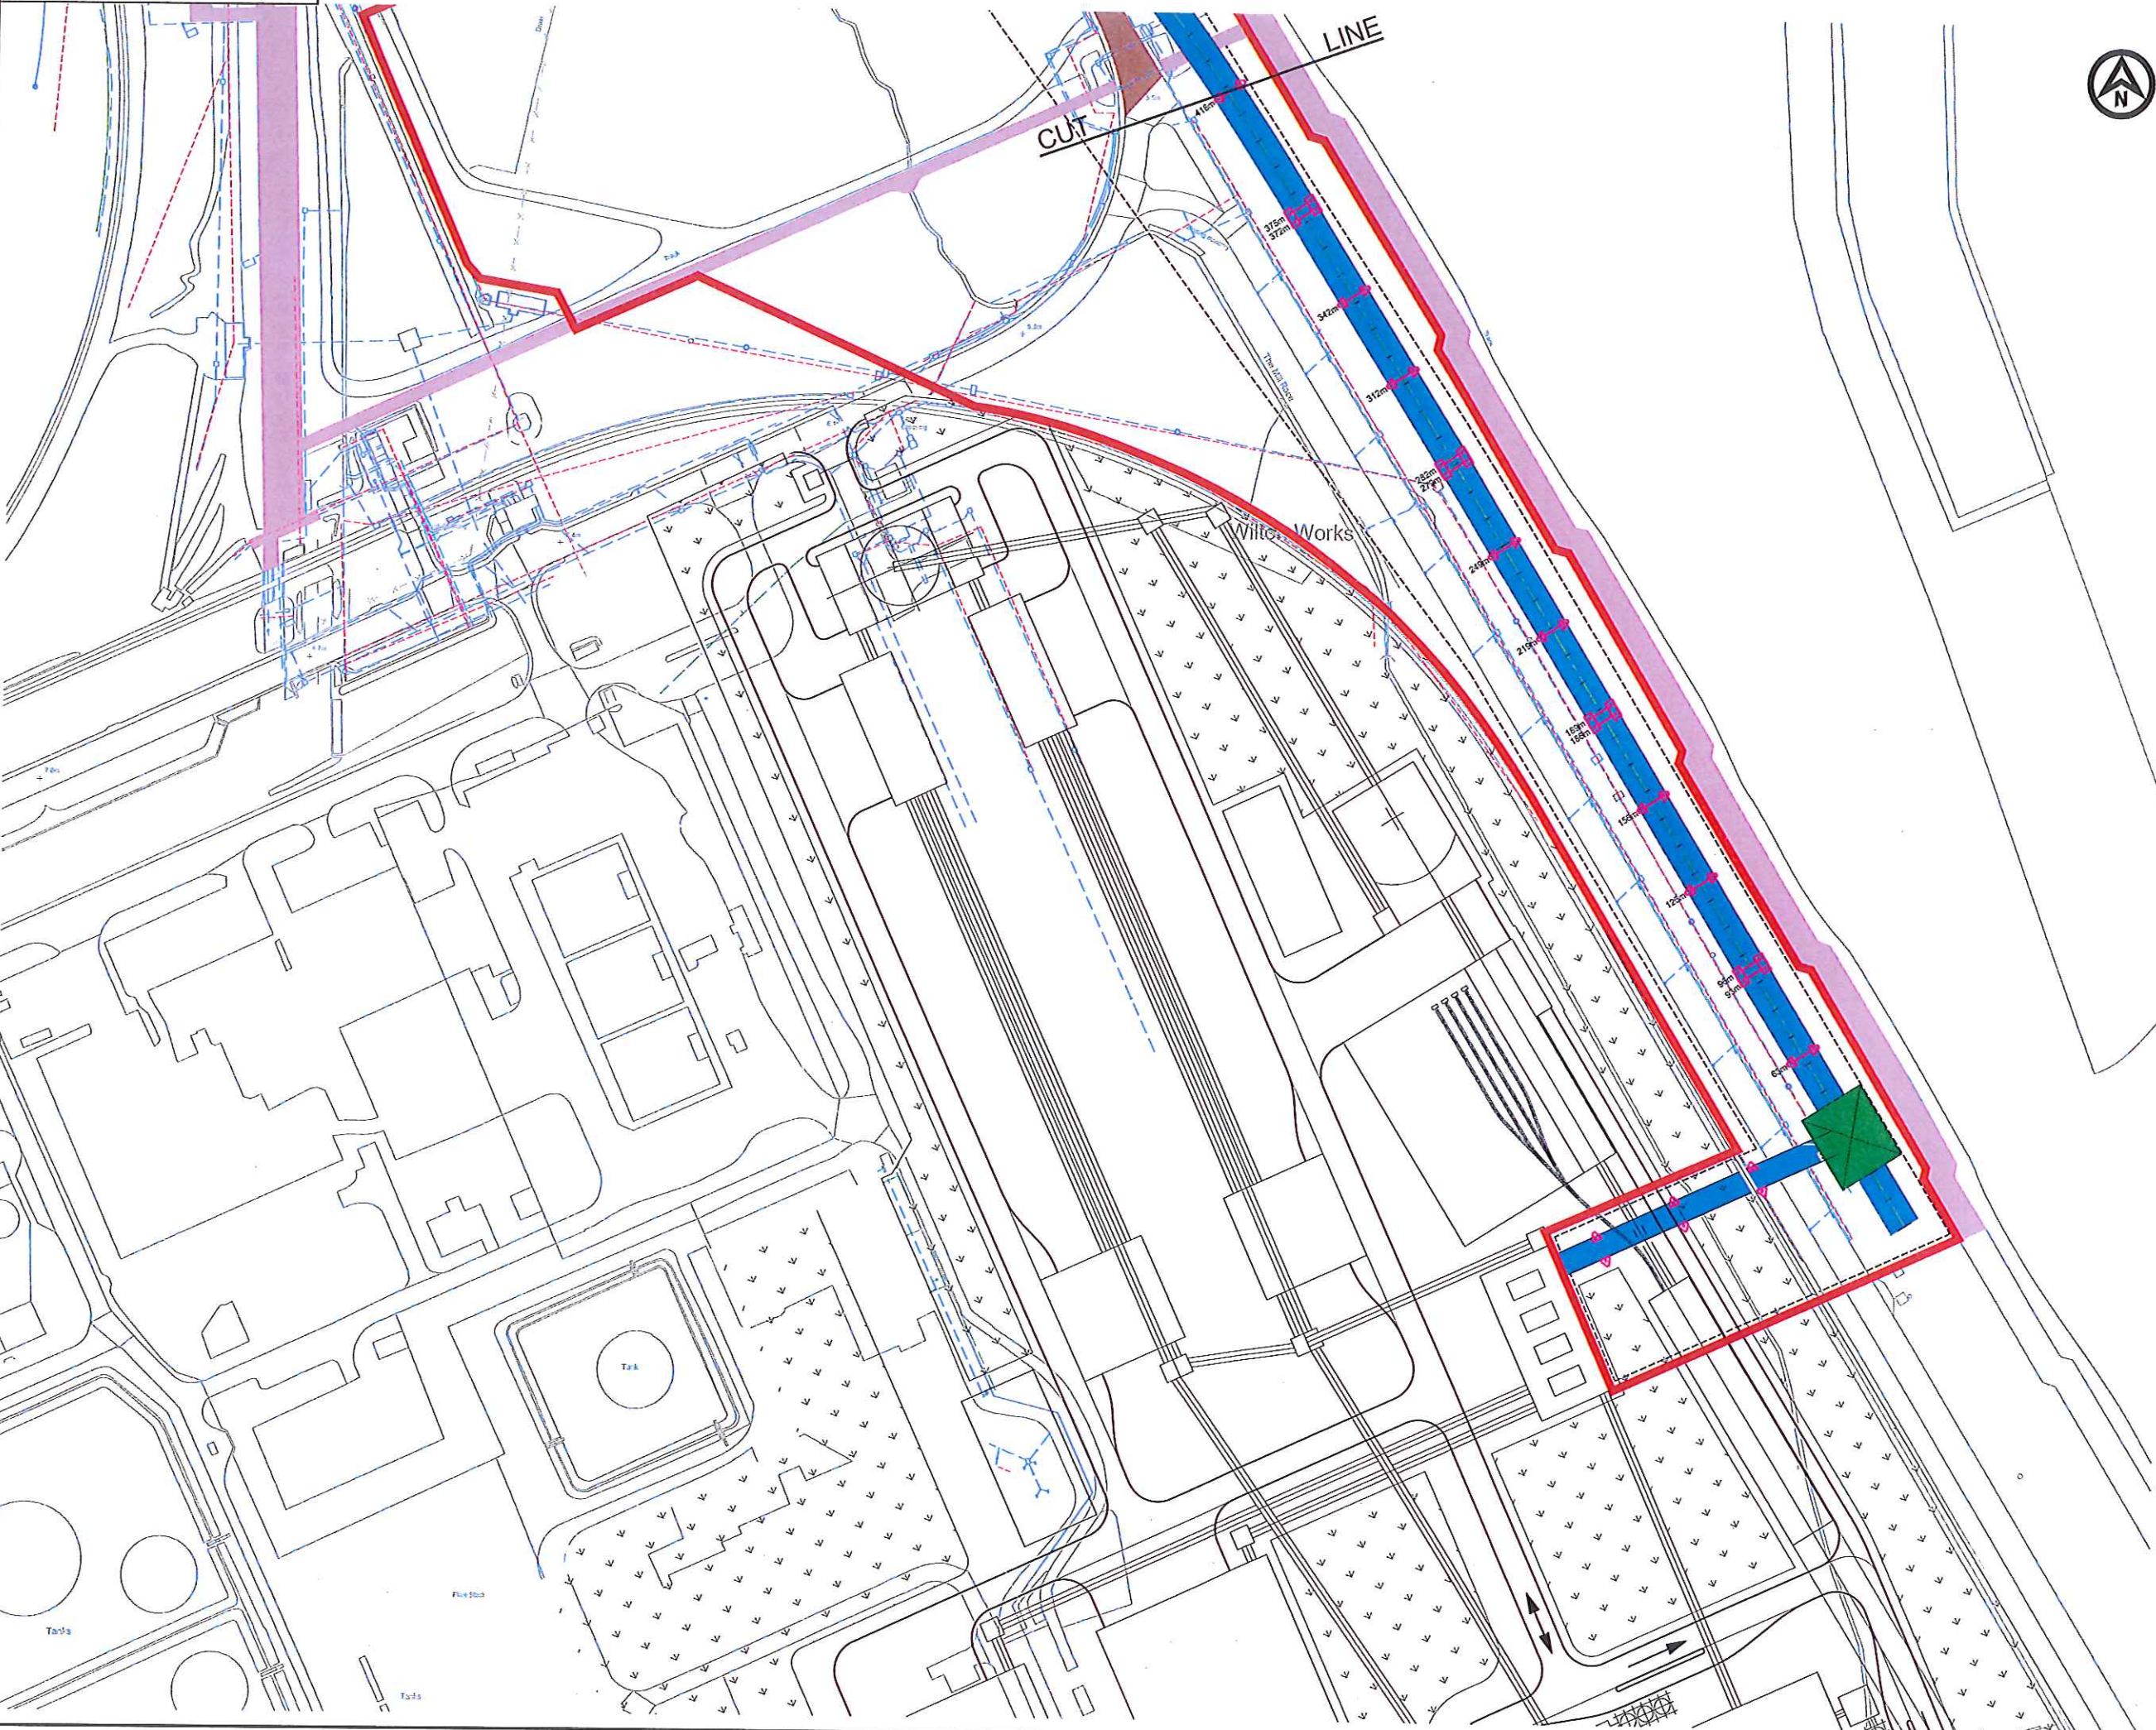

NOTES

MAJOR CROSSINGS

- | | |
|---------------------------------|-----------------------------|
| MC 0: Eastern Boundary Road | - Pass over in bridge |
| MC 1: Highway A1085 | - Pass over in bridge |
| MC 2: YPL 1st access road | - Pass over in bridge |
| MC 3: Hot metal rail | - Pass over in bridge |
| MC 4: NWL 2nd access road | - Pass over in bridge |
| MC 5: National power grid lines | - Pass under 10 m clearance |
| MC 6: SSI road bridge | - Pass over in bridge |
| MC 7: National rail way | - Pass over in bridge |
| MC 8: Access NWL W.T.P. | - Pass over in bridge |
| MC 9: Outfall | - Pass over in bridge |

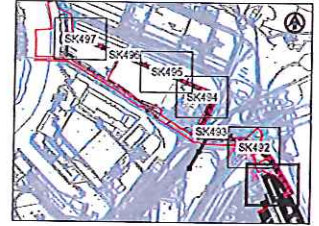

KEY PLAN
SCALE 1:50000

LEGEND - CONVEYOR

- TYPE 3 - OPEN CONVEYOR - 2 LEGS
- TYPE 4 - OVAL ENCLOSED CONVEYOR - 2 LEGS
- TRANSFER TOWER
- ACCESS ROUTES
- CONVEYOR FOOTINGS
- CONVEYOR AT THE QUAY

LEGEND - EXISTING SERVICES

- EASEMENT ZONES
 - GAS - BP CATS
 - GAS - GDF SUEZ
 - GAS - RWE
- FIBRE OPTIC CABLE
- MISC - DRAINS, CABLES, DUCTS
- FOUL WATER - SEASCORP
- WATER - NWL
- GAS - ABANDONED
- ABOVEGROUND PIPELINE CORRIDOR
- OVERHEAD POWER CABLES
- CONVEYOR LATERAL LIMITS OF DEVIATION

E	14.12.14	PLANNING ISSUE	LW	DGB	MH
D	14.12.14	MINOR REVISIONS	CH	DGB	MH
C	12.12.14	MINOR REVISIONS	LW	DGB	MH
B	03.12.14	ISSUED FOR APPROVAL	TF	DGB	MH
A	27.02.15	FIRST ISSUE	LW	DGB	RWP
REV	DATE	DESCRIPTION	BY	CHK	APP




PROJECT
YORK POTASH

TITLE
**THE YORK POTASH
HARBOUR FACILITIES ORDER 201X
CONVEYOR ROUTE PLANS
NORTHERN ROUTE - SHEET 1
REGULATION 5(2)(c) DOCUMENT 3.31**

ROYAL HASKONINGDHV
Enhancing Society Together

HASKONINGDHV UK LTD
MARITIME & WATERWAYS
Marborough House
Newcastle upon Tyne NE1 4EE
+44 (0) 191 211 1330 Telephone
+44 (0) 191 211 1331 Fax
info@haskoningdhv.co.uk E-mail
www.haskoningdhv.co.uk Internet


DRAWN	LW	CHECKED	DGB	PASSED	RWP
DATE	FEB'15	CLIENT'S REF.			
SCALE	AT A1	1:1000	AUTOCAD REF.	PB1586-SK491	
DRAWING No.	PB1586-SK491	REVISION			E

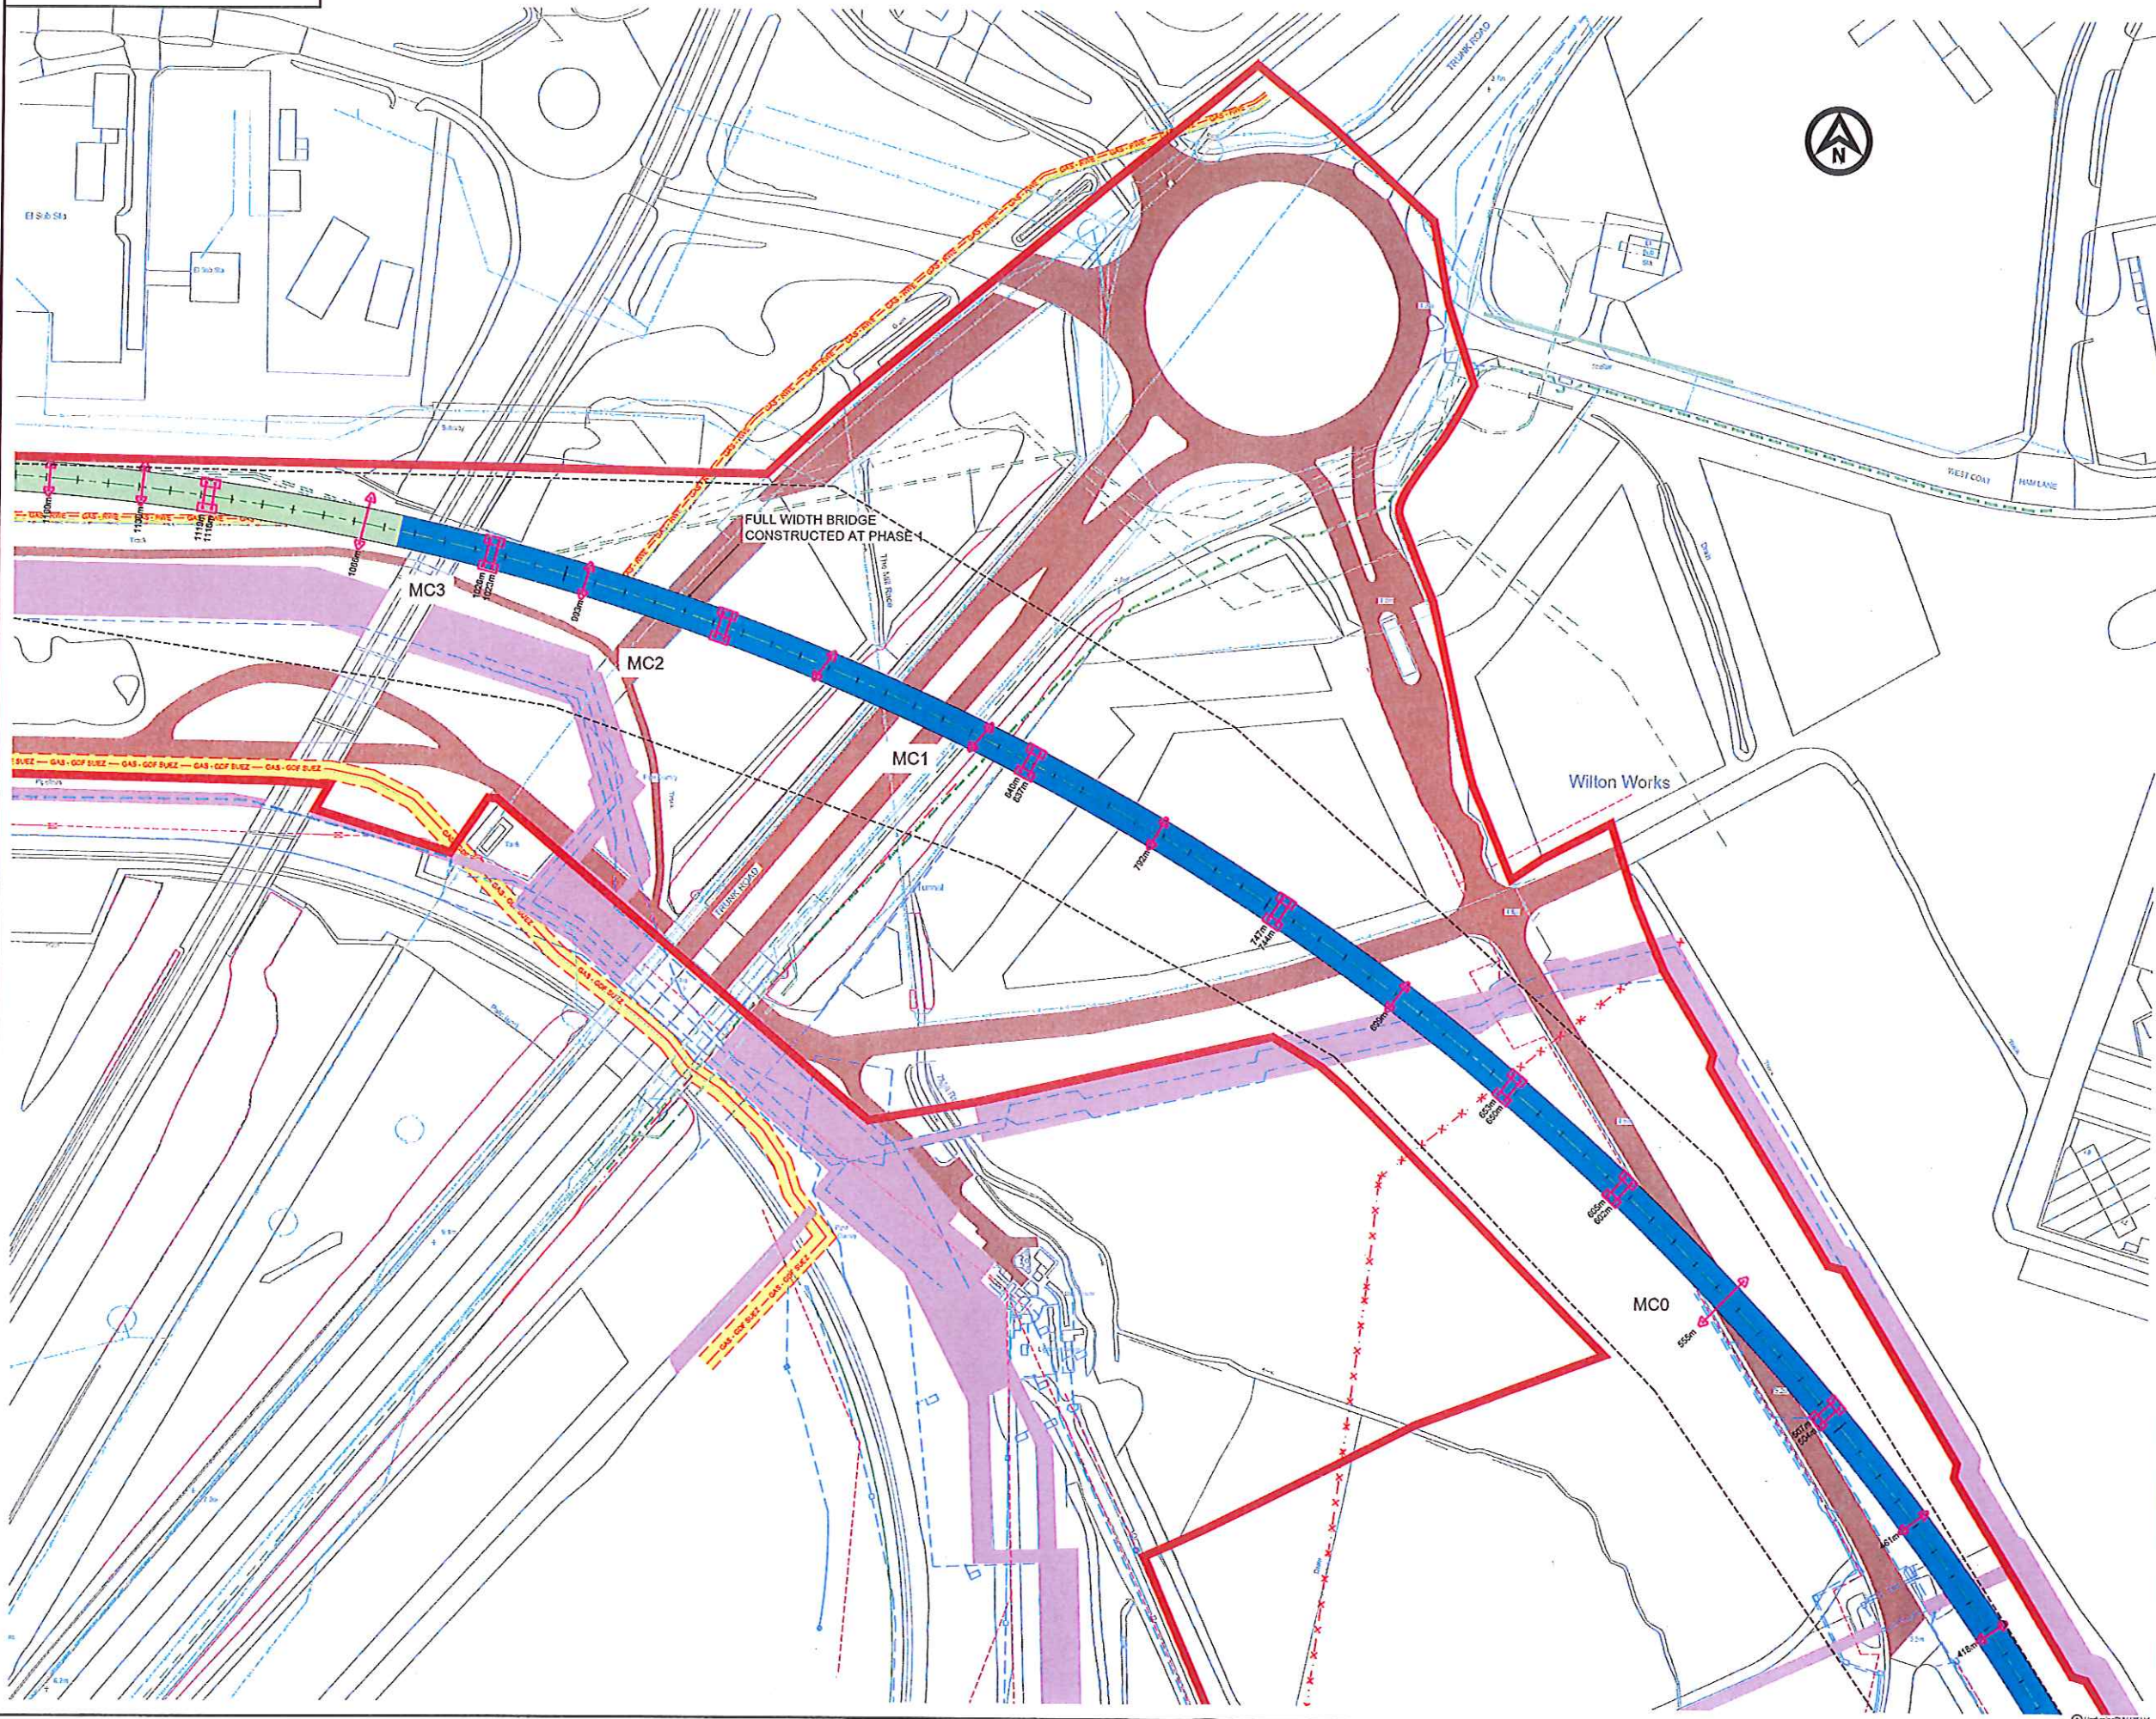

NOTES

MAJOR CROSSINGS

- | | |
|---------------------------------|----------------------------|
| MC 0: Eastern Boundary Road | - Pass over in bridge |
| MC 1: Highway A1055 | - Pass over in bridge |
| MC 2: YPL 1st access road | - Pass over in bridge |
| MC 3: Hot metal rail | - Pass over in bridge |
| MC 4: NWL 2nd access road | - Pass over in bridge |
| MC 5: National power grid lines | - Pass under 13m clearance |
| MC 6: SSI road bridge | - Pass over in bridge |
| MC 7: National rail way | - Pass over in bridge |
| MC 8: Access NWL W.T.P. | - Pass over in bridge |
| MC 9: Outfall | - Pass over in bridge |

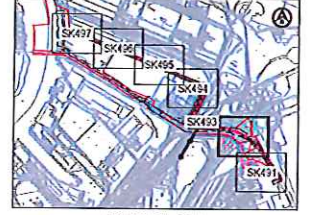

KEY PLAN
SCALE 1:50000

LEGEND - CONVEYOR

- TYPE 3 - OPEN CONVEYOR - 2 LEGS
- TYPE 4 - OVAL ENCLOSED CONVEYOR - 2 LEGS
- TRANSFER TOWER

LEGEND - EXISTING SERVICES

- ACCESS ROUTES
- CONVEYOR FOOTINGS
- CONVEYOR AT THE QUAY
- EASEMENT ZONES
 - GAS - BP CATS
 - GAS - GDF SUEZ
 - GAS - RWE
 - FIBRE OPTIC CABLE
 - MISC - DRAINS, CABLES, DUCTS
 - FOUL WATER - SEMCORP
 - WATER - MWL
 - GAS - ABANDONED
- ABOVEGROUND PIPELINE CORRIDOR
- OVERHEAD POWER CABLES
- CONVEYOR LATERAL LIMITS OF DEVIATION

REV	DATE	DESCRIPTION	BY	CHK	APP
E	15.03.15	PLANNING ISSUE	LW	DGB	MH
D	15.03.15	MINOR REVISIONS	CH	DGB	MH
C	15.03.15	MINOR REVISIONS	LW	DGB	MH
B	15.03.15	ISSUED FOR APPROVAL	TF	DGB	MH
A	15.03.15	FIRST ISSUE	LW	DGB	RVP

REVISIONS




PROJECT
YORK POTASH

TITLE
**THE YORK POTASH
HARBOUR FACILITIES ORDER 201X
CONVEYOR ROUTE PLANS
NORTHERN ROUTE - SHEET 2
REGULATION 5(2)(e) DOCUMENT 3.3J**

Royal HaskoningDHV
Enhancing Society Together
HASKONINGDHV UK LTD
MARITIME & WATERWAYS
Maritime House
Marlborough Crescent
Newcastle upon Tyne NE1 1AE
Tel: 0191 251 1300
Fax: 0191 251 1313
Email: info@haskoningdhv.co.uk
www.haskoningdhv.co.uk


DRAWN	LW	CHECKED	DGB	PASSED	RVP
DATE	FEB 15	CLIENTS REF.			
SCALE AT A1	1:1000	AUTOCAD REF.	PB1586-SK492		
DRAWING NO.	PB1586-SK492	REVISION	E		

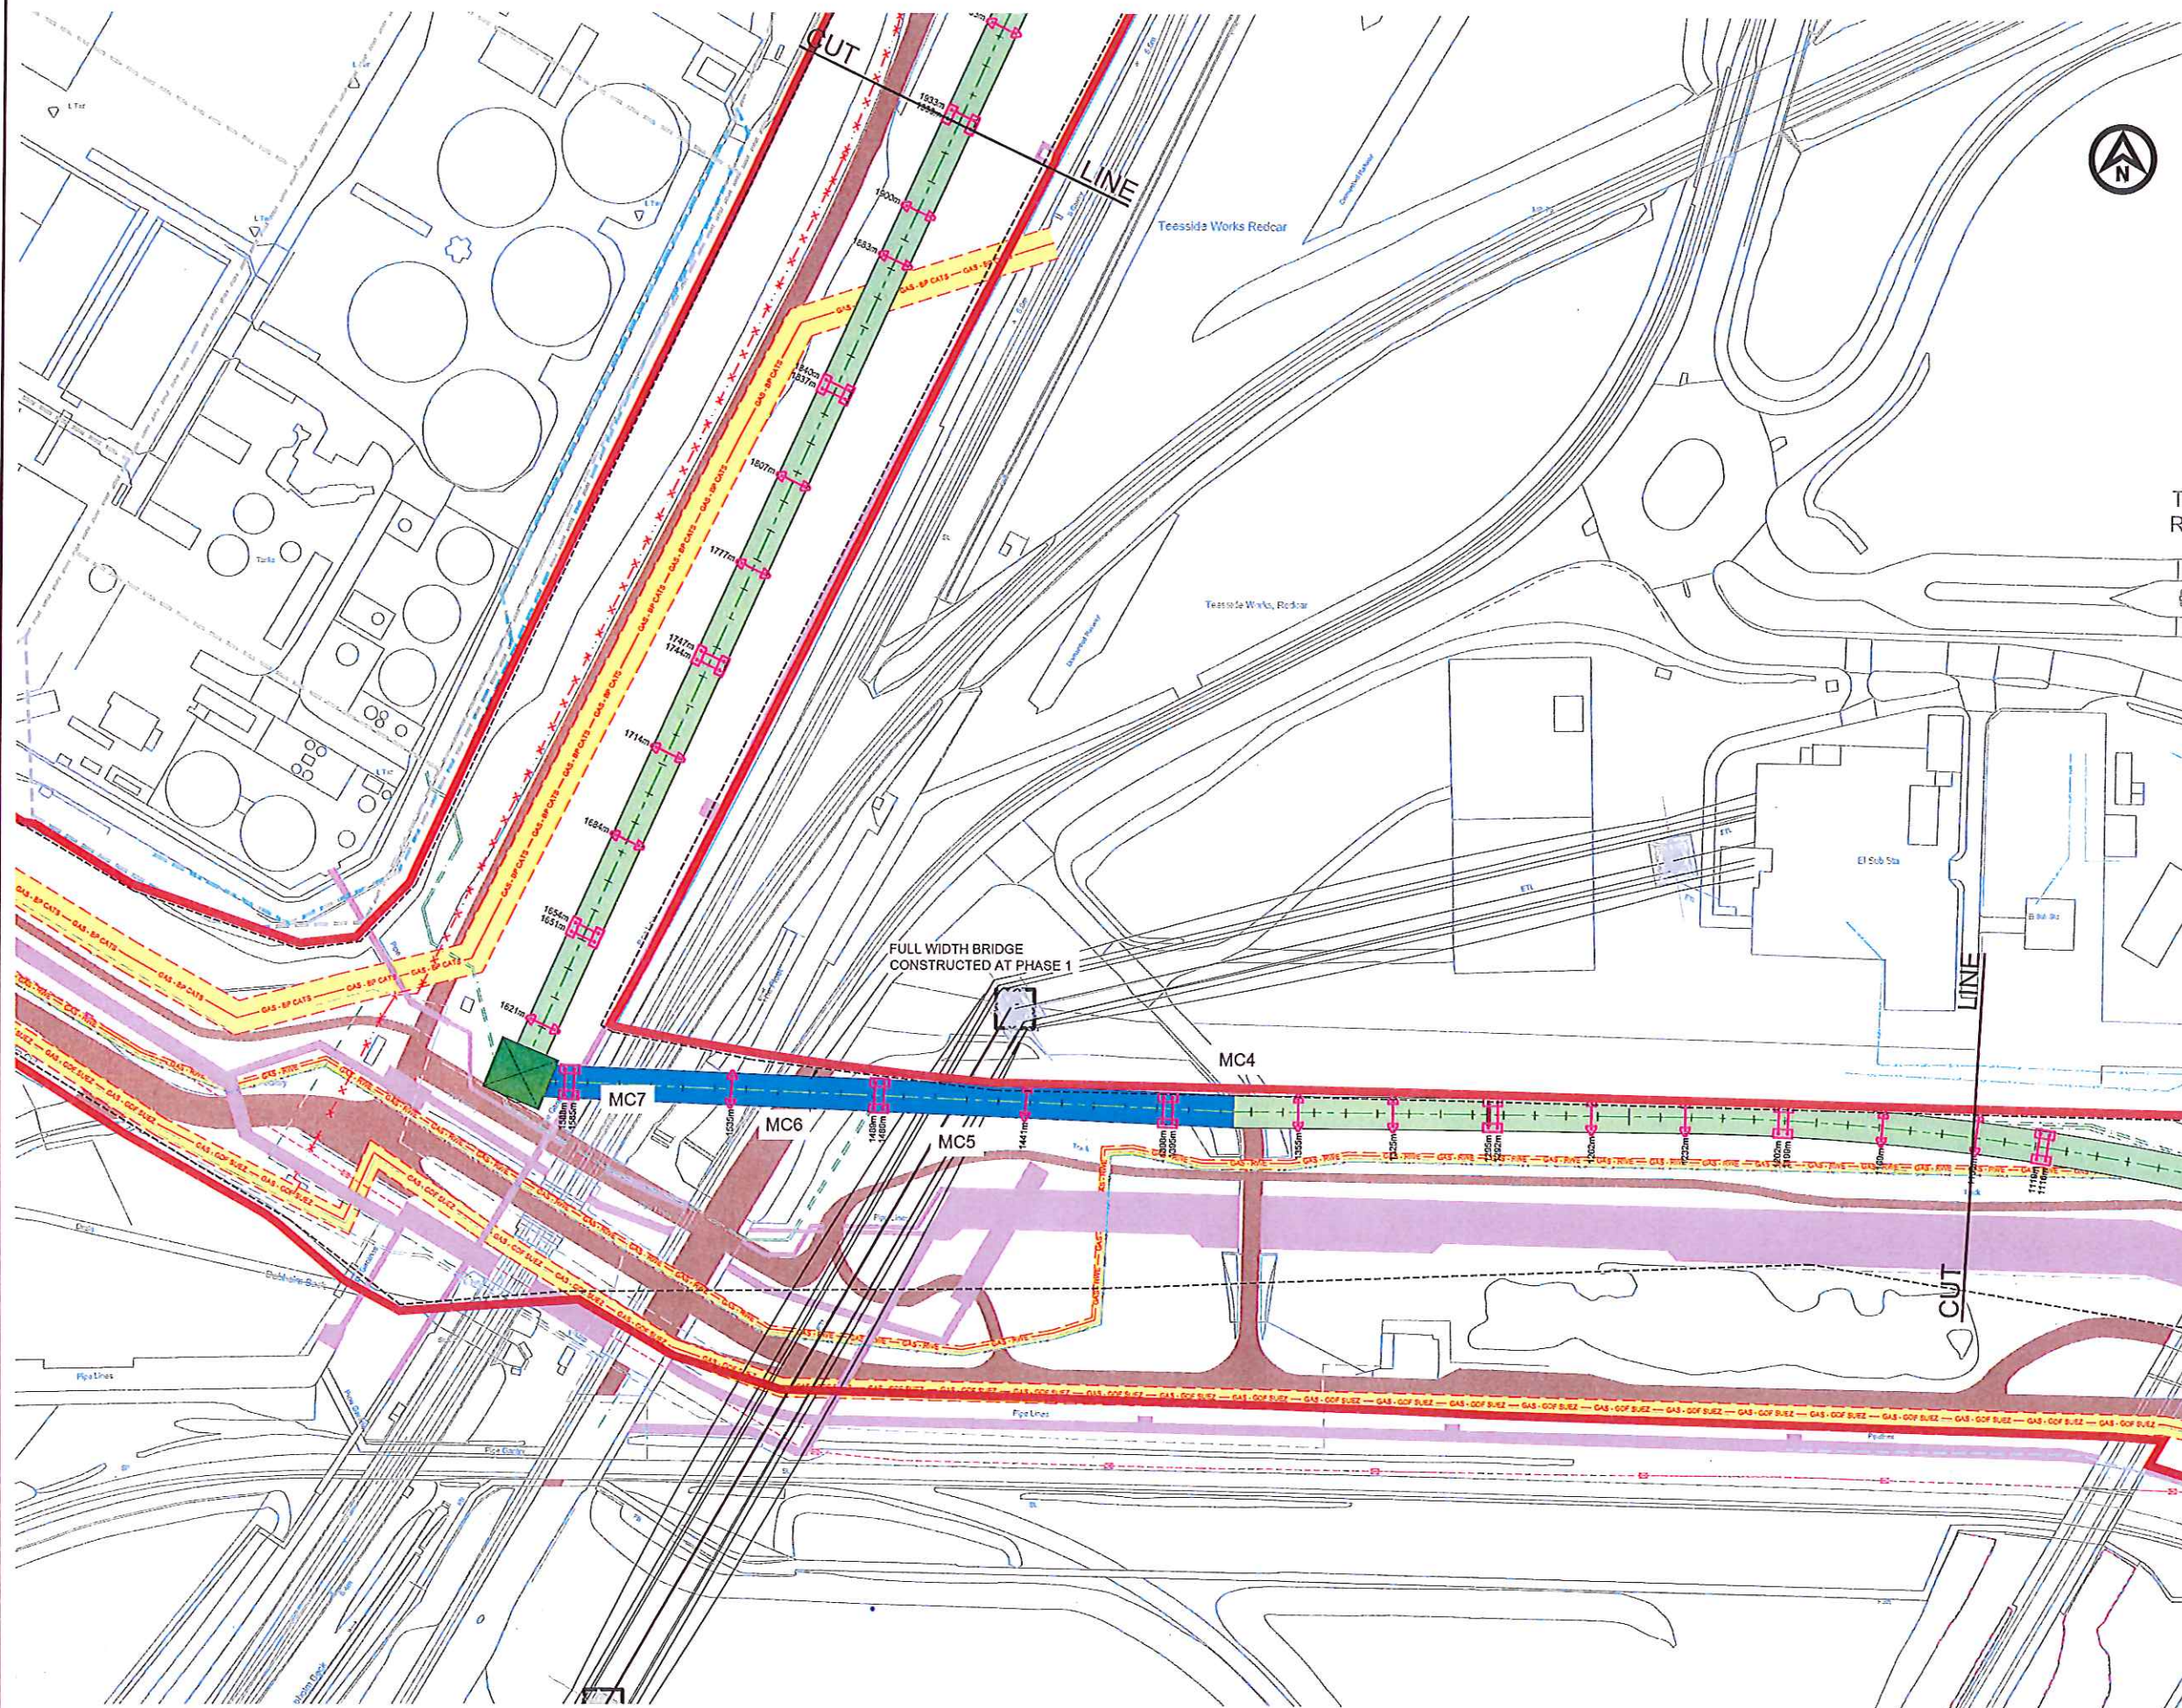

NOTES

MAJOR CROSSINGS

- | | |
|--------------------------------|-----------------------------|
| MC 0: Eastern Boundary Road | - Pass over in bridge |
| MC 1: Highway A1035 | - Pass over in bridge |
| MC 2: YPL 1st access road | - Pass over in bridge |
| MC 3: Hot metal rail | - Pass over in bridge |
| MC 4: NWL 2nd access road | - Pass over in bridge |
| MC 5: National power g/d lines | - Pass under 10 m clearance |
| MC 6: SSI road bridge | - Pass over in bridge |
| MC 7: National rail way | - Pass over in bridge |
| MC 8: Access NWL W.T.P. | - Pass over in bridge |
| MC 9: Outfall | - Pass over in bridge |

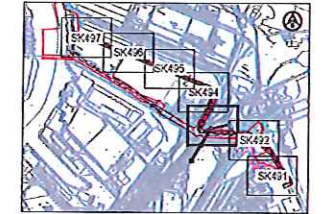

KEY PLAN
SCALE 1:50000

LEGEND - CONVEYOR

- TYPE 3 - OPEN CONVEYOR - 2 LEGS
- TYPE 4 - OVAL ENCLOSED CONVEYOR - 2 LEGS

- TRANSFER TOWER
- ACCESS ROUTES
- CONVEYOR FOOTINGS
- CONVEYOR AT THE QUAY

LEGEND - EXISTING SERVICES

- EASEMENT ZONES
- GAS - EP CATS
- GAS - GOF SUEZ
- GAS - RWE
- FIBRE OPTIC CABLE
- MSC - DRAINS, CABLES, DUCTS
- FOUL WATER - SEMECORP
- WATER - NWL
- GAS - ABANDONED
- ABOVEGROUND PIPELINE CORRIDOR
- OVERHEAD POWER CABLES
- CONVEYOR LATERAL LIMITS OF DEVIATION

REV	DATE	DESCRIPTION	BY	CHK	APP
E	14/01/15	PLANNING ISSUE	LW	DGB	MH
D	15/01/15	MINOR REVISIONS	CH	DGB	MH
C	16/01/15	MINOR REVISIONS	LW	DGB	MH
B	17/01/15	ISSUED FOR APPROVAL	TF	DGB	MH
A	17/01/15	FIRST ISSUE	LW	DGB	RWP

REVISIONS




PROJECT
YORK POTASH


TITLE
**THE YORK POTASH
HARBOUR FACILITIES ORDER 201X
CONVEYOR ROUTE PLANS
NORTHERN ROUTE - SHEET 3
REGULATION 5(2)(o) DOCUMENT 3.3K**

Royal HaskoningDHV
Enhancing Society Together
HASKONINGDHV UK LTD
MARITIME & WATERWAYS
Maritime House
Marine Parade
Newcastle upon Tyne NE1 4EE
+44 (0) 191 211 1200
+44 (0) 191 211 1213
info@haskoningdhv.com
www.haskoningdhv.com

DRAWN	LW	CHECKED	DGB	PASSED	RWP
DATE	FEB 15	CLIENT'S REF.			
SCALE	AT 1:1000	AUTOCAD REF.	PB1586-SK493		
DRAWING No.	PB1586-SK493	REVISION			
					E

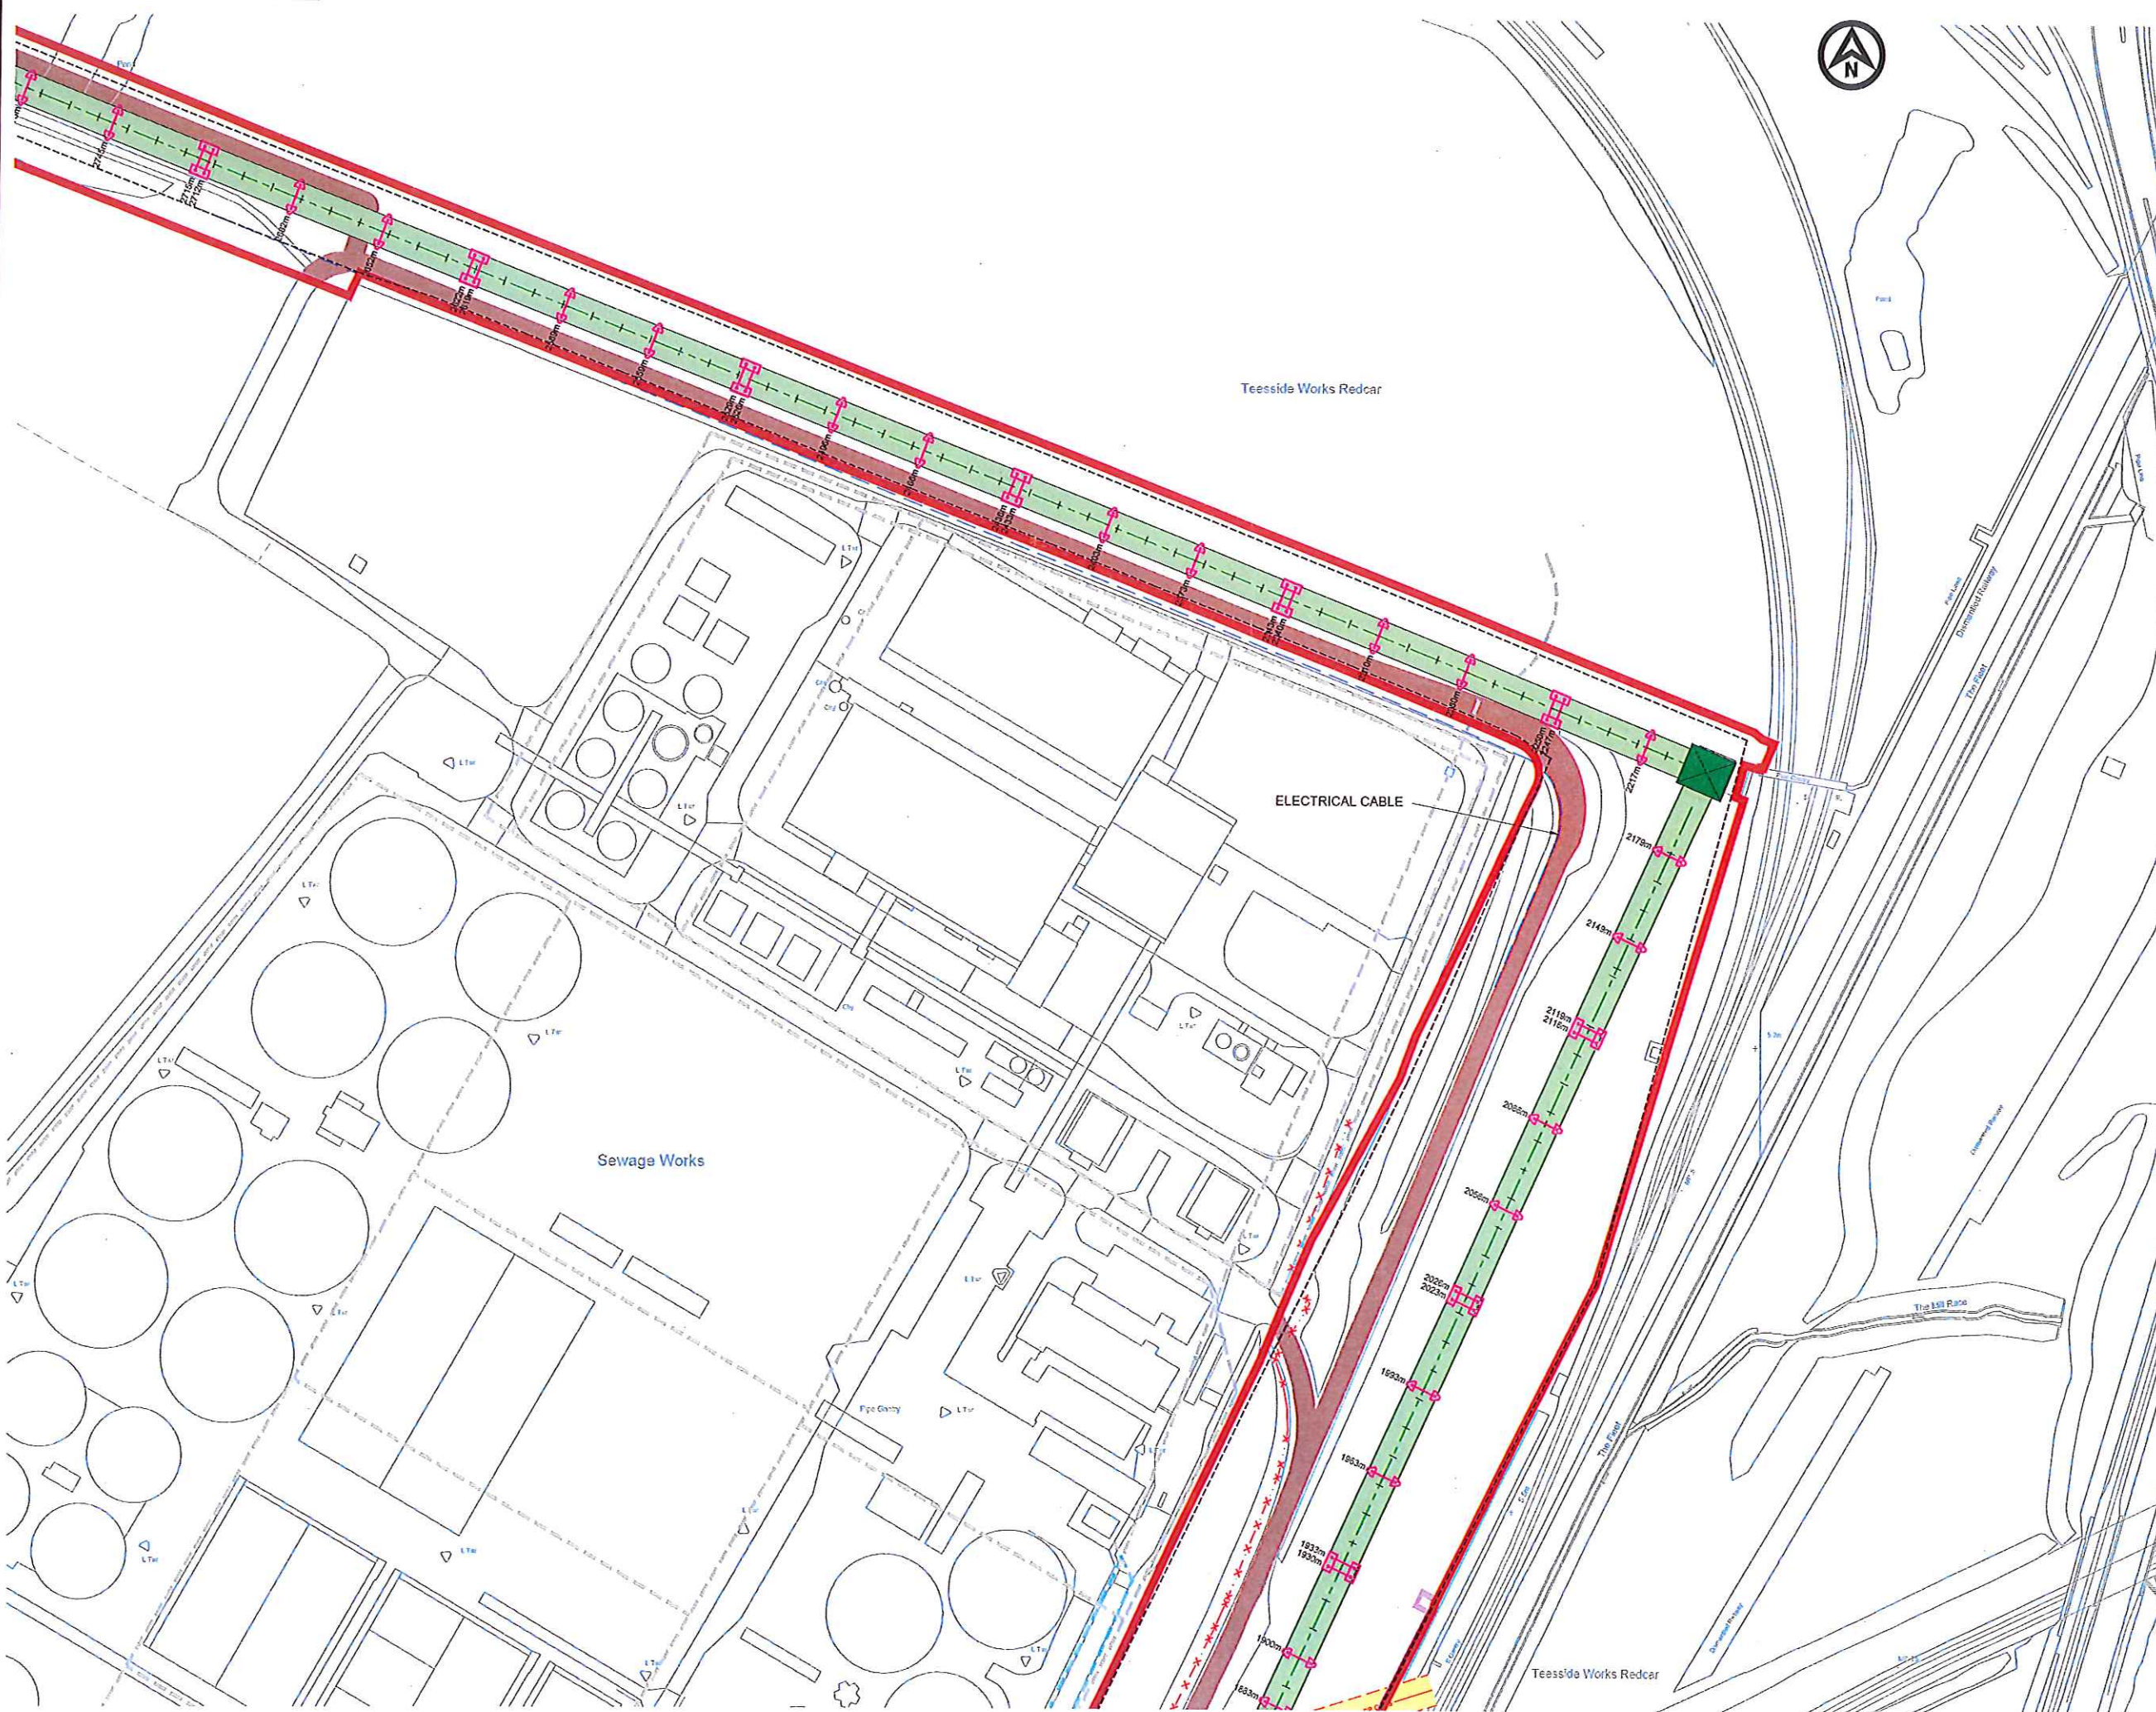

- NOTES**
1. FOR QUAY PLAN DETAILS REFER TO DRAWINGS NO. PB1586-SK91, SK93, SK122 & SK123.
- MAJOR CROSSINGS**
- | | |
|---------------------------------|-----------------------------|
| MC 0: Eastern Boundary Road | - Pass over in bridge |
| MC 1: Highway A1055 | - Pass over in bridge |
| MC 2: YFL 1st access road | - Pass over in bridge |
| MC 3: Hot metal rail | - Pass over in bridge |
| MC 4: NWL 2nd access road | - Pass over in bridge |
| MC 5: National power grid lines | - Pass under 10 m clearance |
| MC 6: SSI road bridge | - Pass over in bridge |
| MC 7: National rail way | - Pass over in bridge |
| MC 8: Access NWL W.T.P. | - Pass over in bridge |
| MC 9: Outfall | - Pass over in bridge |

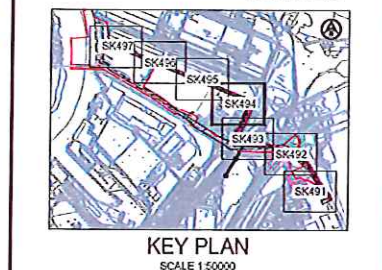

- LEGEND - CONVEYOR**
- TYPE 3 - OPEN CONVEYOR - 2 LEGS
 - TYPE 4 - OVAL ENCLOSED CONVEYOR - 2 LEGS
 - TRANSFER TOWER
 - ACCESS ROUTES
 - CONVEYOR FOOTINGS
 - CONVEYOR AT THE QUAY
- LEGEND - EXISTING SERVICES**
- EASEMENT ZONES
 - GAS - EP CATS
 - GAS - GOF SUEZ
 - GAS - RWE
 - FIBRE OPTIC CABLE
 - MSC - DRAINS, CABLES, DUCTS
 - FOUL WATER - SEMBOCORP
 - WATER - NWL
 - GAS - ABANDONED
 - ABOVEGROUND PIPELINE CORRIDOR
 - OVERHEAD POWER CABLES
 - CONVEYOR LATERAL LIMITS OF DEVIATION
 - ELECTRICAL CABLE

REV	DATE	DESCRIPTION	BY	CHK	APP
E	14/05/15	PLANNING ISSUE	LW	DGB	MH
D	11/05/15	MINOR REVISIONS	CH	DGB	MH
C	11/05/15	MINOR REVISIONS	LW	DGB	MH
B	07/05/15	ISSUED FOR APPROVAL	TF	DGB	MH
A	27/02/15	FIRST ISSUE	LW	DGB	RWP

YORK POTASH
A Strive Minerals Project


PROJECT

YORK POTASH

TITLE

THE YORK POTASH
HARBOUR FACILITIES ORDER 201X
CONVEYOR ROUTE PLANS
NORTHERN ROUTE - SHEET 4
REGULATION 5(2)(o) DOCUMENT 3.3L


HASKONINGDHV UK LTD MARITIME & WATERWAYS Marlborough House Marlborough Crescent Newcastle upon Tyne NE1 4EE Tel: +44 (0) 191 211 1200 Fax: +44 (0) 191 211 1313 Email: info@haskoningdhv.com www.haskoningdhv.com					
DRAWN	LW	CHECKED	DGB	PASSED	RWP
DATE	FEB'15	CLIENTS REF.			
SCALE AT A1	1:1000	AUTOCAD REF.	PB1586-SK494		
DRAWING NO. PB1586-SK494					REVISION E

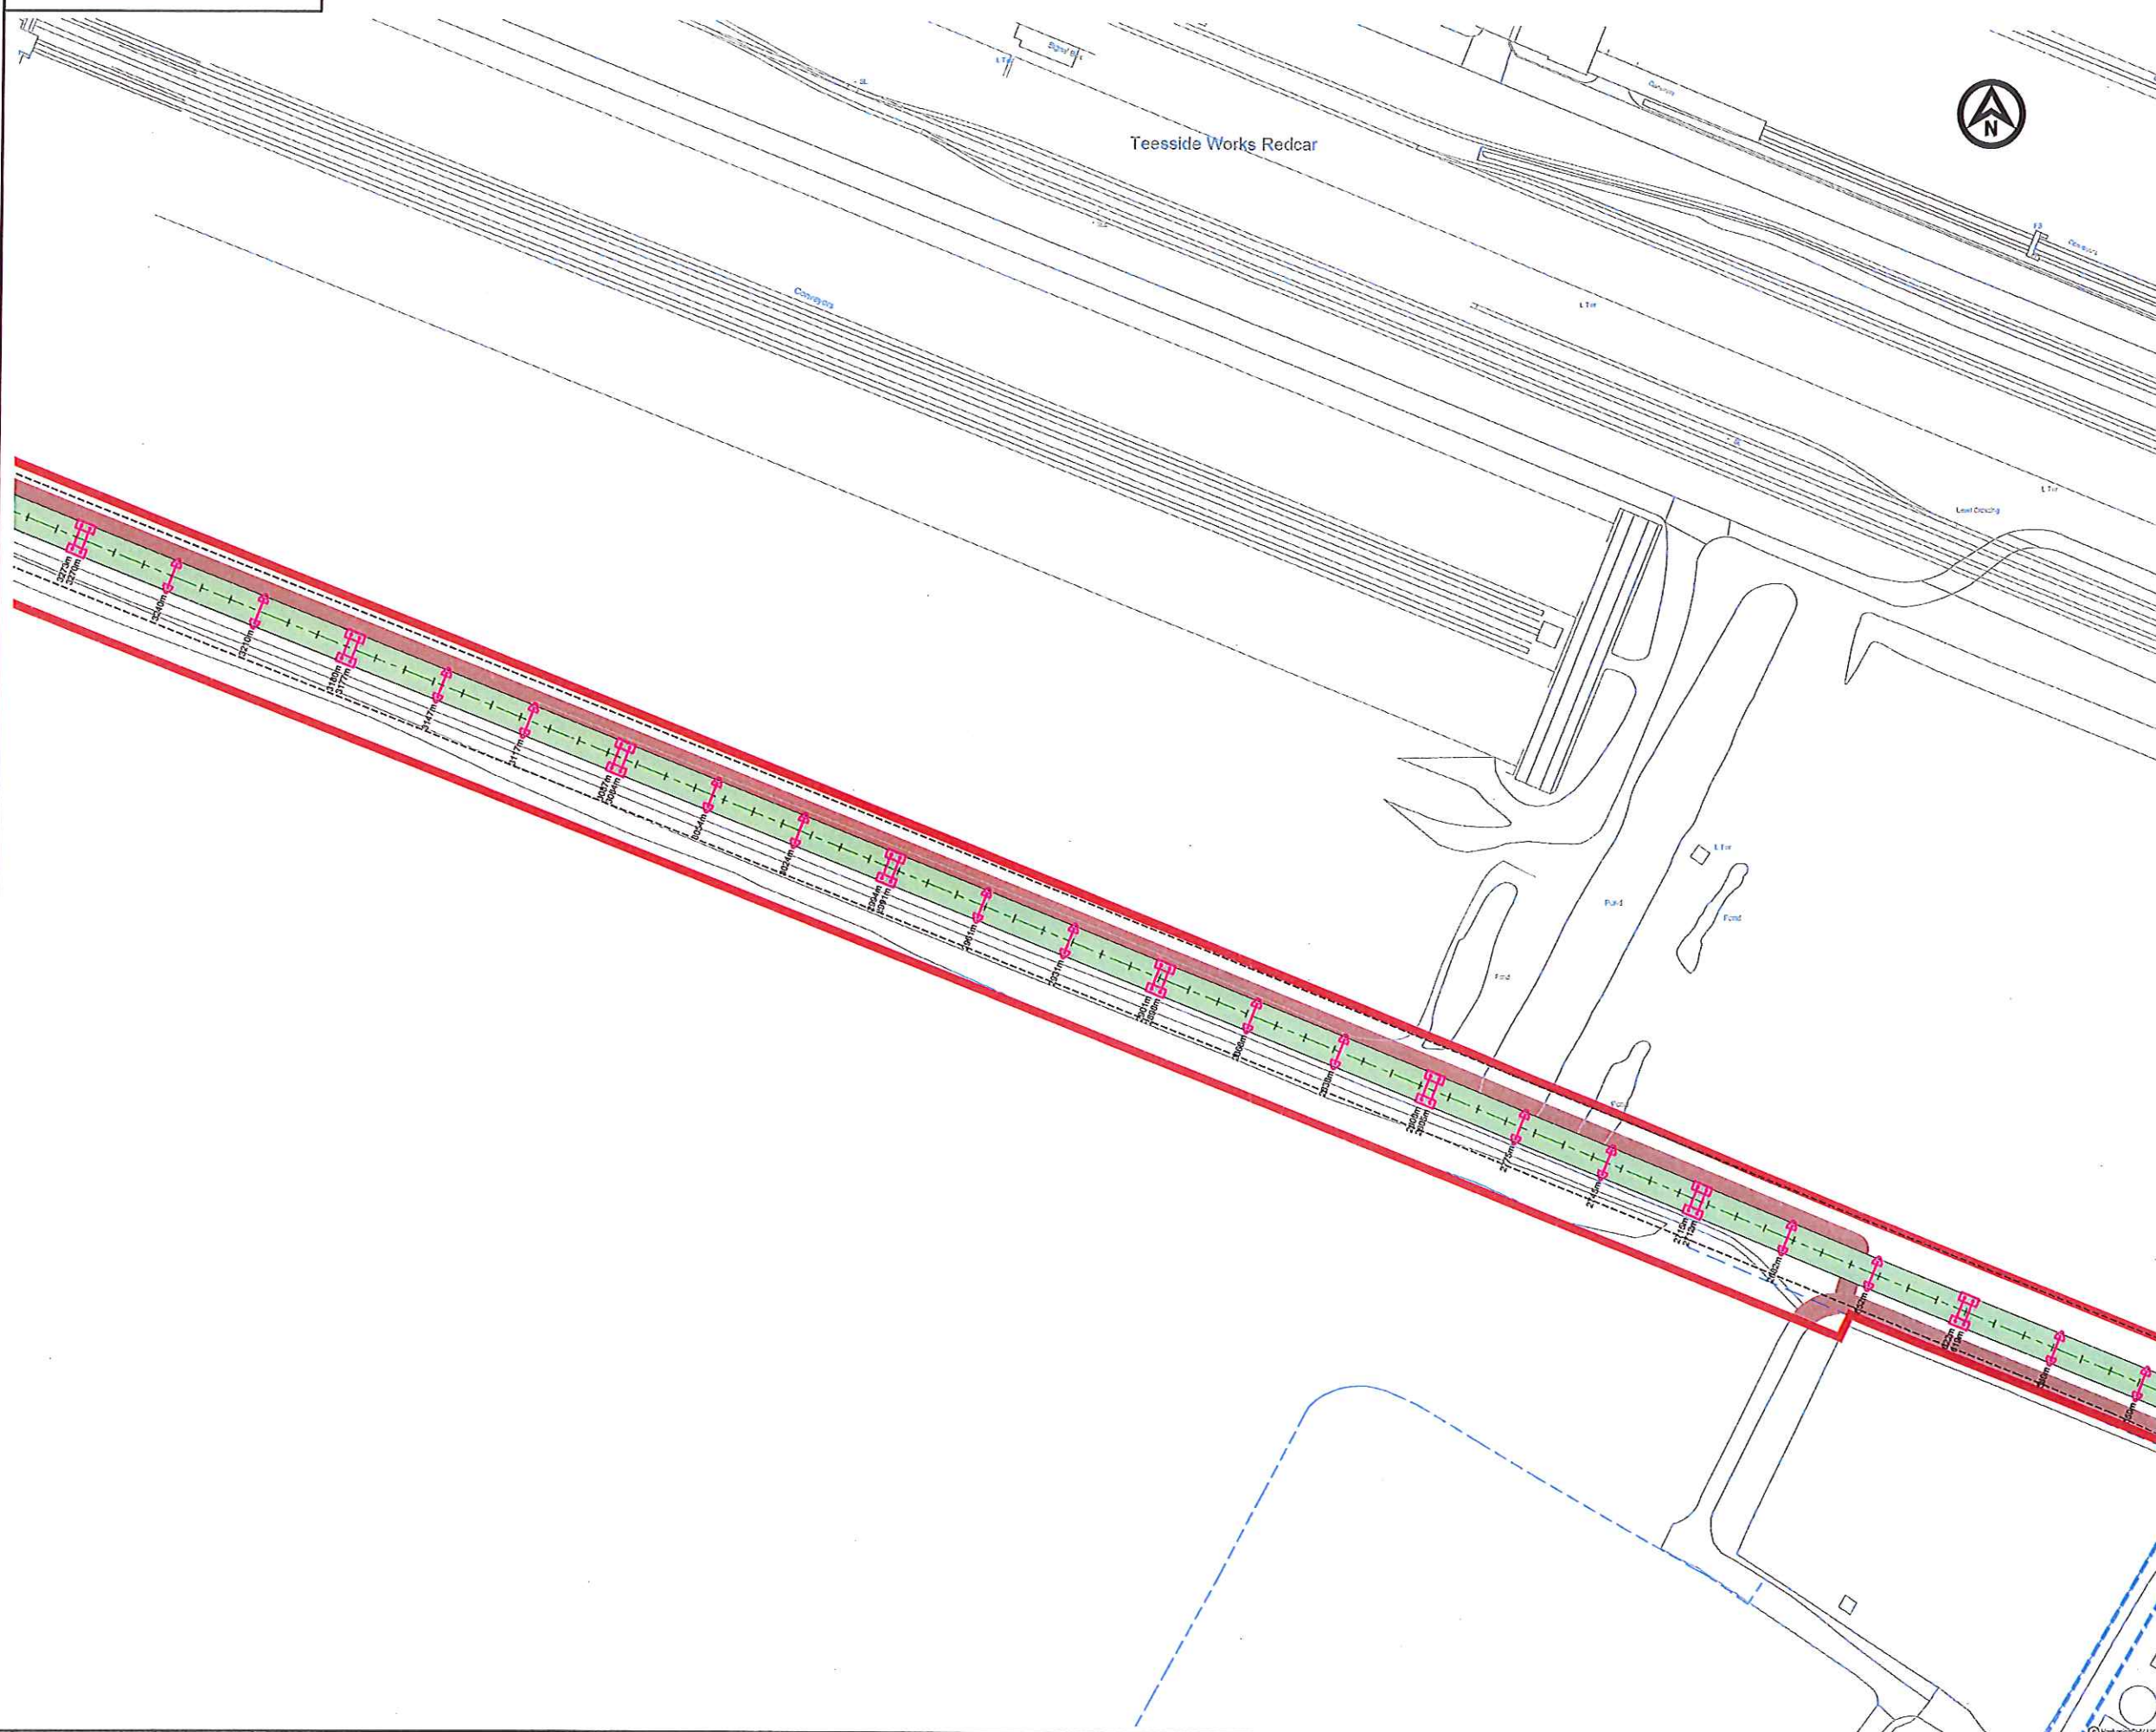

NOTES

MAJOR CROSSINGS

- | | |
|---------------------------------|----------------------------|
| MC 0: Eastern Boundary Road | - Pass over in bridge |
| MC 1: Highway A1085 | - Pass over in bridge |
| MC 2: YPL 1st access road | - Pass over in bridge |
| MC 3: Hot metal rail | - Pass over in bridge |
| MC 4: NWL 2nd access road | - Pass over in bridge |
| MC 5: National power grid lines | - Pass under 10m clearance |
| MC 6: SSI road bridge | - Pass over in bridge |
| MC 7: National rail way | - Pass over in bridge |
| MC 8: Access NWL W.T.P. | - Pass over in bridge |
| MC 9: Outfall | - Pass over in bridge |

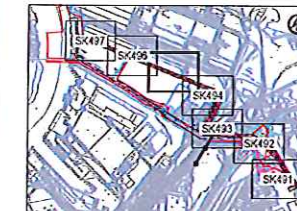

KEY PLAN
SCALE 1:50,000

LEGEND - CONVEYOR

- TYPE 3 - OPEN CONVEYOR - 2 LEGS
- TYPE 4 - OVAL ENCLOSED CONVEYOR - 2 LEGS
- TRANSFER TOWER
- ACCESS ROUTES
- CONVEYOR FOOTINGS
- CONVEYOR AT THE QUAY

LEGEND - EXISTING SERVICES

- EASEMENT ZONES
- GAS - BP CATS
- GAS - GDF SUEZ
- GAS - RWE
- FIBRE OPTIC CABLE
- MISC - DRAINS, CABLES, DUCTS
- FOUL WATER - SEMBORP
- WATER - NWL
- GAS - ABANDONED
- ABOVEGROUND PIPELINE CORRIDOR
- OVERHEAD POWER CABLES
- CONVEYOR LATERAL LIMITS OF DEVIATION

REV	DATE	DESCRIPTION	BY	CHK	APP
E	14.03.15	PLANNING ISSUE	LW	DGB	MH
D	10.03.15	MINOR REVISIONS	CH	DGB	MH
C	10.03.15	MINOR REVISIONS	LW	DGB	MH
B	09.03.15	ISSUED FOR APPROVAL	TF	DGB	MH
A	24.02.15	FIRST ISSUE	LW	DGB	RWP

REVISIONS




PROJECT

YORK POTASH

TITLE
THE YORK POTASH
HARBOUR FACILITIES ORDER 201X
CONVEYOR ROUTE PLANS
NORTHERN ROUTE - SHEET 5
REGULATION 5(2)(a) DOCUMENT 3.3M



DRAWN	LW	CHECKED	DGB	PASSED	RWP
DATE	FEB'15	CLIENTS REF.			
SCALE AT A1	1:1000	AUTOCAD REF.	PB1586-SK495		
DRAWING NO.	PB1586-SK495	REVISION	E		

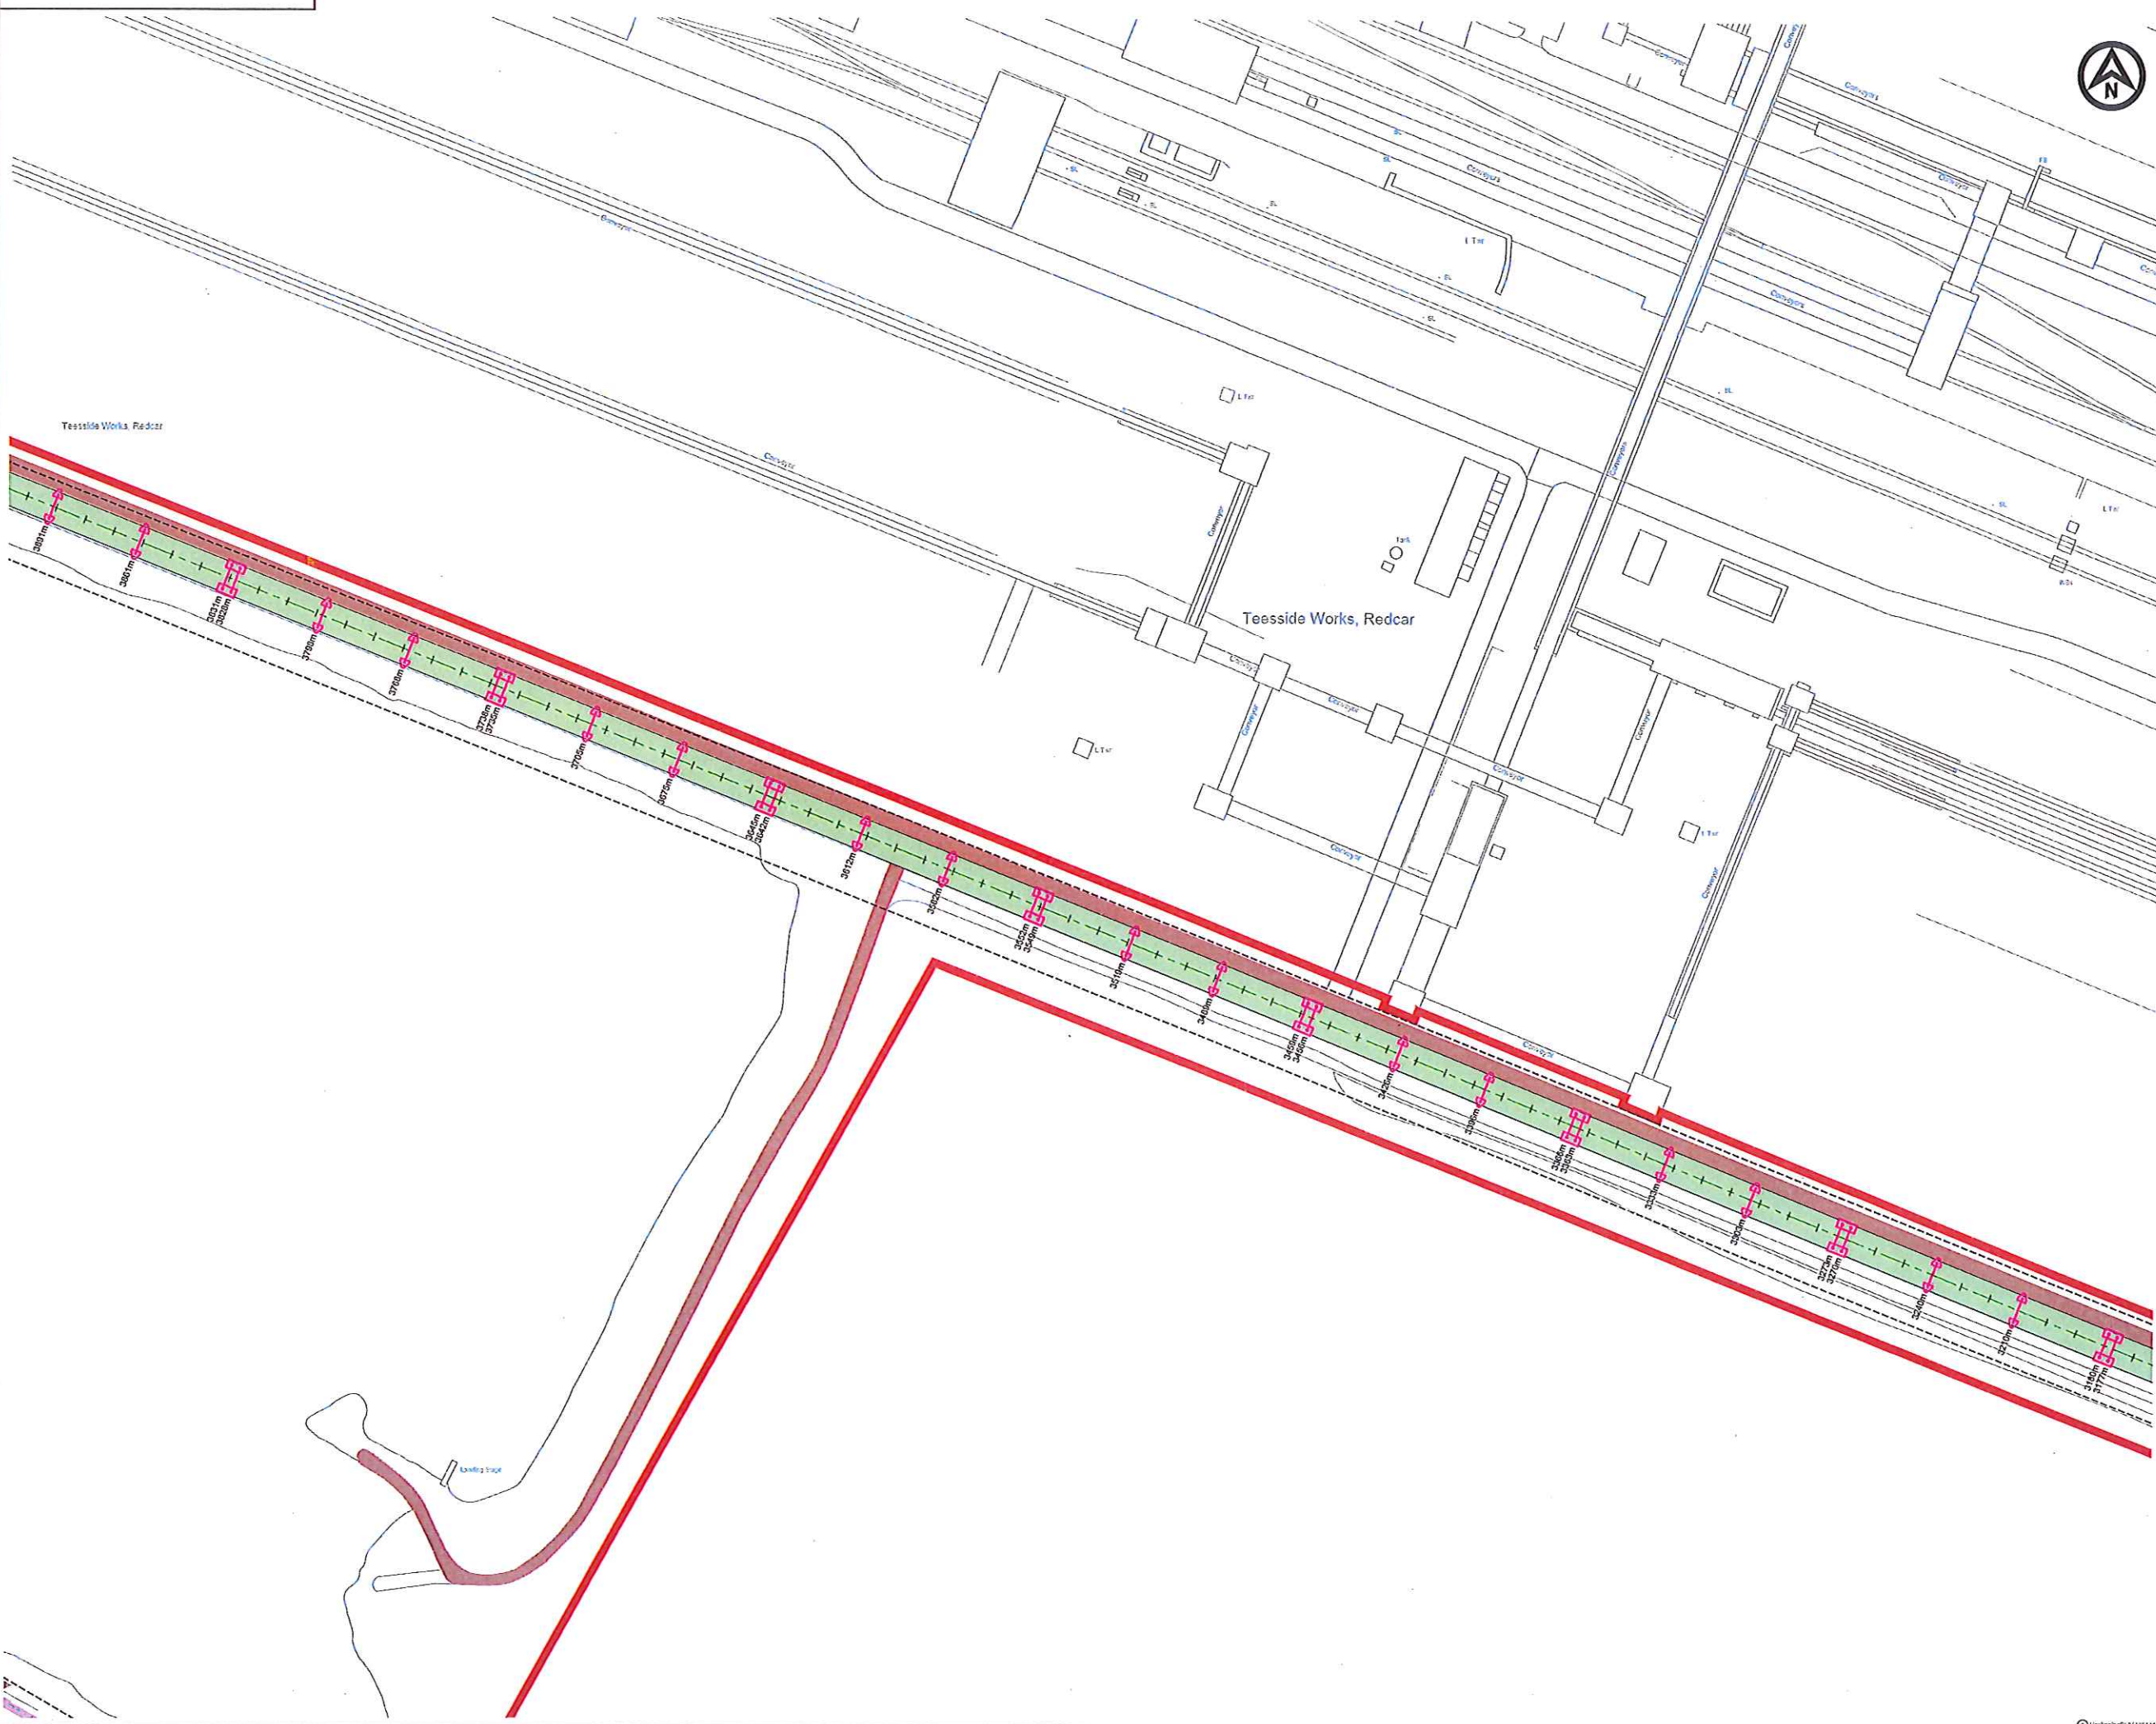


NOTES

MAJOR CROSSINGS

MC 0: Extern Boundary Road
MC 1: Highway A165
MC 2: YFL 1st access road
MC 3: Hot metal rail
MC 4: NWL 2nd access road
MC 5: National power grid lines
MC 6: SSI road bridge
MC 7: National rail way
MC 8: Access NWL W.T.P.
MC 9: Outfall


- Pass over in bridge
- Pass over in bridge
- Pass over in bridge
- Pass over in bridge
- Pass under 10 m clearance
- Pass over in bridge
- Pass over in bridge

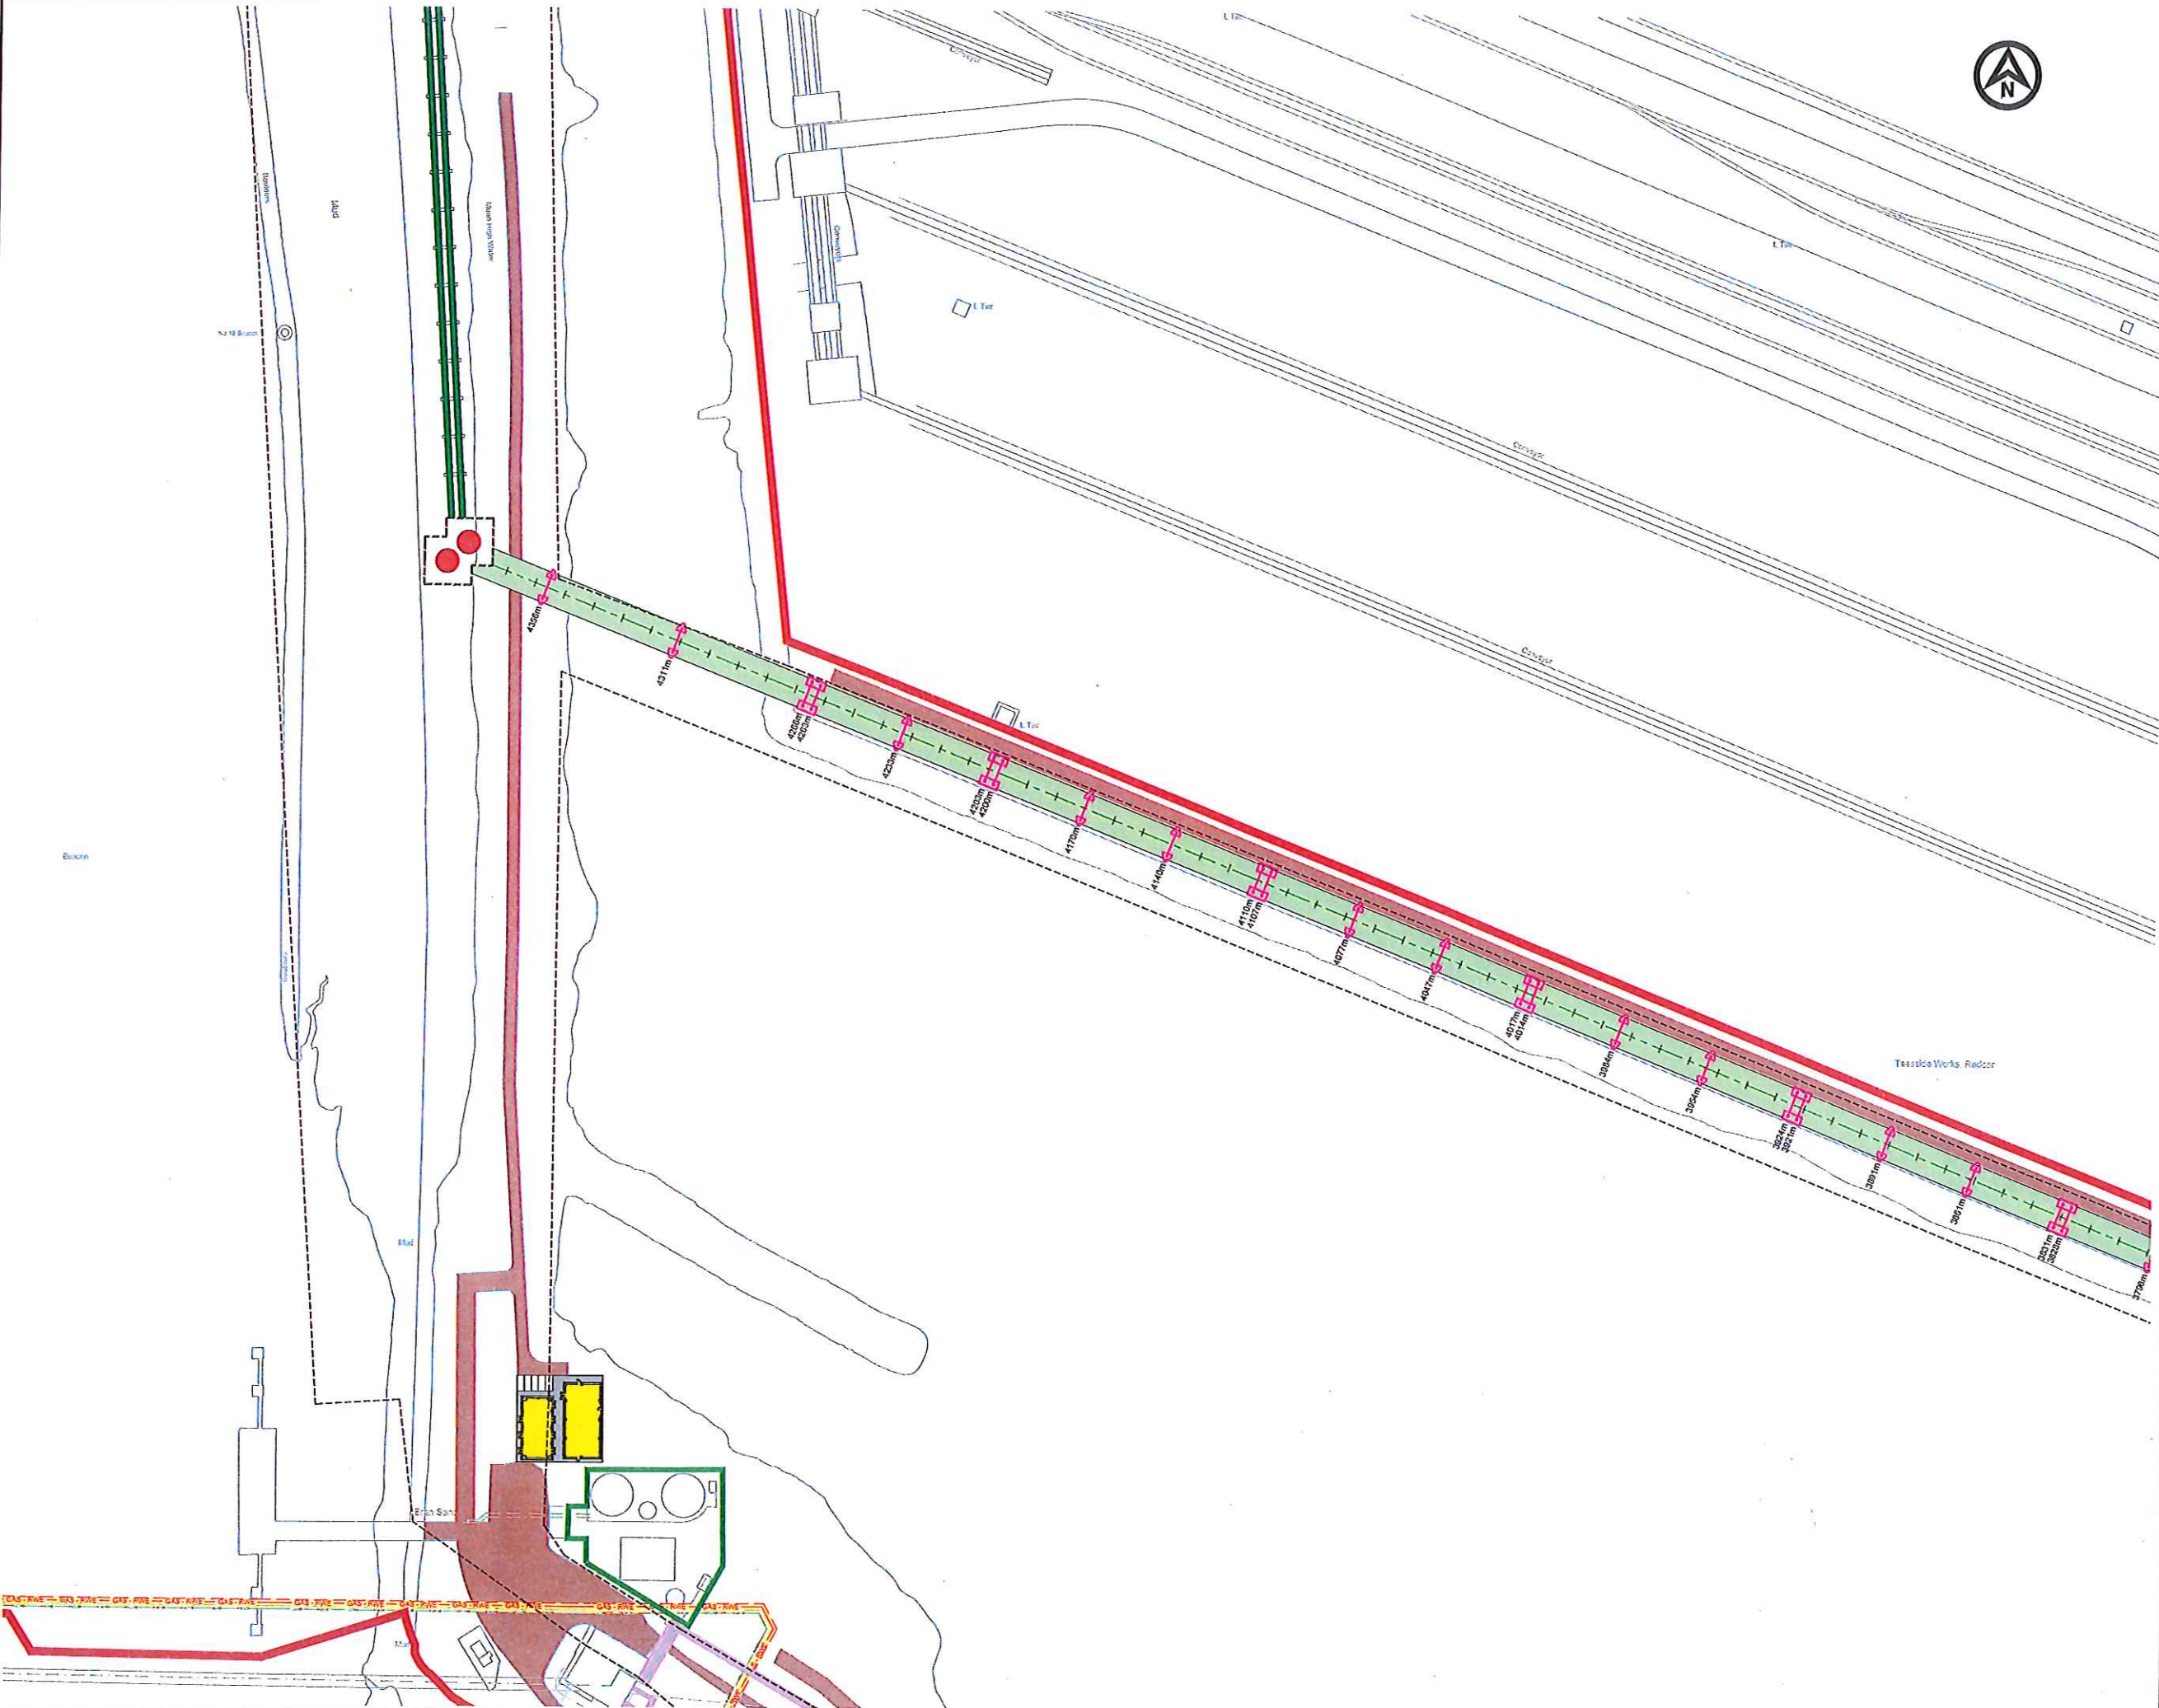

NOTES

MAJOR CROSSINGS

- | | |
|---------------------------------|-----------------------------|
| MC 0: Eastern Boundary Road | - Pass over in bridge |
| MC 1: Highway A1665 | - Pass over in bridge |
| MC 2: YPL 1st access road | - Pass over in bridge |
| MC 3: Hot metal rail | - Pass over in bridge |
| MC 4: NWL 2nd access road | - Pass over in bridge |
| MC 5: National power grid lines | - Pass under 10 m clearance |
| MC 6: SSI road bridge | - Pass over in bridge |
| MC 7: National rail way | - Pass over in bridge |
| MC 8: Access NWL W.T.P. | - Pass over in bridge |
| MC 9: Outfall | - Pass over in bridge |

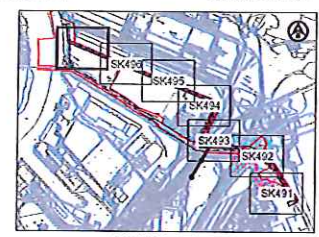

KEY PLAN
SCALE 1:50000

LEGEND - CONVEYOR

- TYPE 3 - OPEN CONVEYOR - 2 LEGS
- TYPE 4 - OVAL ENCLOSED CONVEYOR - 2 LEGS
- TRANSFER TOWER
- ACCESS ROUTES
- CONVEYOR FOOTINGS
- CONVEYOR AT THE QUAY

LEGEND - EXISTING SERVICES

- EASEMENT ZONES
- GAS - BP CATS
- GAS - GDF SUEZ
- GAS - RWE
- FIBRE OPTIC CABLE
- MISC - DRAINS, CABLES, DUCTS
- FOUL WATER - SEMSCORP
- WATER - NWL
- GAS - ABANDONED
- AS-OVERGROUND PIPELINE CORRIDOR
- OVER-HEAD POWER CABLES
- CONVEYOR LATERAL LIMITS OF DEVIATION

E	11.11.15	PLANNING ISSUE	LW	DGB	MH
D	11.11.15	MINOR REVISIONS	CH	DGB	MH
C	11.11.15	MINOR REVISIONS	LW	DGB	MH
B	01.11.15	ISSUED FOR APPROVAL	TF	DGB	MH
A	21.10.15	FIRST ISSUE	LW	DGB	RVP
REV	DATE	DESCRIPTION	BY	CHK	APP

REVISIONS




PROJECT
YORK POTASH

TITLE
**THE YORK POTASH
HARBOUR FACILITIES ORDER 201X
CONVEYOR ROUTE PLANS
NORTHERN ROUTE - SHEET 7
REGULATION 5(2)(a) DOCUMENT 3.30**

Royal HaskoningDHV
Enhancing Society Together

HASKONINGDHV UK LTD
MARITIME & WATERWAYS
Marborough House
Marborough Crescent
Newcastle upon Tyne NE1 4EE
+44 (0) 191 211 1300 Telephone
+44 (0) 191 211 1313 Fax
info@newcastle.mylhaskoning.com E-mail
www.mylhaskoning.com Website

DRAWN	LW	CHECKED	DGB	PASSED	RVP
DATE	FEB'15	CUSTOMER REF.			
SCALE	AT 1:1000	AUTOCAD REF.	PB1586-SK497		
DRAWING NO.	PB1586-SK497	REVISION	E		

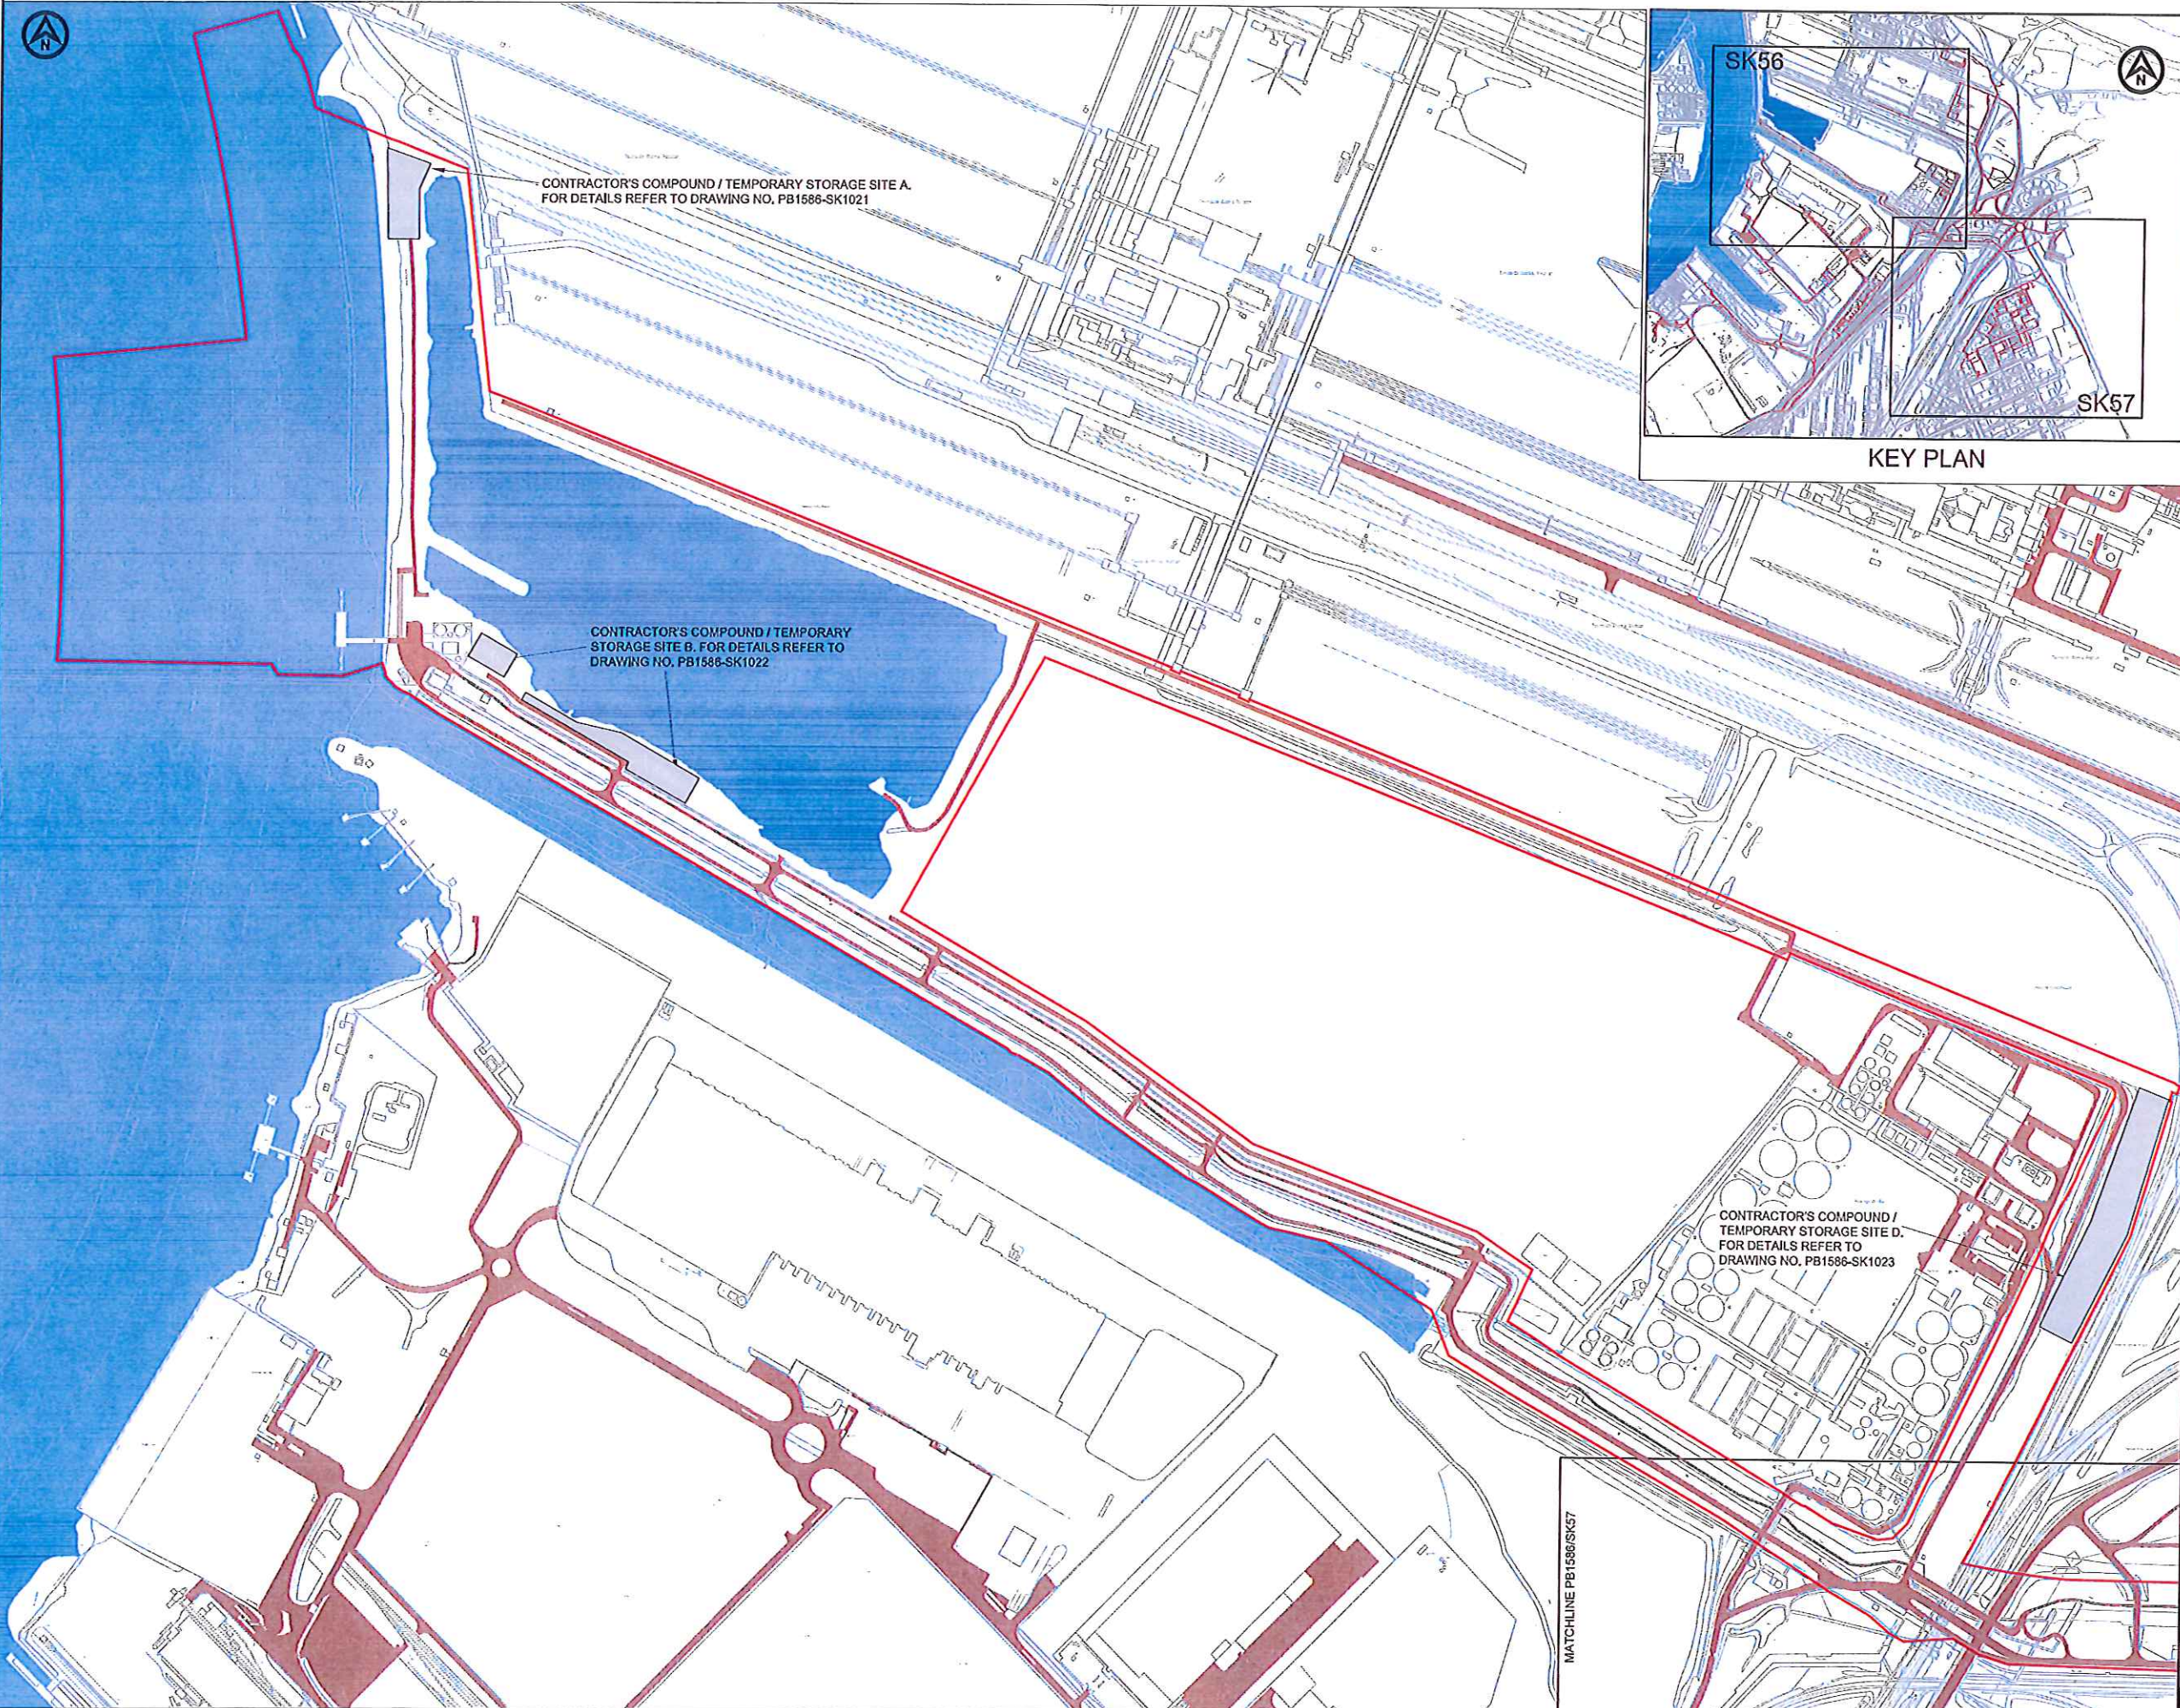

KEY PLAN

NOTES

LEGEND

- ORDER LIMITS
- INDICATIVE ACCESS ROUTES
- LOCATION OF TEMPORARY COMPOUNDS

13	18/01/14	PLANNING ISSUE	LW	DGB	RWP
9	11/02/14	PLANNING ISSUE	CH	RWP	RWP
8	12/02/14	PLANNING ISSUE	TF	RWB	RWB
7	11/02/14	PLANNING ISSUE	TF	RWB	RWB
6	11/02/14	PLANNING ISSUE	TF		
5	11/02/14	ORDER LIMITS UPDATED	TF	RWP	RWP
4	21/11/14	DRAFT FOR CONSULTATION	GIC	RWP	RWP
3	19/11/14	DRAFT FOR CONSULTATION	GIC	RWP	RWP
2	28/09/14	DRAFT FOR CONSULTATION	IT	TJR	TJR
1	27/08/14	PLANNING ISSUE	IT	TJR	TJR
0	20/07/14	PLANNING ISSUE	NAT	SRS	RP
REV	DATE	DESCRIPTION	BY	CHK	APP

REVISIONS

YORKPOTASH
A Sirius Minerals Project



PROJECT
YORK POTASH

TITLE
THE YORK POTASH
HARBOUR FACILITIES ORDER 201X
LOCATION OF TEMPORARY
COMPOUNDS (SHEET 1 OF 2)
REGULATION 5 (2)(o)
DOCUMENT 3.4A

HASKONINGDHV UK LTD
MARITIME & WATERWAYS
Marborough House
Marborough Crescent
Newcastle upon Tyne NE1 4EE
+44 (0) 191 211 1330 Telephone
+44 (0) 191 211 1313 Fax
info@haskoningdhv.com E-mail
www.haskoningdhv.com Website

DRAWN	NAT	CHECKED	SRS	PASSED	RP
DATE	JUNE '14	CLIENTS REF.			
SCALE	A3	1:2500	AUTOCAD REF.	PB1586-SK56_SK57.dwg	

DRAWING No.	PB1586/SK56	REVISION	10
-------------	-------------	----------	----

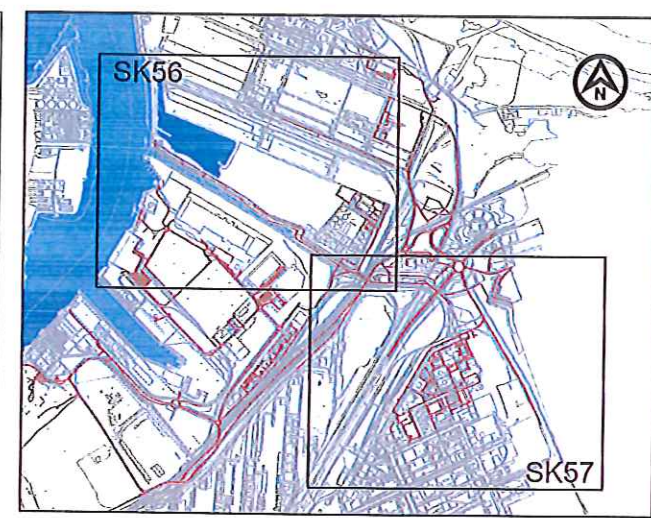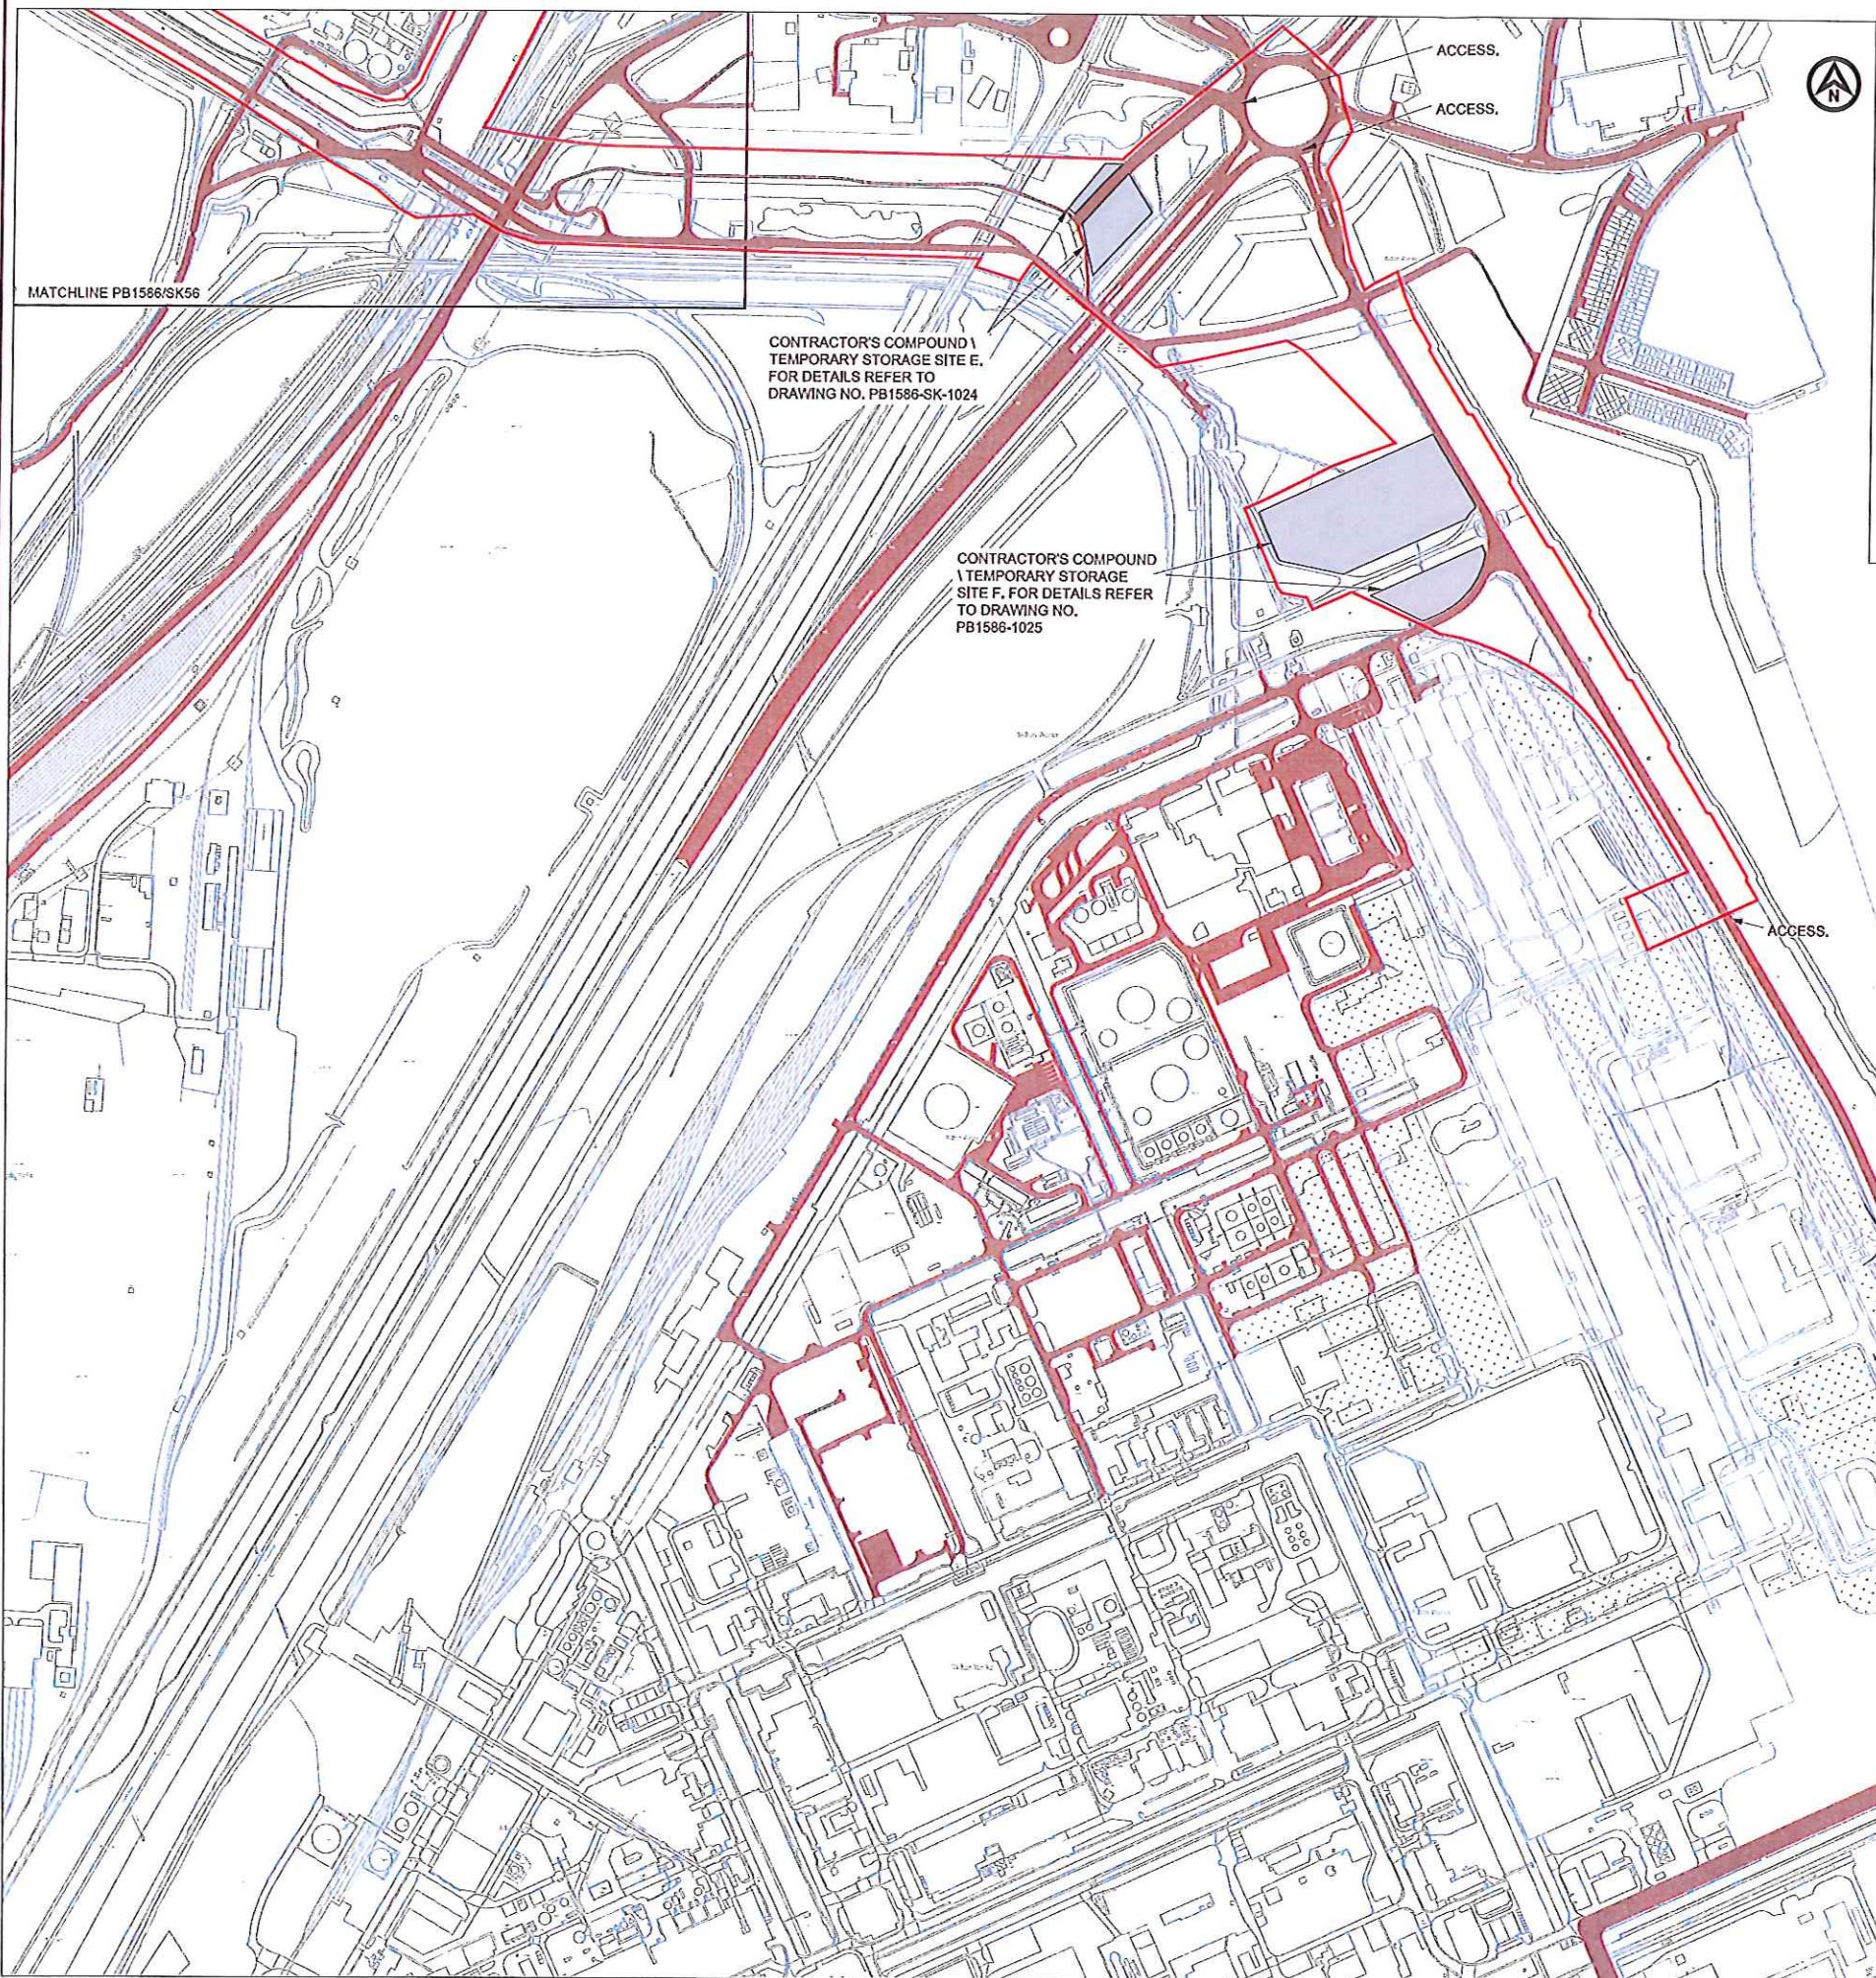

KEY PLAN

NOTES

LEGEND

- ORDER LIMITS
- INDICATIVE ACCESS ROUTES
- LOCATION OF TEMPORARY COMPOUNDS

10	18/01/14	PLANNING ISSUE	LW	DGB	RWP
9	11/03/13	PLANNING ISSUE	CH	RWP	RWP
8	17/02/14	PLANNING ISSUE	TF	RWP	RWP
7	18/01/14	PLANNING ISSUE	TF		
6	21/01/14	ORDER LIMITS UPDATED	TF	RWP	RWP
5	11/01/14	ORDER LIMITS UPDATED	TF	RWP	RWP
4	29/11/14	DRAFT FOR CONSULTATION	GIC	RWP	RWP
3	19/11/14	DRAFT FOR CONSULTATION	GIC	RWP	RWP
2	28/01/14	DRAFT FOR CONSULTATION	IT	TJR	TJR
1	2/08/14	PLANNING ISSUE	IT	TJR	TJR
0	28/01/14	PLANNING ISSUE	NAT	SRS	RP
REV	DATE	DESCRIPTION	BY	CHK	APP

REVISIONS




PROJECT
YORK POTASH

TITLE
THE YORK POTASH
HARBOUR FACILITIES ORDER 201X
LOCATION OF TEMPORARY
COMPOUNDS (SHEET 2 OF 2)
REGULATION 5 (2)(c)
DOCUMENT 3.4B



DRAWN	NAT	CHECKED	SRS	PASSED	RP
DATE	JUNE '14	CUSTOMER REF.			
SCALE AT A3	1:2500	AUTOCAD REF.	PB1586-SK56_SK57.dwg		

DRAWING No. PB1586/SK57

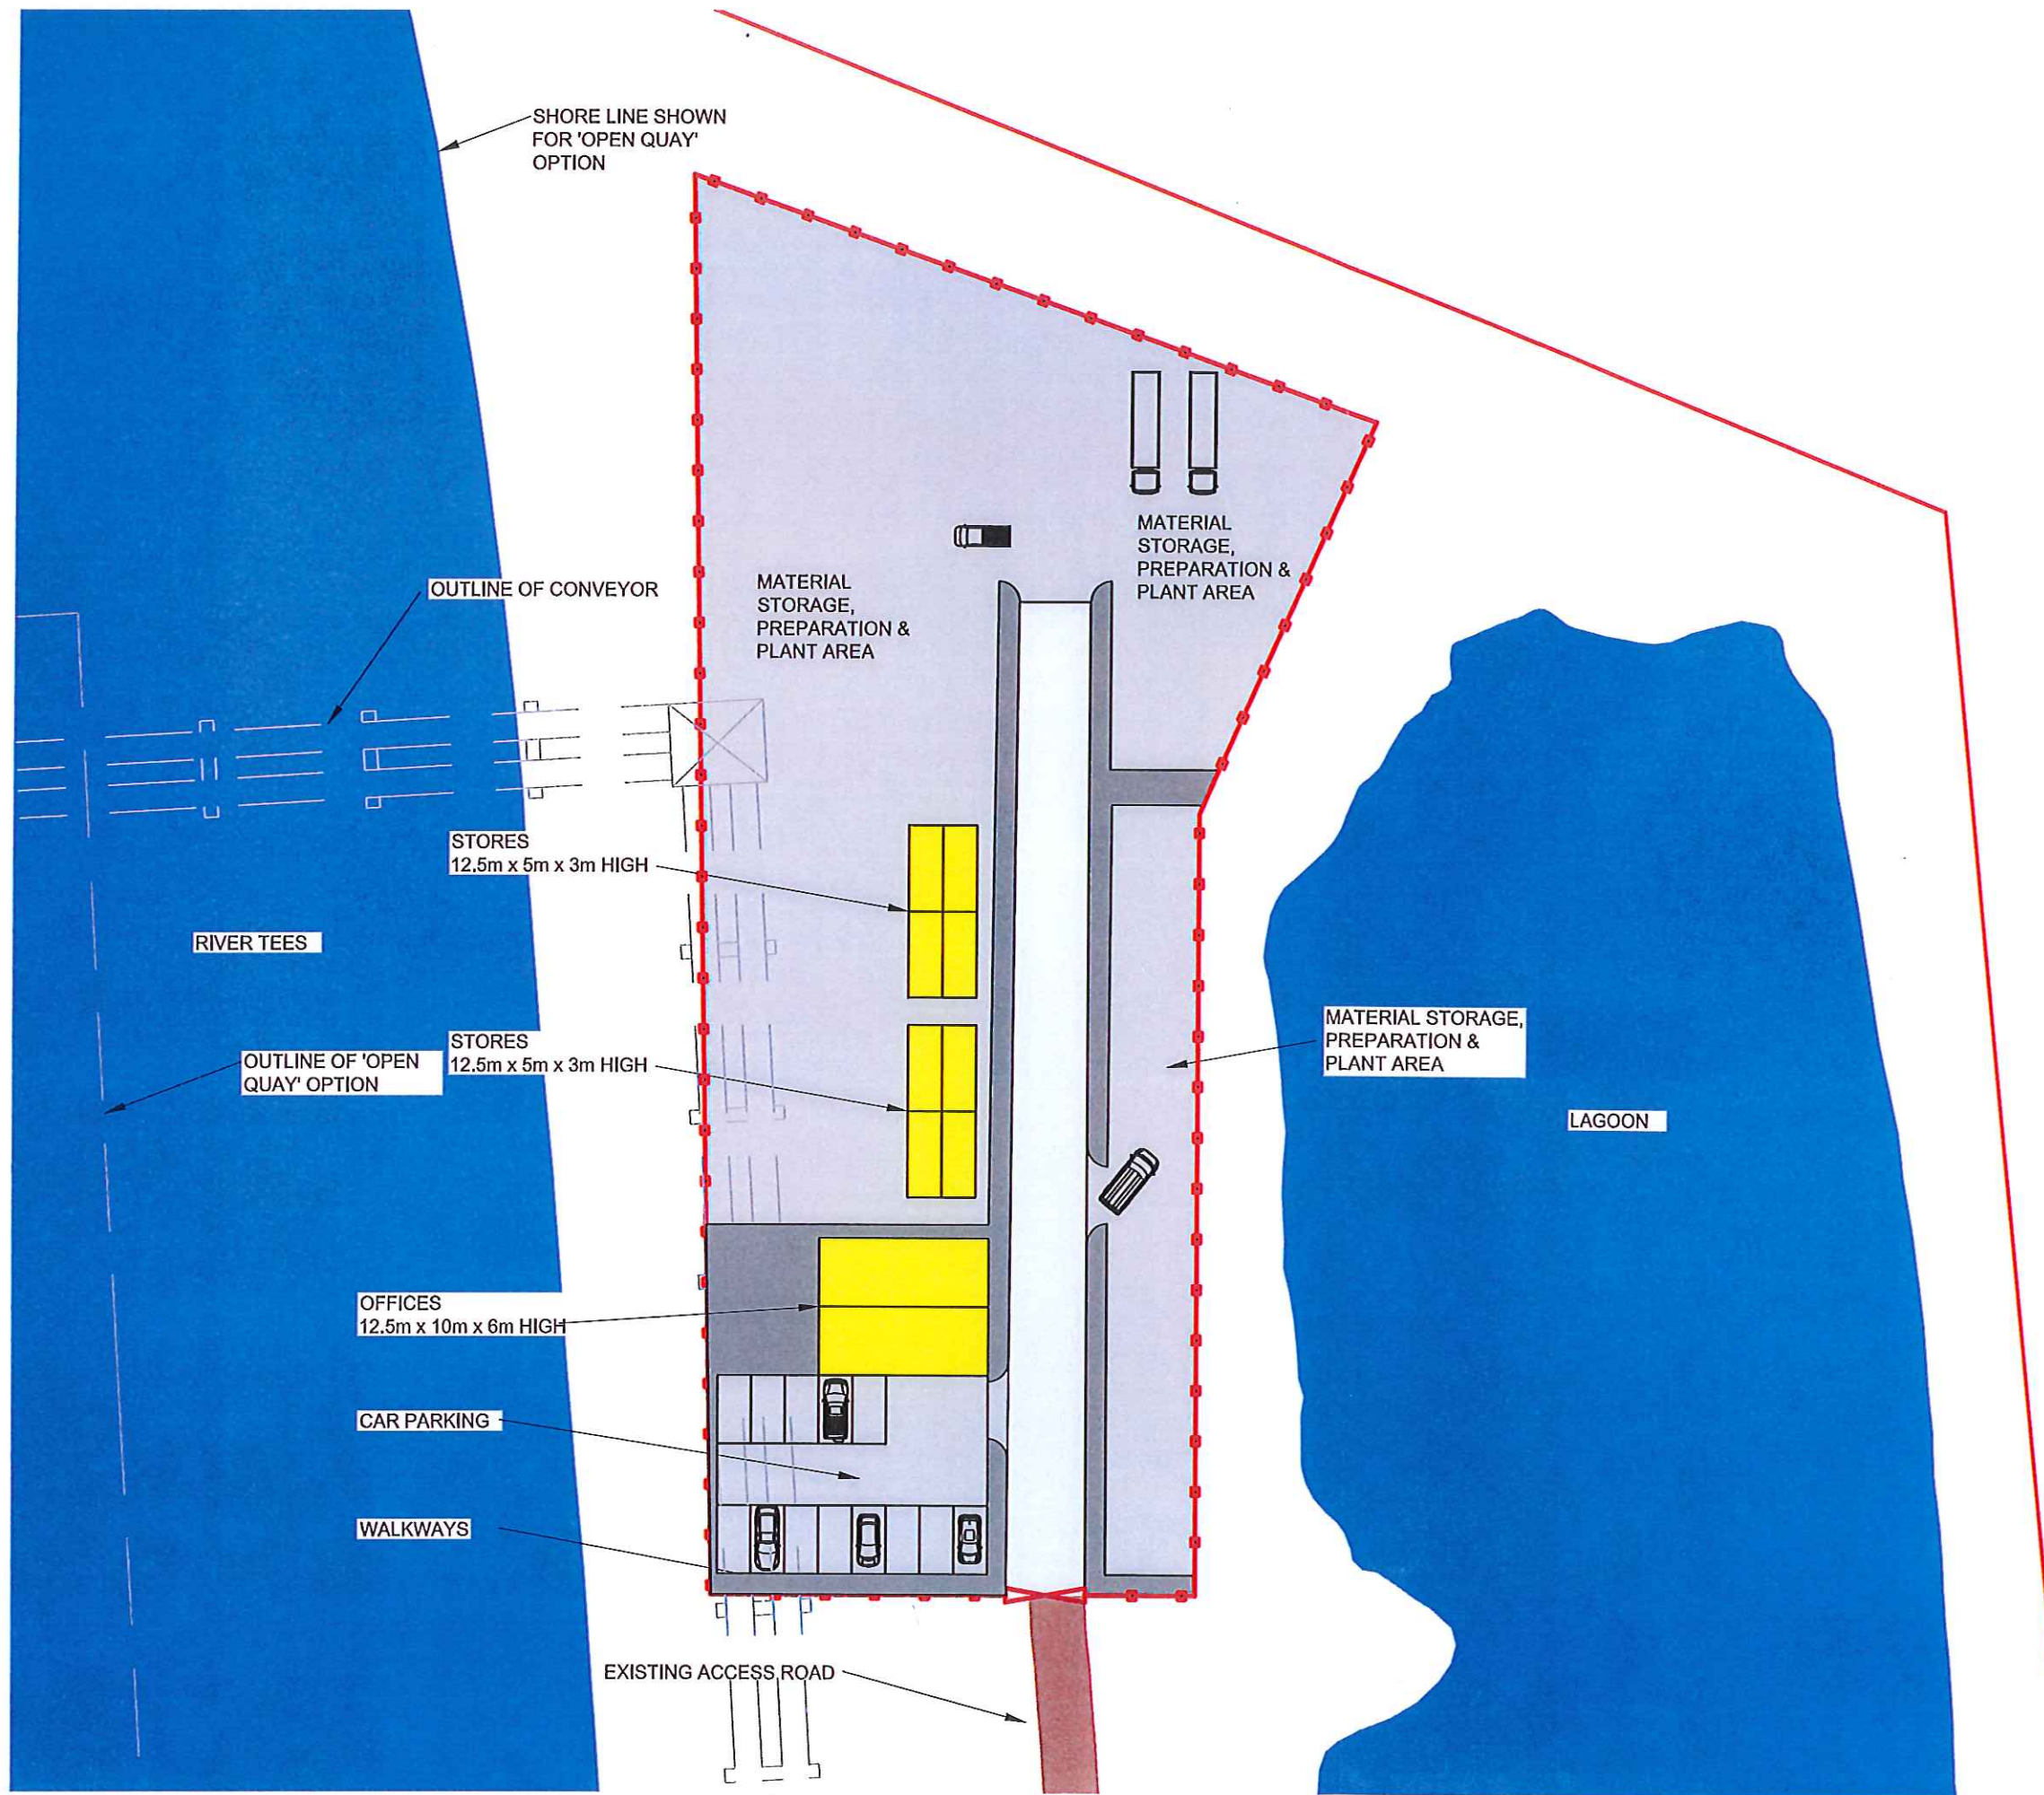

NOTES

LEGEND

-  ORDER LIMITS
-  PEDESTRIAN WALKWAY
-  ACCESS ROAD
-  HARDSTANDING
-  BUILDINGS-CONTAINER STORAGE
-  SECURITY GATE
-  SECURITY FENCE

NOTE: THIS PLAN SHOWS THE 'OPEN QUAY' OPTION

E	10-15	PLANNING ISSUE	LW	DGB	MH
D	10-15	PLANNING ISSUE	LW	DGB	MH
C	11-15	ISSUED FOR INFORMATION	CH	DGB	MH
B	10-15	ISSUED FOR INFORMATION	LW	DGB	MH
A	11-15	ISSUED FOR INFORMATION	LW	DGB	RAP
REV	DATE	DESCRIPTION	BY	CHK	APP

REVISIONS



PROJECT


YORK POTASH

TITLE

THE YORK POTASH
HARBOUR FACILITIES ORDER 201X
TEMPORARY COMPOUND SITE A
REGULATION 5 (2)(o)
DOCUMENT 3.4C



DRAWN	LW	CHECKED	DGB	PASSED	RVP
DATE	FEB15	CLIENT'S REF.			
SCALE AT A3	1:500	AUTOCAD REF.		PB1586-SK1021	
DRAWING No. PB1586-SK1021					REVISION E

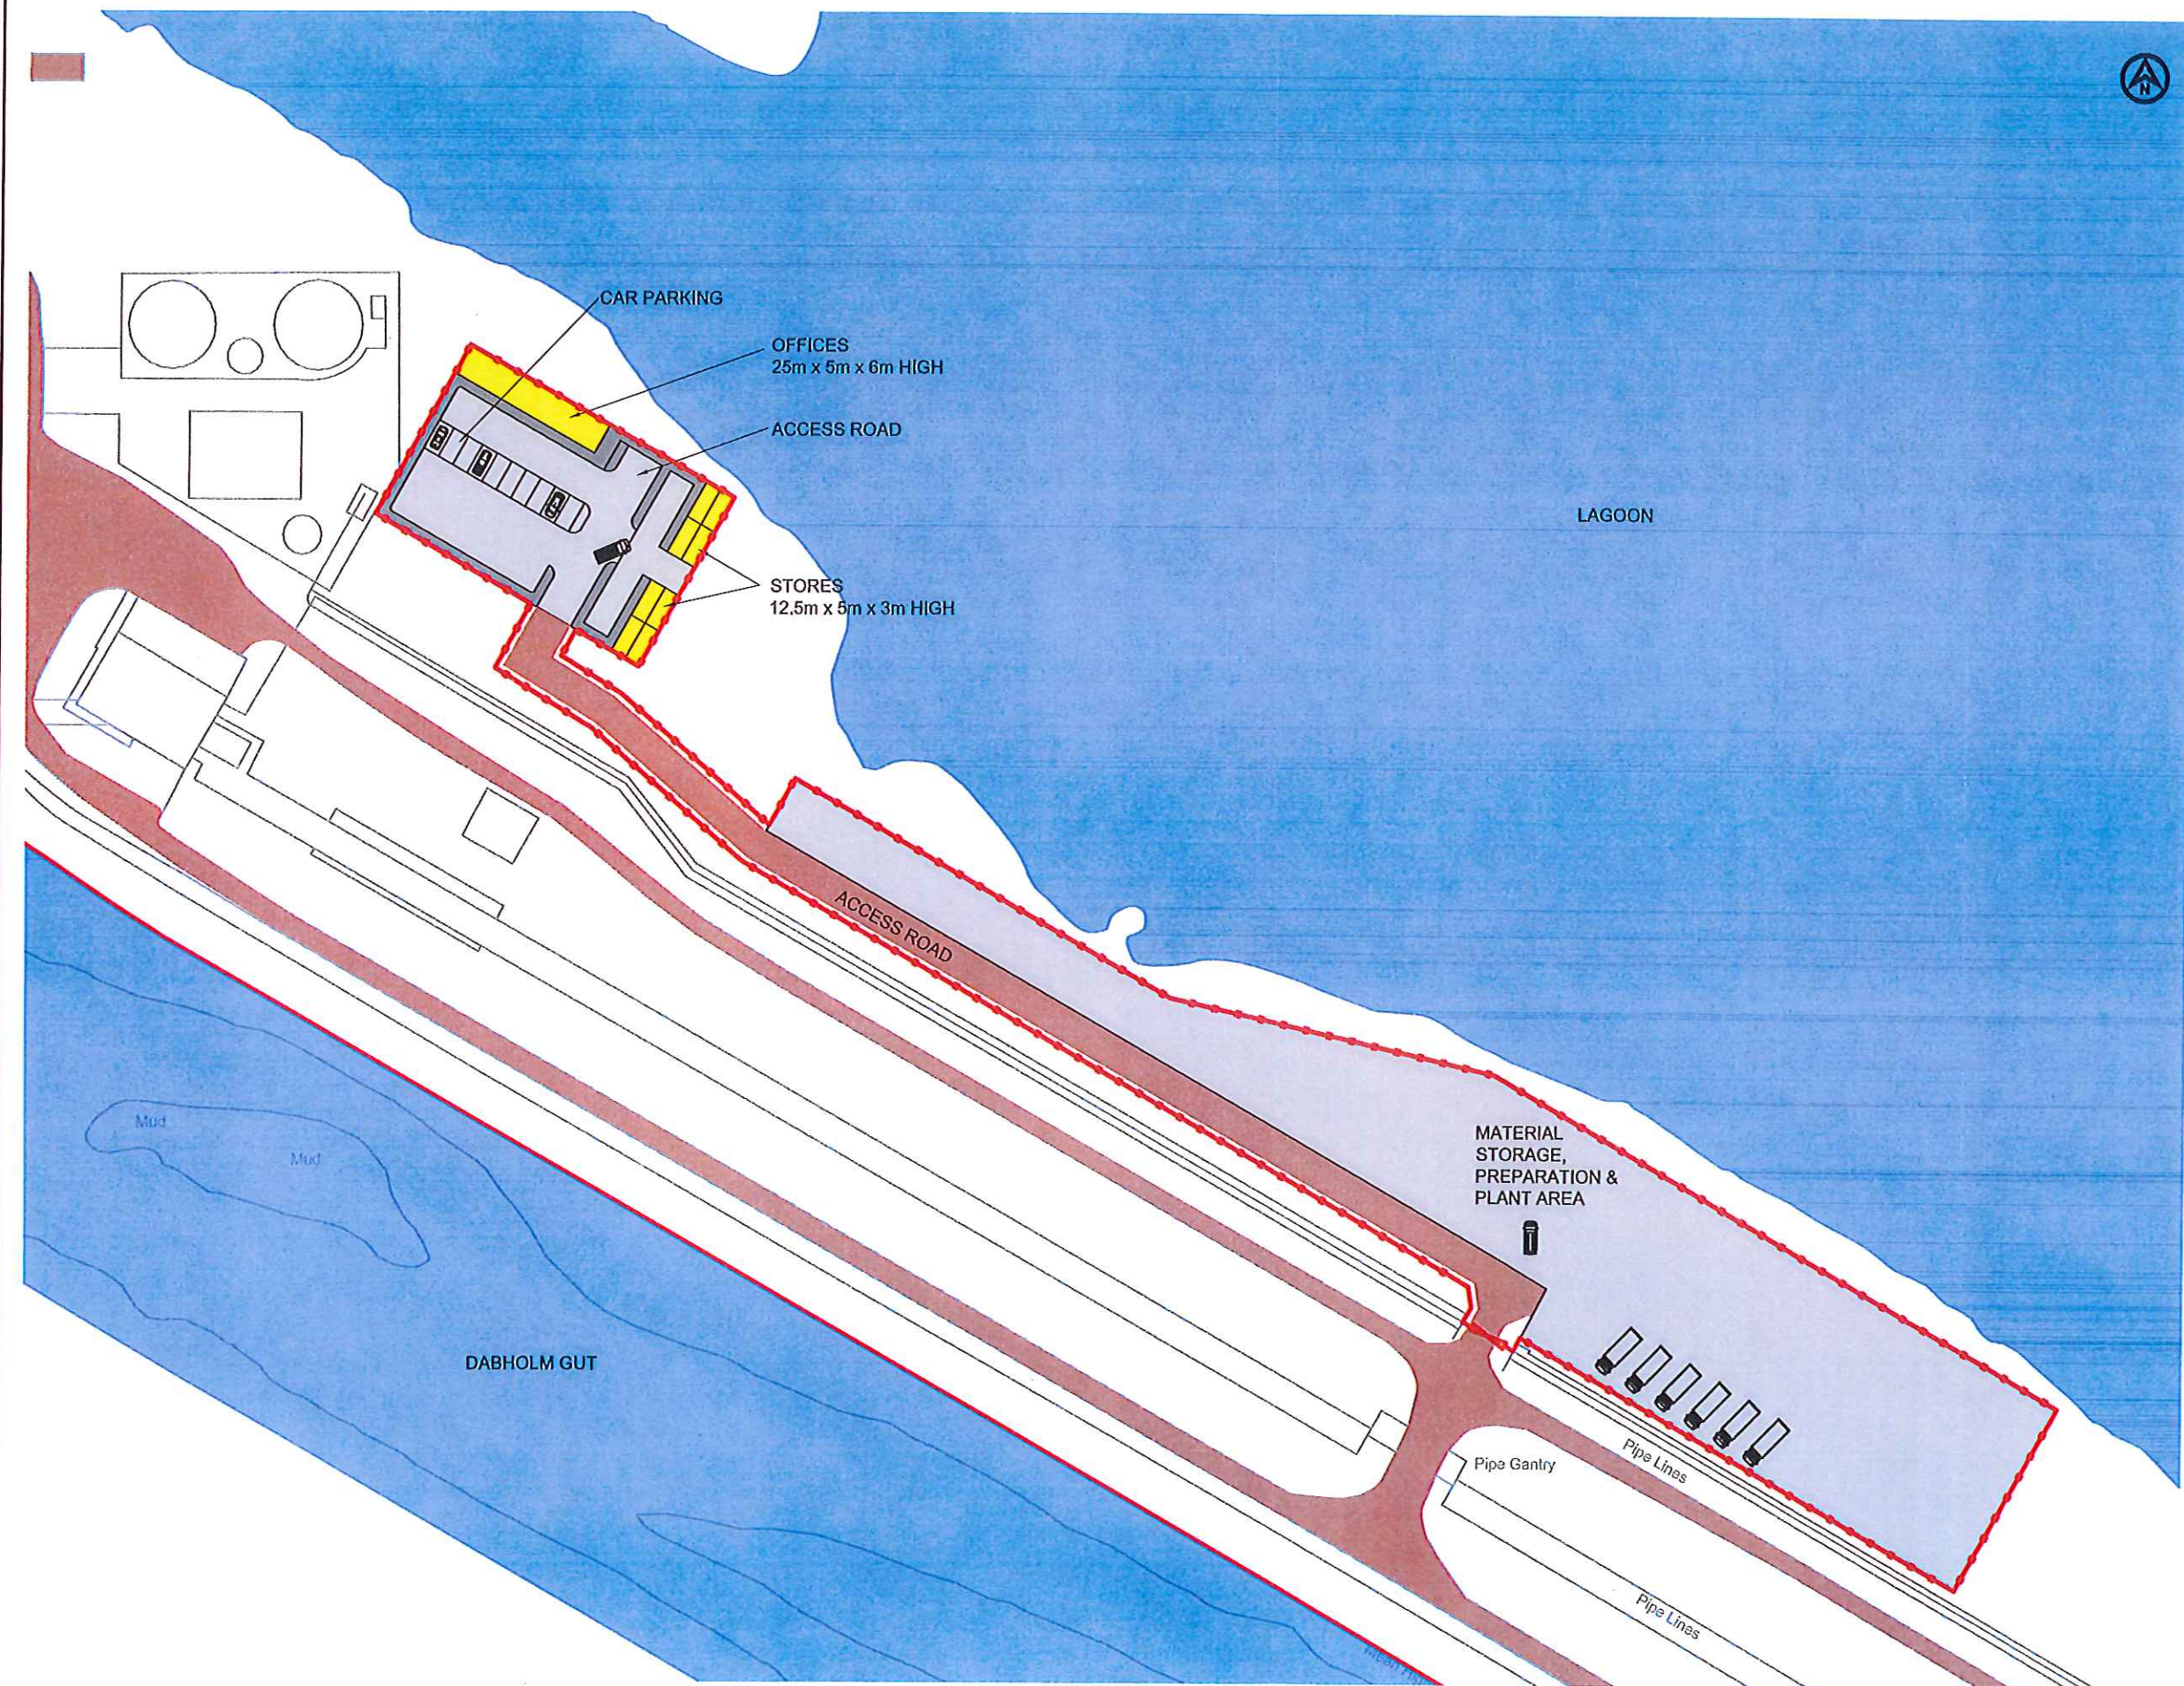

NOTES

LEGEND

- ORDER LIMITS
- PEDESTRIAN WALKWAY
- ACCESS ROAD
- BUILDINGS/CONTAINER STORAGE
- X SECURITY GATE
- SECURITY FENCE

REV	DATE	DESCRIPTION	BY	CHK	APP
E	10/01/15	PLANNING ISSUE	LW	DGB	MH
D	11/01/15	MAJOR REVISIONS	LW	DGB	MH
C	12/01/15	ISSUED FOR INFORMATION	LW	DGB	MH
B	13/01/15	ISSUED FOR INFORMATION	LW	DGB	MH
A	14/01/15	ISSUED FOR INFORMATION	LW	DGB	RWP

REVISIONS




PROJECT
YORK POTASH

TITLE
**THE YORK POTASH
HARBOUR FACILITIES ORDER 201X
TEMPORARY COMPOUND SITE B
REGULATION 5 (2)(a)
DOCUMENT 3.4D**

Royal HaskoningDHV
MARITIME & WATERWAYS
Bathurst House
Marine Parade
Newcastle upon Tyne NE1 4EE
Tel: 0191 251 1300
Fax: 0191 251 1301
Email: info@royalhaskoningdhv.com
www.royalhaskoningdhv.com

DRAWN	LW	CHECKED	DGB	PASSED	RWP
DATE	FEB 15	CLIENT'S REF.			
SCALE	AT A3 1:1000	AUTOCAD REF.	PB1586-SK1022		
DRAWING NO.	PB1586-SK1022	REVISION	E		

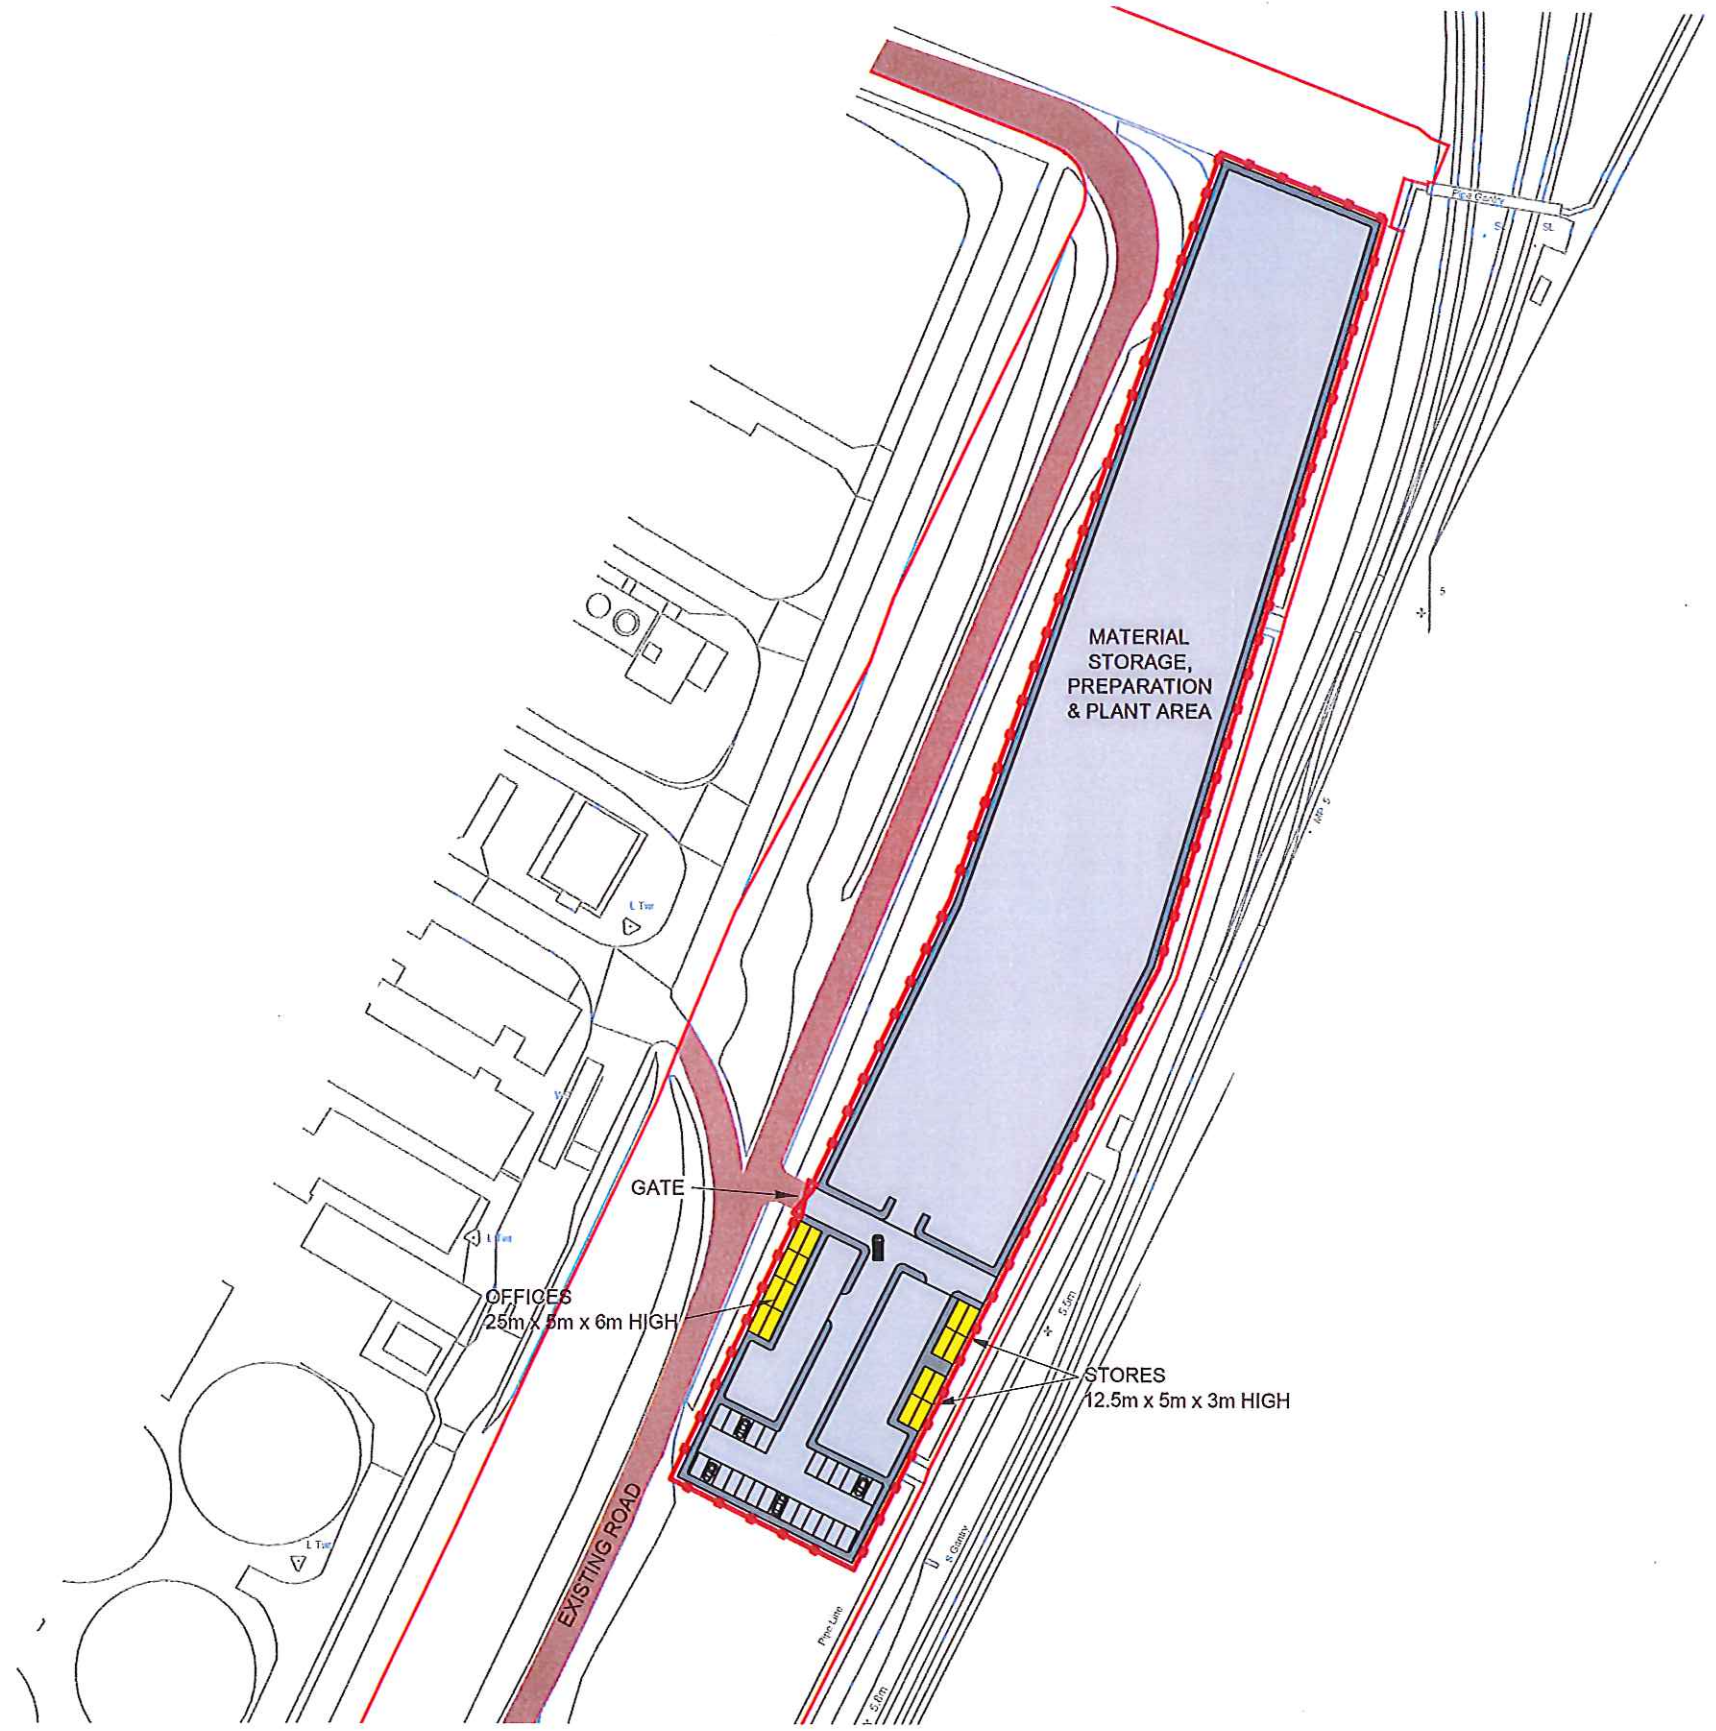

NOTES

LEGEND

- ORDER LIMITS
- PEDESTRIAN WALKWAY
- ACCESS ROAD
- HARDSTANDING
- BUILDINGS/CONTAINER STORAGE
- SECURITY GATE
- SECURITY FENCE

D	15-10-18	ISSUED FOR INFORMATION	LW	DGB	DGB
C	01-01-19	MINOR REVISIONS	LW	DGB	M&I
B	15-10-18	ISSUED FOR INFORMATION	LW	DGB	M&I
A	15-10-18	ISSUED FOR INFORMATION	LW	DGB	RWP
REV	DATE	DESCRIPTION	BY	CHK	APP

REVISIONS




PROJECT
YORK POTASH

TITLE
THE YORK POTASH
HARBOUR FACILITIES ORDER 201X
TEMPORARY COMPOUND SITE D
REGULATION 5 (2)(a)
DOCUMENT 3.4E



DRAWN	LW	CHECKED	DGB	PASSED	RWP
DATE	FEB15	CLIENT'S REF.			
SCALE	A3 1:1500	AUTOCAD REF.	PB1586-SK1023		
DRAWING NO.	PB1586-SK1023	REVISION			D

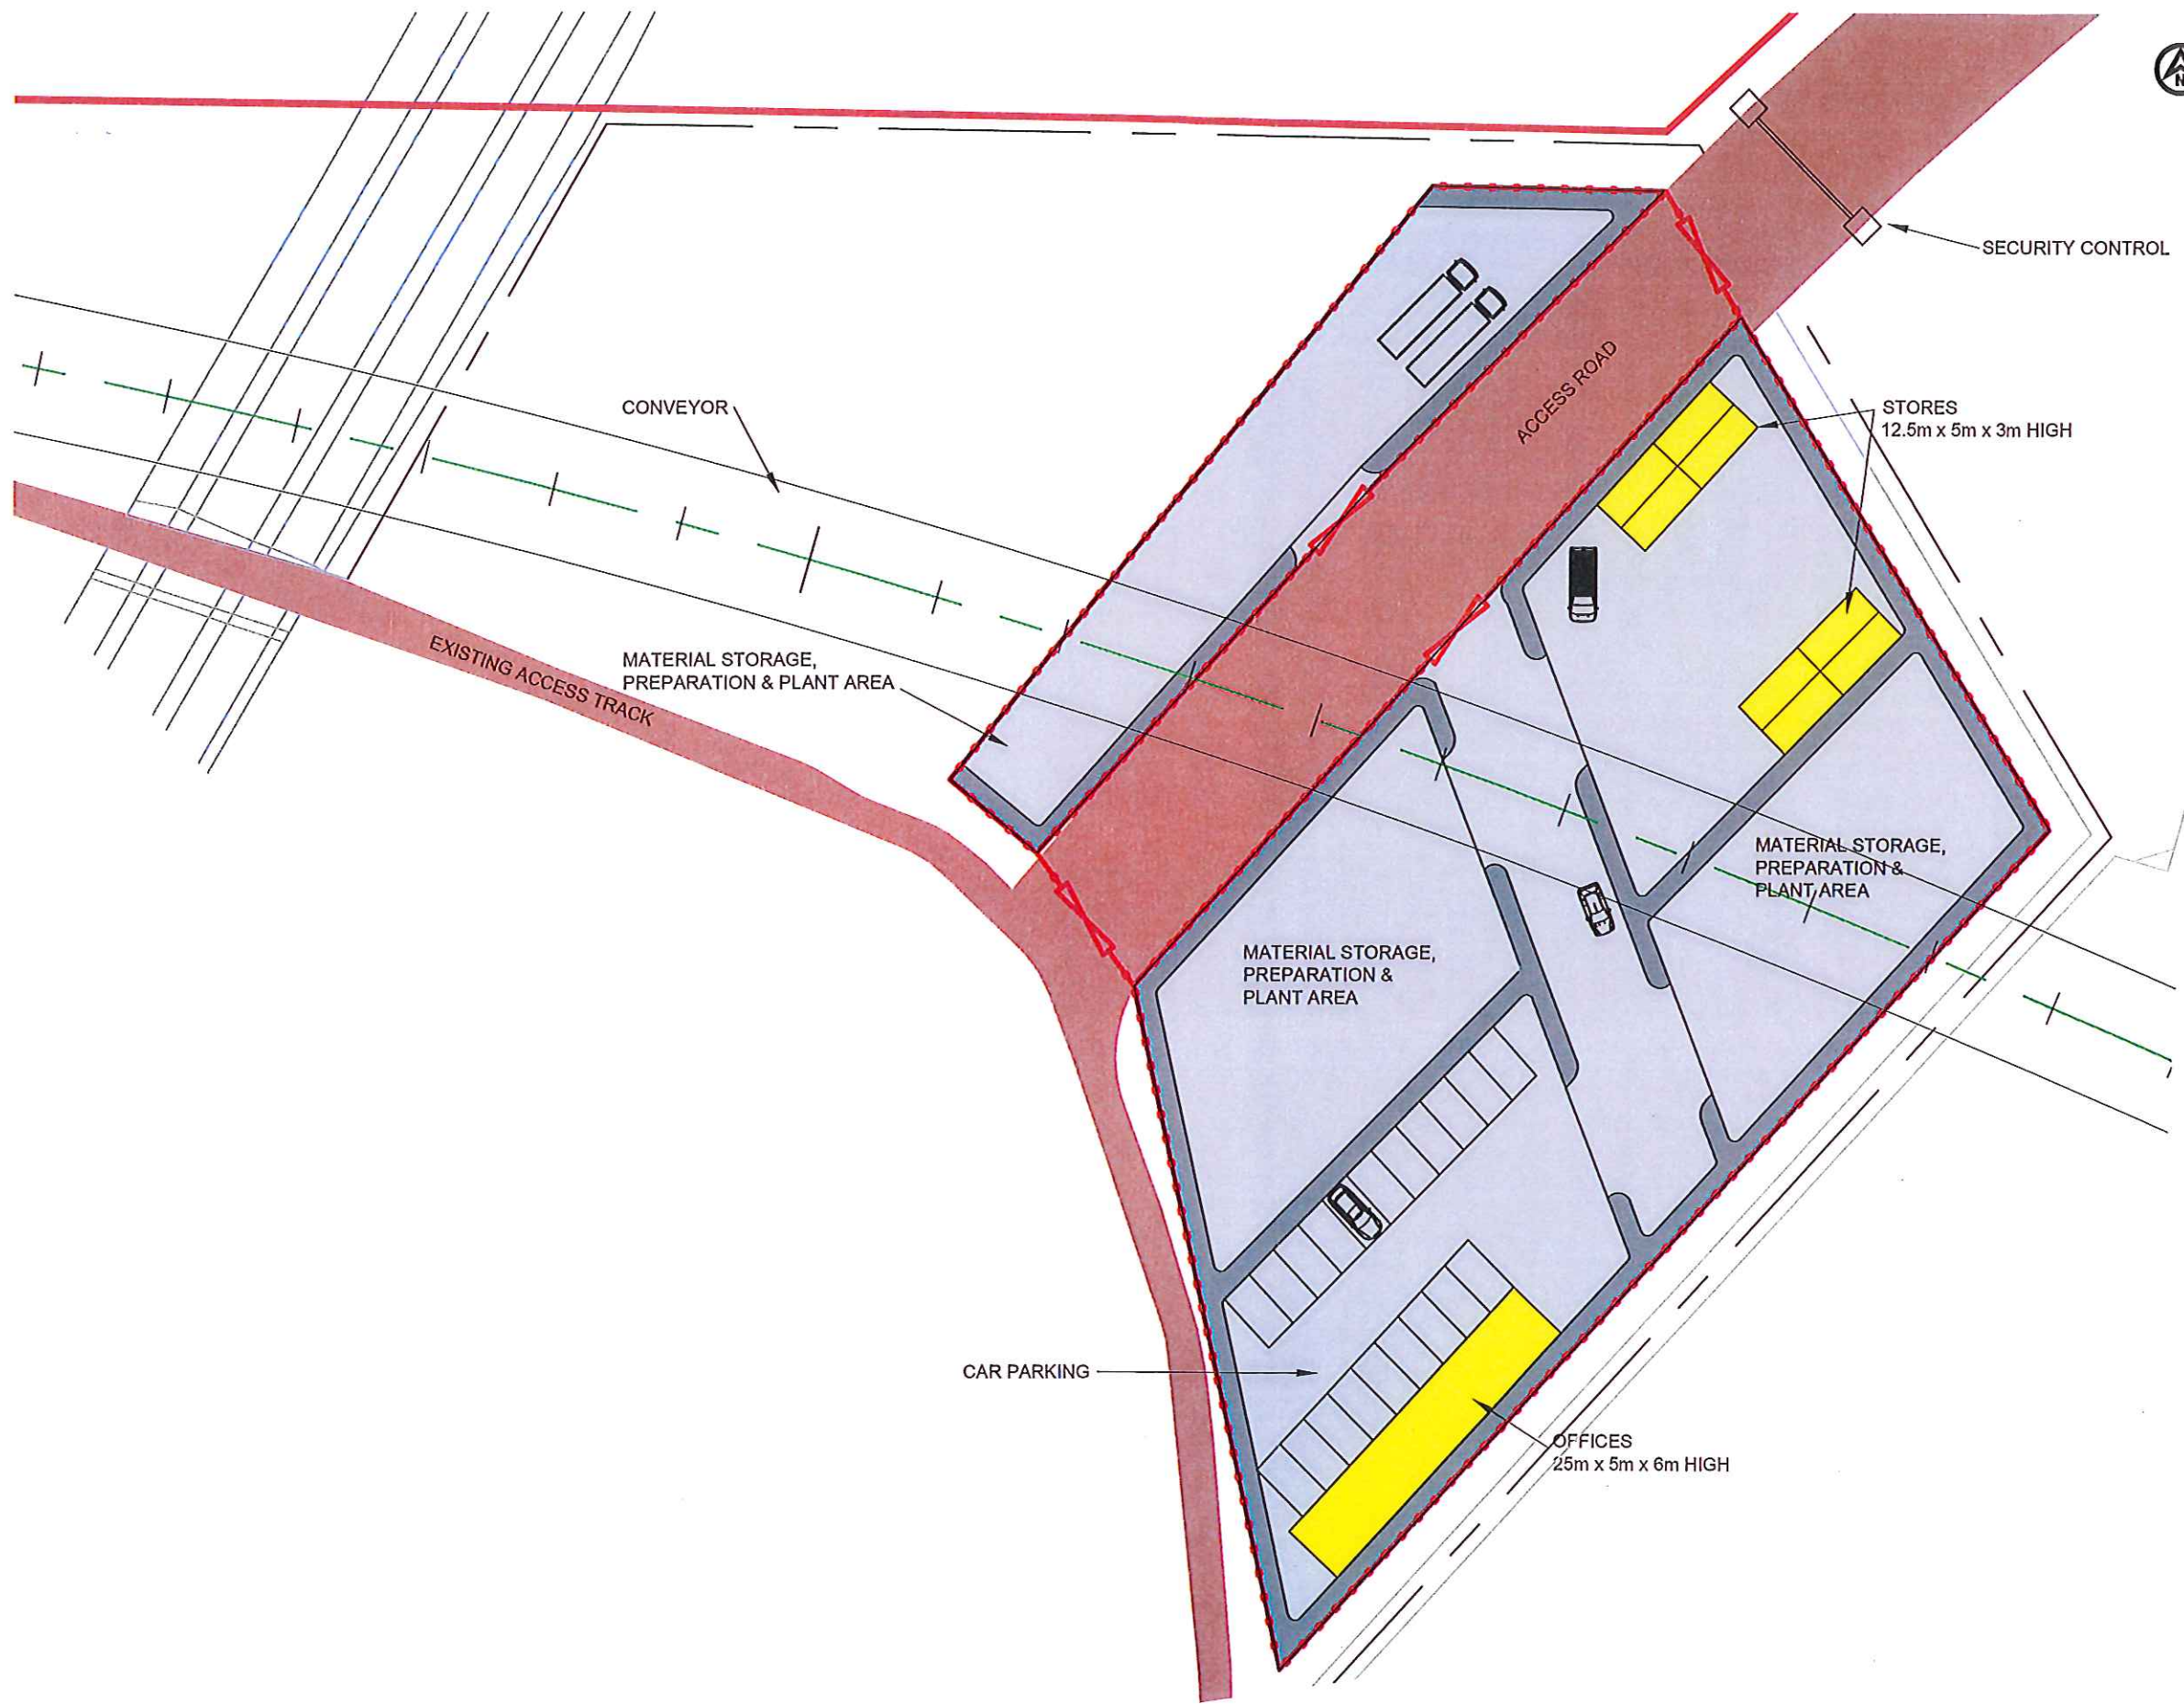

NOTES

LEGEND

- ORDER LIMITS
- EXISTING FENCE LINE
- PEDESTRIAN WALKWAY
- EXISTING ACCESS ROAD
- HARDSTANDING
- BUILDINGS/CONTAINER STORAGE
- SECURITY GATE
- SECURITY FENCE
- SECURITY CONTROL

D	11/11/18	PLANNING ISSUE	LW	DGB	MH
C	01/01/19	MINOR REVISIONS	LW	DGB	MH
B	01/01/19	ISSUED FOR INFORMATION	LW	DGB	MH
A	11/11/18	ISSUED FOR INFORMATION	LW	DGB	RWP
REV	DATE	DESCRIPTION	BY	CHK	APP

REVISIONS



PROJECT
YORK POTASH

TITLE
THE YORK POTASH
HARBOUR FACILITIES ORDER 201X
TEMPORARY COMPOUND SITE E
REGULATION 5 (2)(a)
DOCUMENT 3.4F



DRAWN	LW	CHECKED	DGB	PASSED	RWP
DATE	FEB 15	CLIENT'S REF.			
SCALE AT A3	1:500	AUTOCAD REF.	PB1586-SK1024		
DRAWING NO.	PB1586-SK1024	REVISION	D		



NOTES

LEGEND

- ORDER LIMITS
- EXISTING ABOVE PIPE RACKS
- TEMPORARY ACCESS BRIDGE
- PEDESTRIAN WALKWAY
- ACCESS ROAD
- HARDSTANDING
- BUILDINGS/CONTAINER STORAGE
- SECURITY GATE
- SECURITY FENCE

F	10-08	PLANNING ISSUE	LW	DOB	MRI
E	10-08	MINOR REVISIONS	LW	DOB	MRI
D	11-08	MINOR REVISIONS	LW	DOB	MRI
C	08-08	ISSUED FOR INFORMATION	CH	DOB	MRI
B	08-08	ISSUED FOR INFORMATION	LW	DOB	MRI
A	12-15	ISSUED FOR INFORMATION	LW	DOB	RVP
REV	DATE	DESCRIPTION	BY	CHK	APP

REVISIONS



PROJECT
YORK POTASH

TITLE
THE YORK POTASH
HARBOUR FACILITIES ORDER 201X
TEMPORARY COMPOUND SITE F
REGULATION 5 (2)(o)
DOCUMENT 3.4G



DRAWN	LW	CHECKED	DOB	PASSED	RVP
DATE	FEB15	CLIENTS REF.			
SCALE	ATA3 1:1000	AUTOCAD REF.	PB1586-SK1025		
DRAWING NO.	PB1586-SK1025	REVISION			
					F

NOTES
FOR DETAILS OF THE BUILDINGS PLEASE
REFER TO 25900-RHD-C00-4100-10003.



LEGEND

- DCO ORDER LIMITS
- PEDESTRIAN WALKWAY
- HARDSTANDING
- ACCESS ROAD
- BUILDINGS/CONTAINER STORAGE

NOTE: THIS PLAN SHOWS THE 'OPEN QUAY' OPTION

REV	DATE	DESCRIPTION	BY	CHK	APP
D	14.03	PLANNING ISSUE	LW	DCB	MH
C	11.03	ISSUED FOR INFORMATION	CH	DCB	MH
B	09.03	ISSUED FOR INFORMATION	LW	DCB	MH
A	28.02	ISSUED FOR INFORMATION	LW	DCB	RSP

REVISIONS



PROJECT
YORK POTASH


TITLE
THE YORK POTASH
HARBOUR FACILITIES ORDER 201X
PERMANENT COMPOUND SITE A
REGULATION 5 (2)(o)
DOCUMENT 3.5A


HASKONINGDHV UK LTD
MARITIME & WATERWAYS
Marlborough House
Marlborough Crescent
Newcastle upon Tyne NE1 4EE
+44 (0) 191 211 1300 Telephone
+44 (0) 191 211 1313 Fax
info@haskoningdhv.com E-mail
www.haskoningdhv.com Internet

DATE	DATE	CHECKED	DCB	PASSED	RWP
DATE	FEB'15	CLIENTS REP.			
SCALE AT A3	1:250	AUTOCAD REF.	PB1586-SK1026		


DRAWING No. PB1586-SK1026

REVISION
D

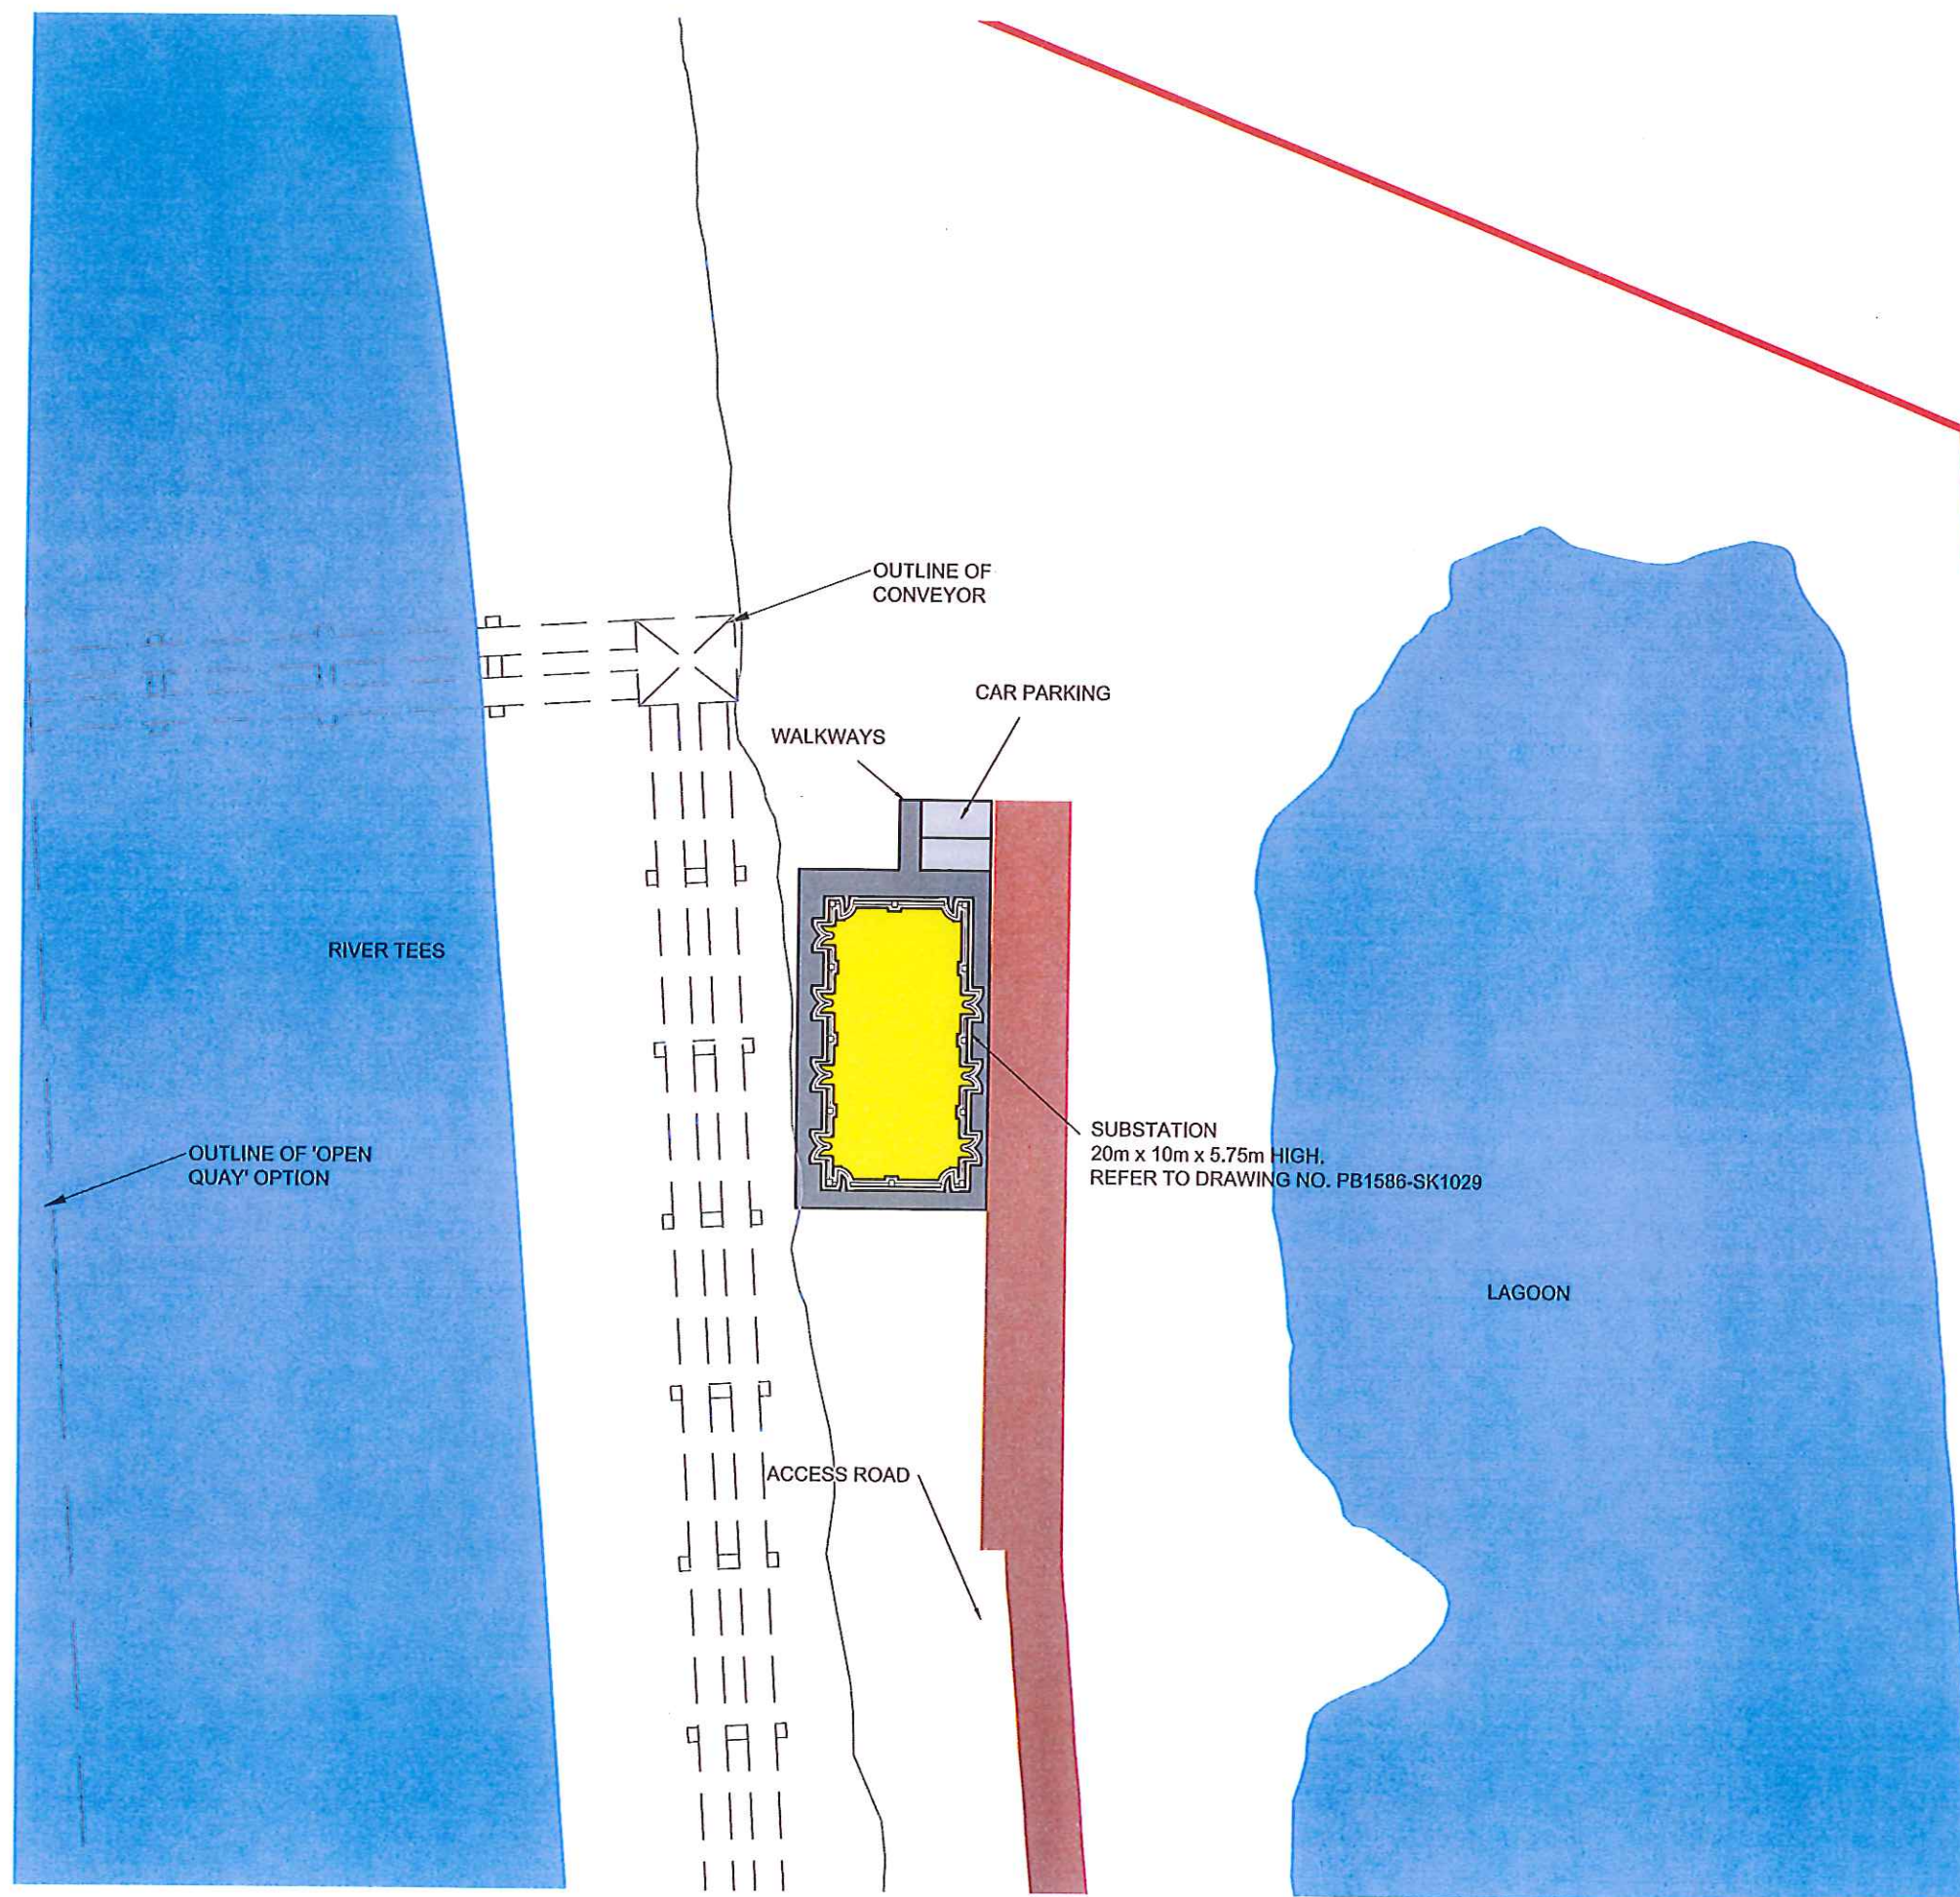

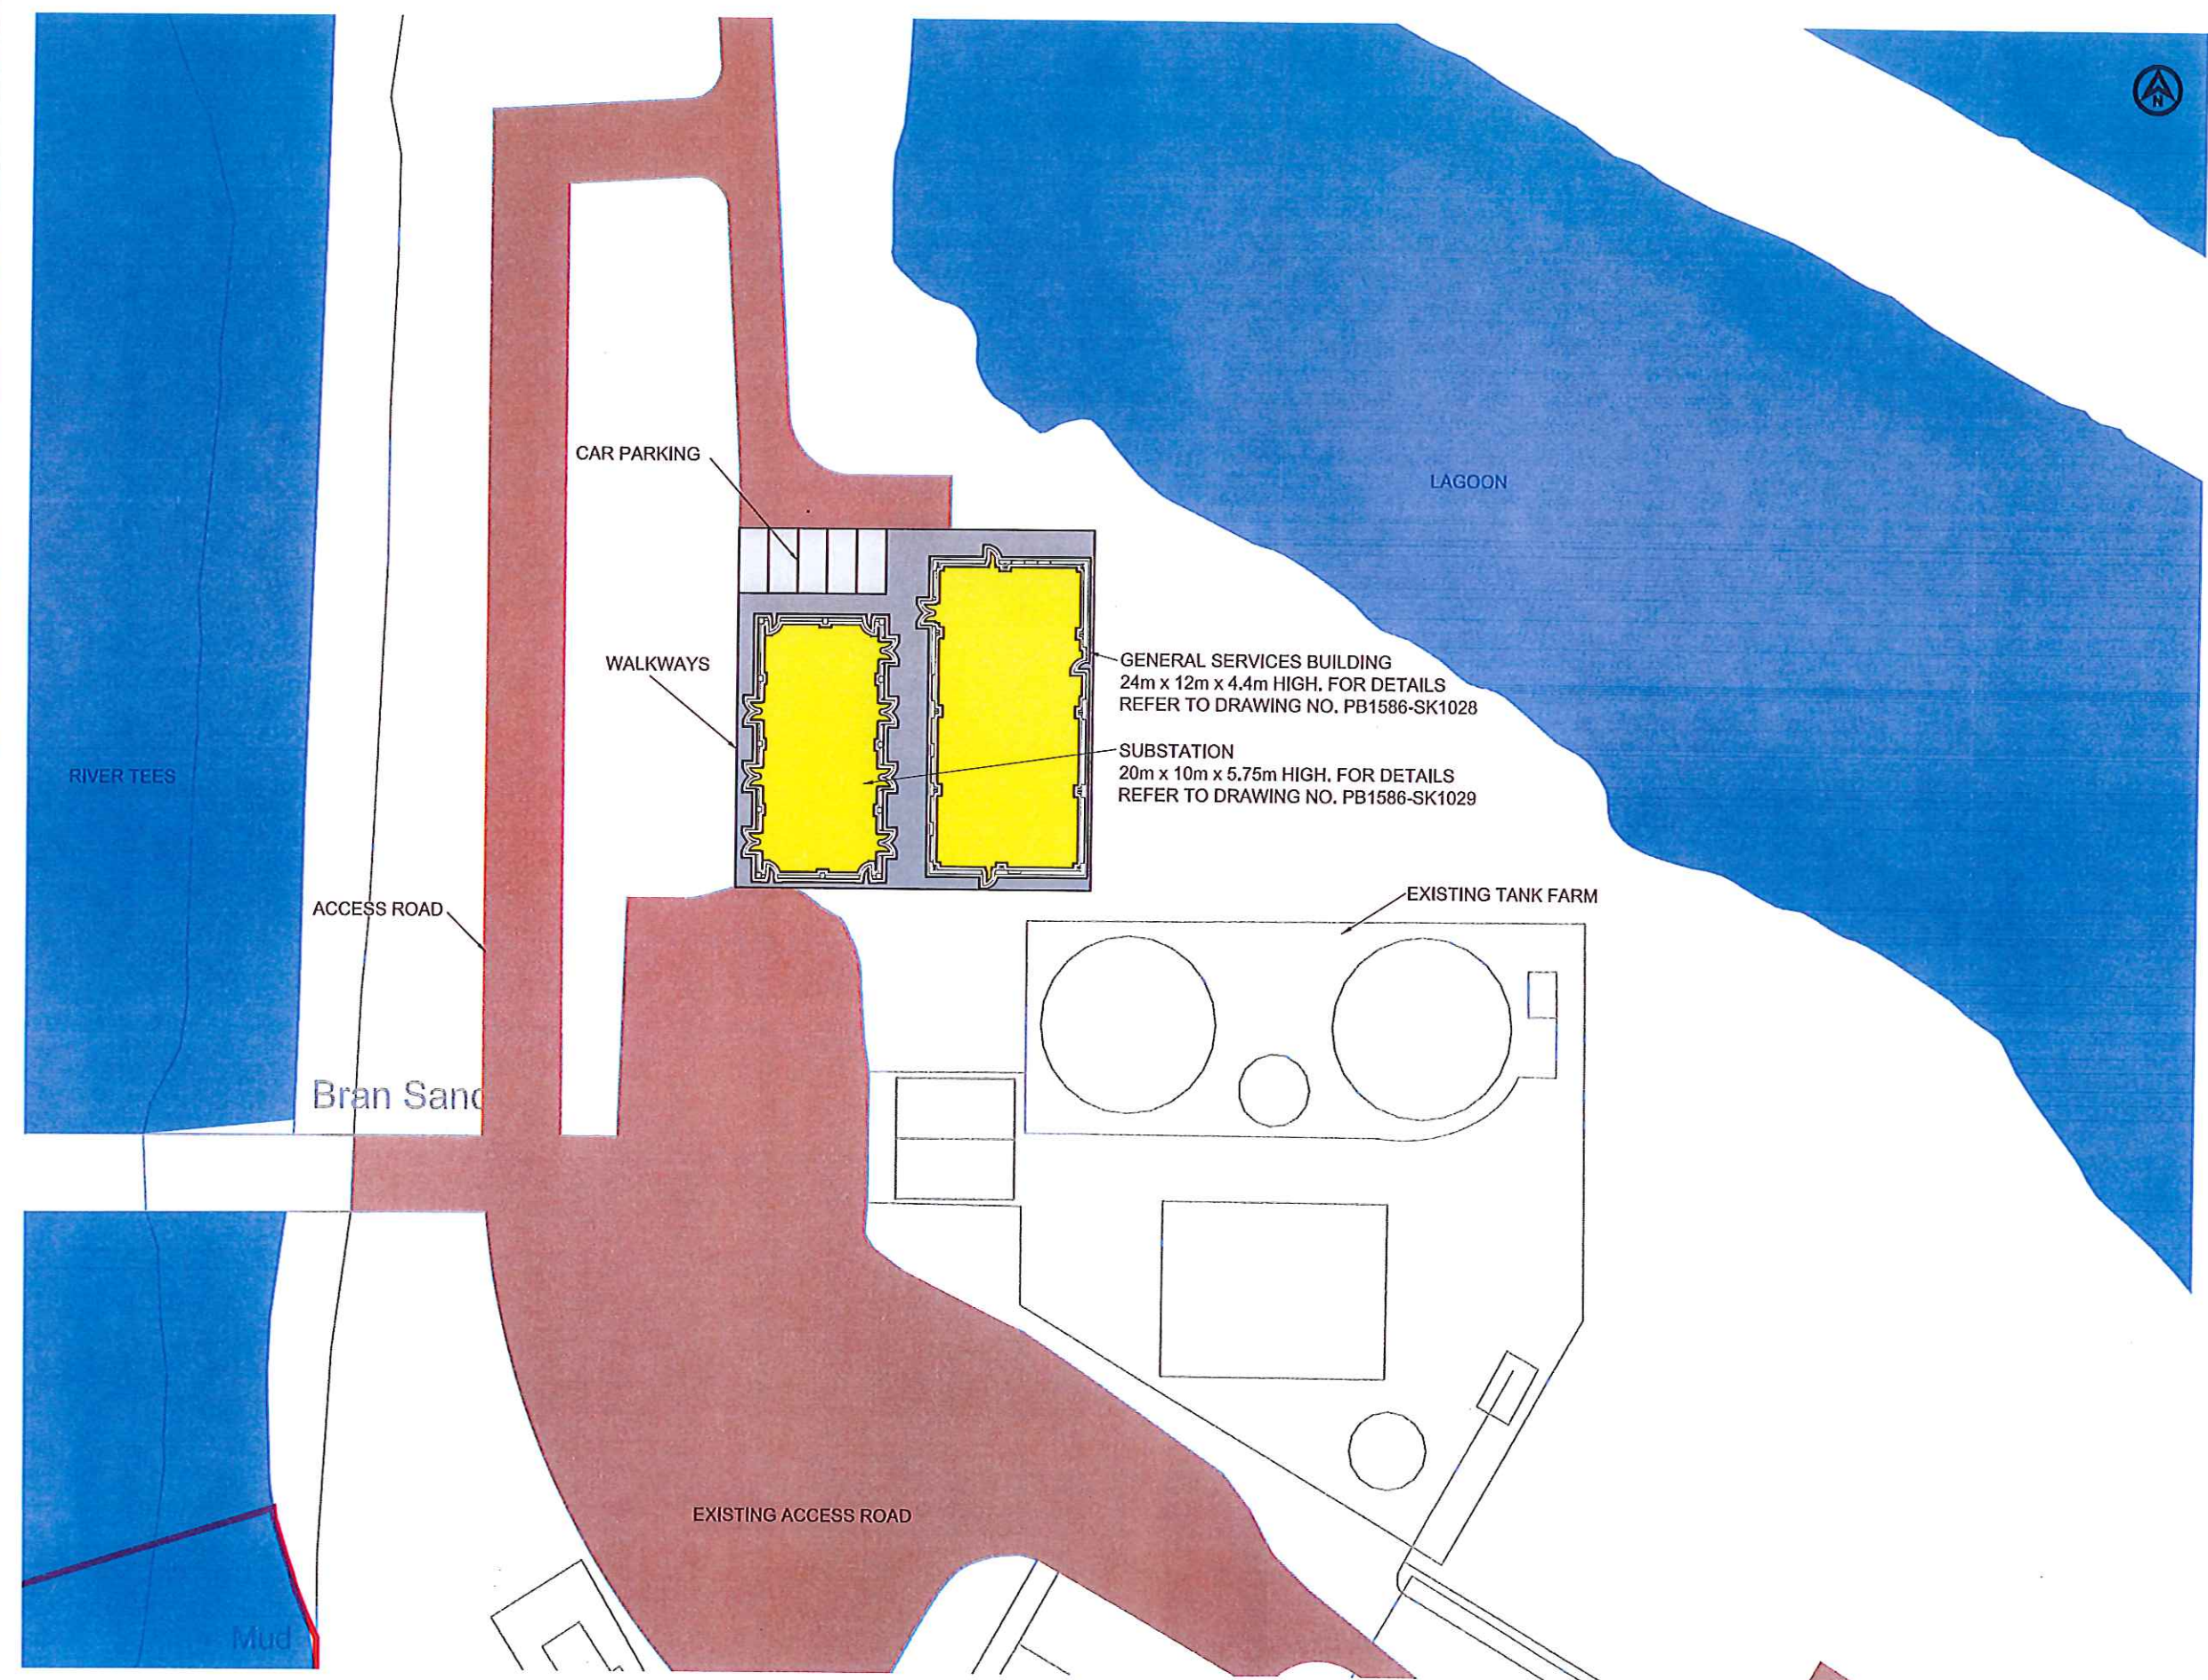

NOTES

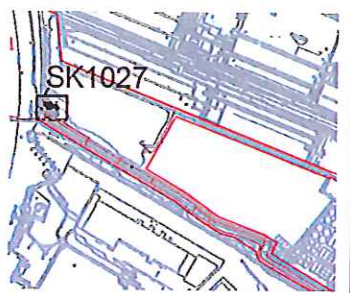

KEY PLAN

LEGEND

- DCO ORDER LIMITS
- PEDESTRIAN WALKWAY
- HARDSTANDING
- ACCESS ROAD
- BUILDINGS/CONTAINER STORAGE

NOTE: THIS PLAN SHOWS THE 'OPEN QUAY' OPTION AND THE NORTHERN ROUTE

F	15.11.15	PLANNING ISSUE	LW	DGB	MM
E	15.11.15	ISSUED FOR INFORMATION	LW	DGB	MM
D	15.11.15	ISSUED FOR INFORMATION	CH	DGB	MM
C	15.11.15	ISSUED FOR INFORMATION	LW	DGB	MM
B	15.11.15	ISSUED FOR INFORMATION	LW	DGB	MM
A	15.11.15	ISSUED FOR INFORMATION	LW	DGB	RAP
REV	DATE	DESCRIPTION	BY	CHK	APP

REVISIONS



PROJECT
YORK POTASH

TITLE
THE YORK POTASH
HARBOUR FACILITIES ORDER 201X
PERMANENT COMPOUND
SITE C - REGULATION 5 (2)(o)
DOCUMENT 3.5B

HASKONINGDHV UK LTD
MARITIME & WATERWAYS
Marborough House
Newcastle upon Tyne NE1 4EE
+44 (0) 191 211 1300 Telephone
+44 (0) 191 211 1313 Fax
info@haskoningdhv.com E-mail
www.haskoningdhv.com Website

DRAWN	LW	CHECKED	DGB	PASSED	RMP
DATE	FEB15	CLIENTS REF.			
SCALE	A3	1:500	AUTOCAD REF.	PB1505-SK1027	
DRAWING NO.	PB1586-SK1027				REVISION F