



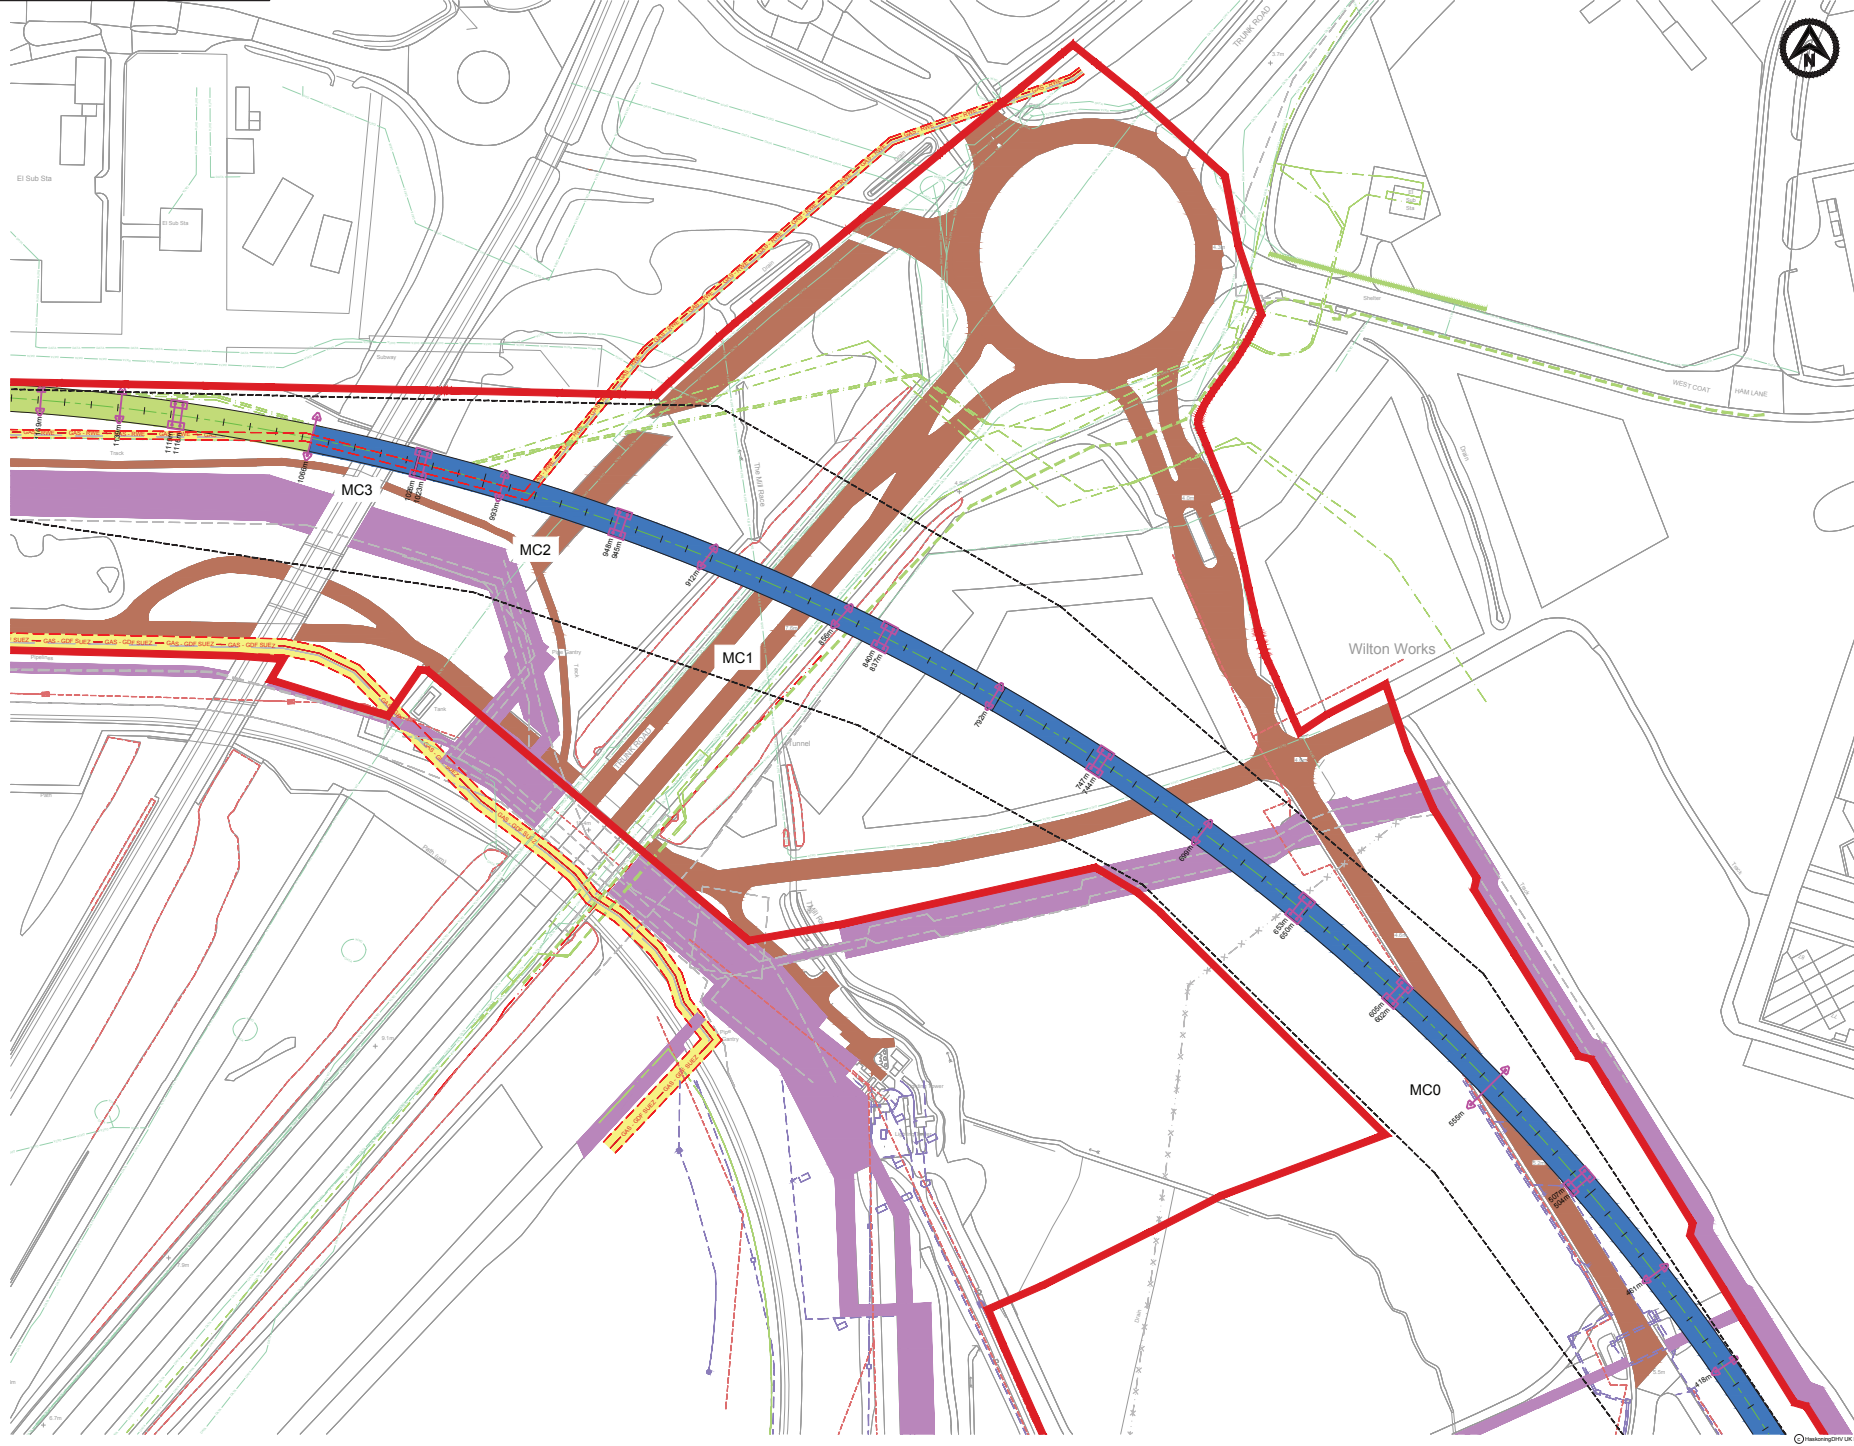

NOTES

- MAJOR CROSSINGS**
- | | |
|----------------------------------|-----------------------------|
| MC 0 - Eastern Boundary Road | - Pass over in bridge |
| MC 1 - Highway A1085 | - Pass over in bridge |
| MC 2 - VPL 1st access road | - Pass over in bridge |
| MC 3 - Red metal rail | - Pass over in bridge |
| MC 4 - NWL 2nd access road | - Pass over in bridge |
| MC 5 - National power grid lines | - Pass under 10 m clearance |
| MC 6 - SSI road bridge | - Pass over in bridge |
| MC 7 - National rail way | - Pass over in bridge |
| MC 8 - Access NWL W.T.P. | - Pass over in bridge |
| MC 9 - Outfall | - Pass over in bridge |

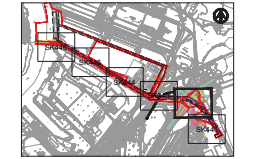

KEY PLAN
SCALE 1:50000

LEGEND - CONVEYOR

- TYPE 3 - OPEN CONVEYOR - 2 LEGS
- TYPE 4 - OVAL ENCLOSED CONVEYOR - 2 LEGS
- TRANSFER TOWER
- ACCESS ROADS
- CONVEYOR FOOTINGS
- CONVEYOR AT THE QUAY

LEGEND - EXISTING SERVICES

- EASEMENT ZONES
- GAS - BP CATS
- GAS - GDF SUEZ
- GAS - RWE
- FIBRE OPTIC CABLE
- MSC - DRAINS, CABLES, DUCTS
- FOUL WATER - SEMICORP
- WATER - NWL
- GAS - ABANDONED
- ABOVEGROUND PIPELINE CORRIDOR
- OVERHEAD POWER CABLES
- CONVEYOR LIMITS OF DEVIATION

E	14/11/15	PLANNING ISSUE	LW	DGB	MM
D	14/11/15	MINOR REVISIONS	CH	DGB	MM
C	11/11/15	MINOR REVISIONS	LW	DGB	MM
B	14/11/15	ISSUED FOR INFORMATION	TF	DGB	MM
A	14/11/15	ISSUED FOR INFORMATION	LW	DGB	SM
REV	DATE	DESCRIPTION	BY	CHK	APP

REVISIONS



PROJECT
YORK POTASH

TITLE
**THE YORK POTASH
HARBOUR FACILITIES ORDER 201X
CONVEYOR ROUTE PLANS
SOUTHERN ROUTE - SHEET 2
REGULATION 5(2)(a) DOCUMENT 3.3C**



DRAWN	LW	CHECKED	DGB	PASSED	SM
DATE	JAN'16	CLIENTS REF.			
SCALE AT A1	1:1000	AUTOCAD REF.	PB1586-SK1042		
DRAWING No.	PB1586-SK1042	REVISION			E