



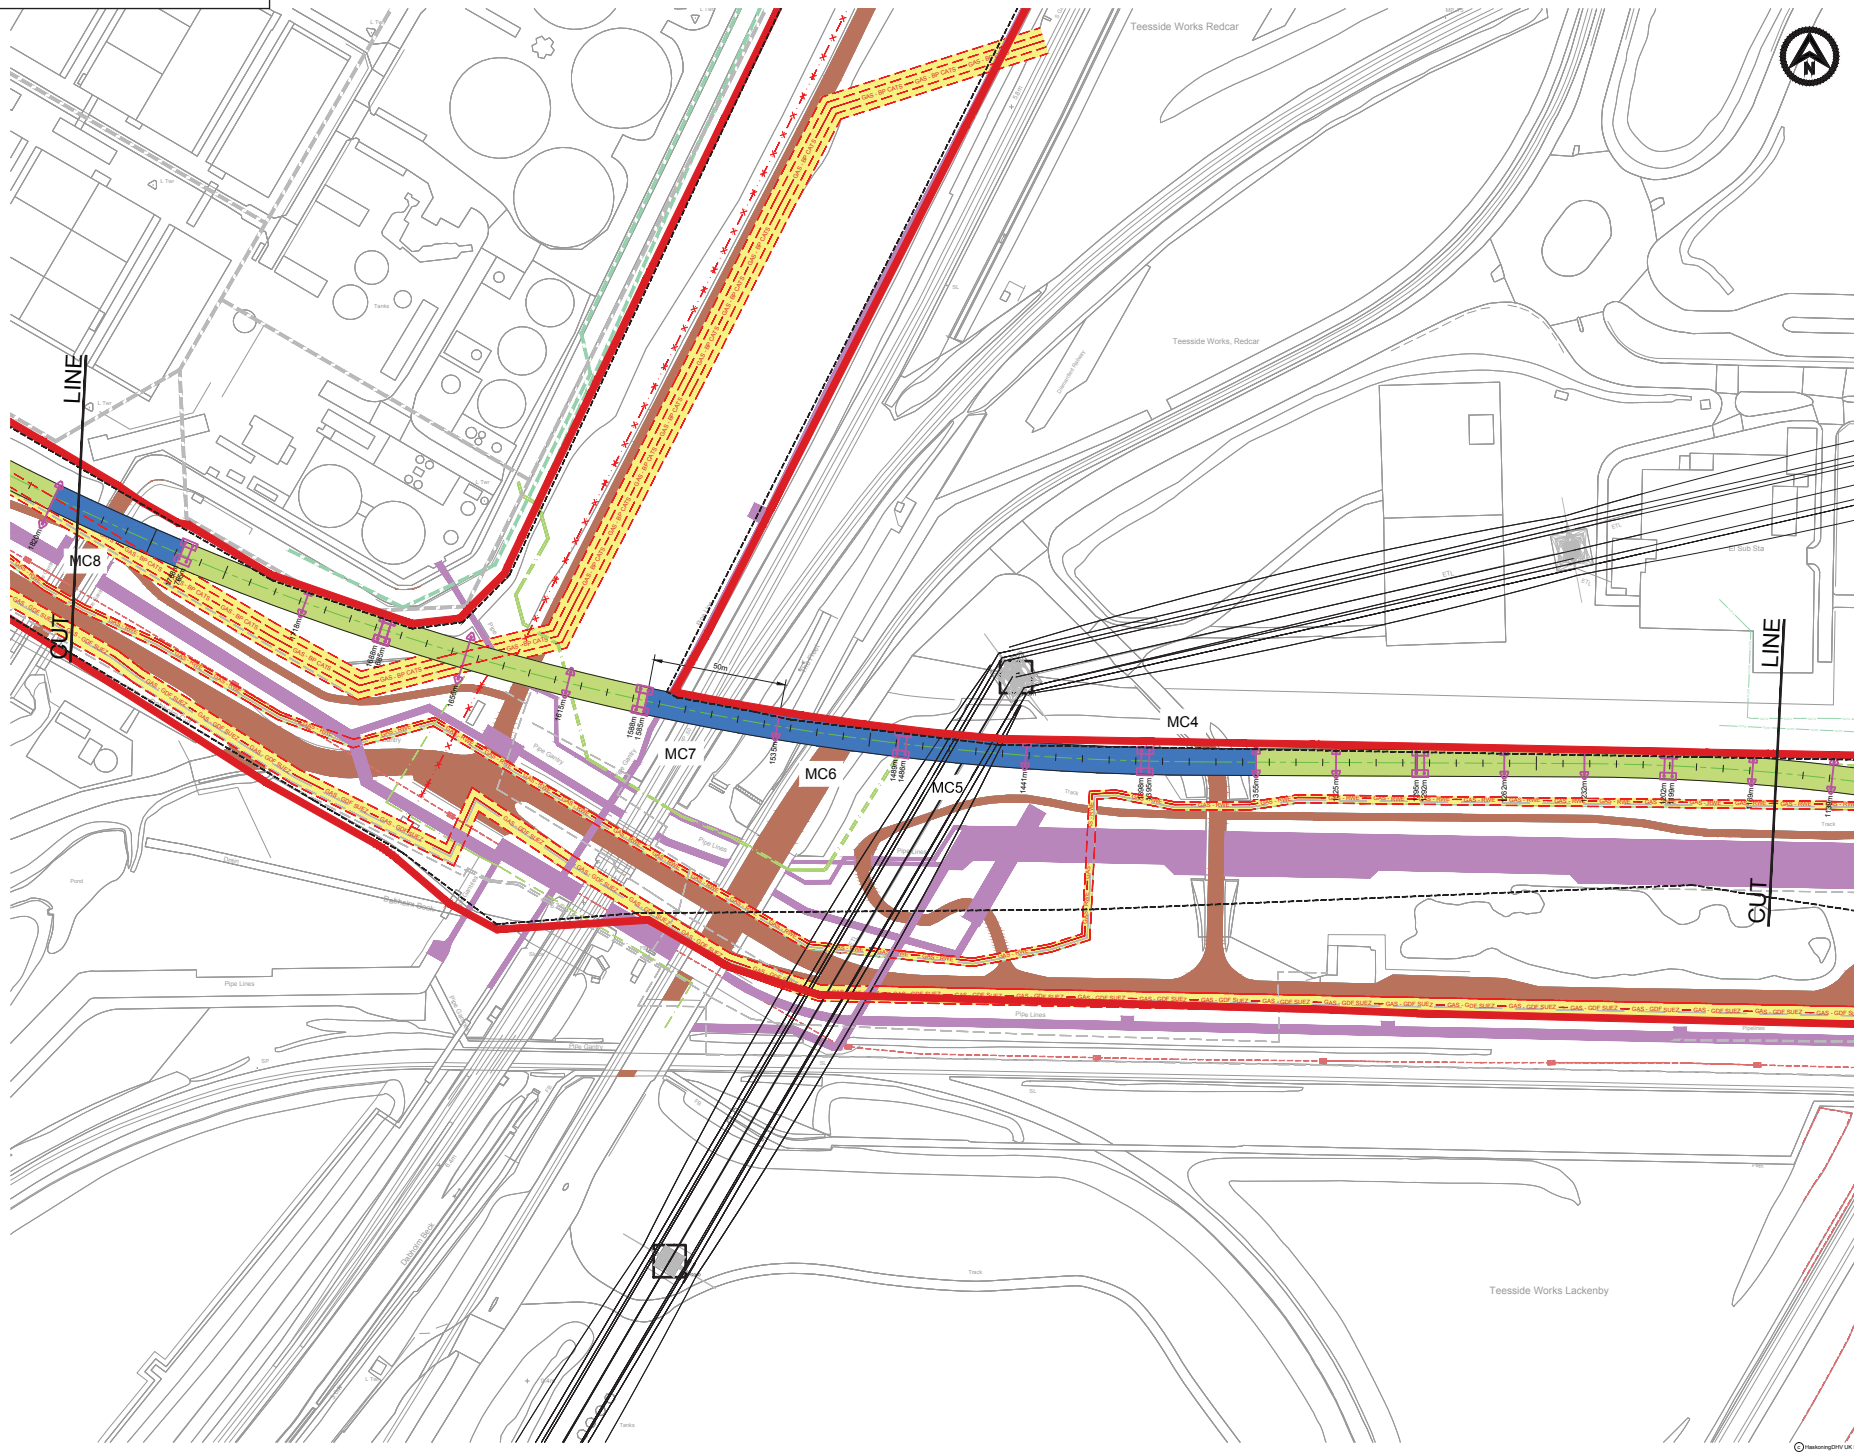

- NOTES
- MAJOR CROSSINGS**
- | | |
|----------------------------------|-----------------------------|
| MC 0 : Eastern Boundary Road | - Pass over in bridge |
| MC 1 : Highway A1085 | - Pass over in bridge |
| MC 2 : YPL 1st access road | - Pass over in bridge |
| MC 3 : Hot metal rail | - Pass over in bridge |
| MC 4 : NWL 2nd access road | - Pass over in bridge |
| MC 5 : National power grid lines | - Pass under 10 m clearance |
| MC 6 : SSI road bridge | - Pass over in bridge |
| MC 7 : National rail way | - Pass over in bridge |
| MC 8 : Access NWL W.T.P. | - Pass over in bridge |
| MC 9 : Outfall | - Pass over in bridge |

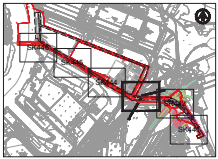

- LEGEND - CONVEYOR**
- TYPE 3 - OPEN CONVEYOR - 2 LEGS
 - TYPE 4 - OVAL ENCLOSED CONVEYOR - 2 LEGS
 - TRANSFER TOWER
 - ACCESS ROADS
 - CONVEYOR FOOTINGS
 - CONVEYOR AT THE QUAY

- LEGEND - EXISTING SERVICES**
- EASEMENT ZONES
 - GAS - BP CATS
 - GAS - GDF SUEZ
 - GAS - RWE
 - FIBRE OPTIC CABLE
 - MSG - DRAINS, CABLES, DUCTS
 - FOUL WATER - SEMBCORP
 - WATER - NWL
 - GAS - ABANDONED
 - ABOVEGROUND PIPELINE CORRIDOR
 - OVERHEAD POWER CABLES
 - CONVEYOR LIMITS OF DEVIATION

E	11/11/11	PLANNING ISSUE	LW	DGB	MM
D	11/11/11	MINOR REVISIONS	CH	DGB	MM
C	11/11/11	MINOR REVISIONS	LW	DGB	MM
B	11/11/11	ISSUED FOR INFORMATION	TF	DGB	MM
A	11/11/11	ISSUED FOR INFORMATION	LW	DGB	SM
REV	DATE	DESCRIPTION	BY	CHK	APP



PROJECT

YORK POTASH

TITLE

THE YORK POTASH
HARBOUR FACILITIES ORDER 201X
CONVEYOR ROUTE PLANS
SOUTHERN ROUTE - SHEET 3
REGULATION 5(2)(g) DOCUMENT 3.3D

MARKETING	TECHNICAL	DESIGN	CONSTRUCTION	OPERATION	MAINTENANCE
DATE	JAN'15	CHECKED	DGB	PASSED	SM
SCALE AT A1	1:1000	AUTOCAD REF.	PB1586-SK1043	DRAWING No.	PB1586-SK1043
REVISION	E				