



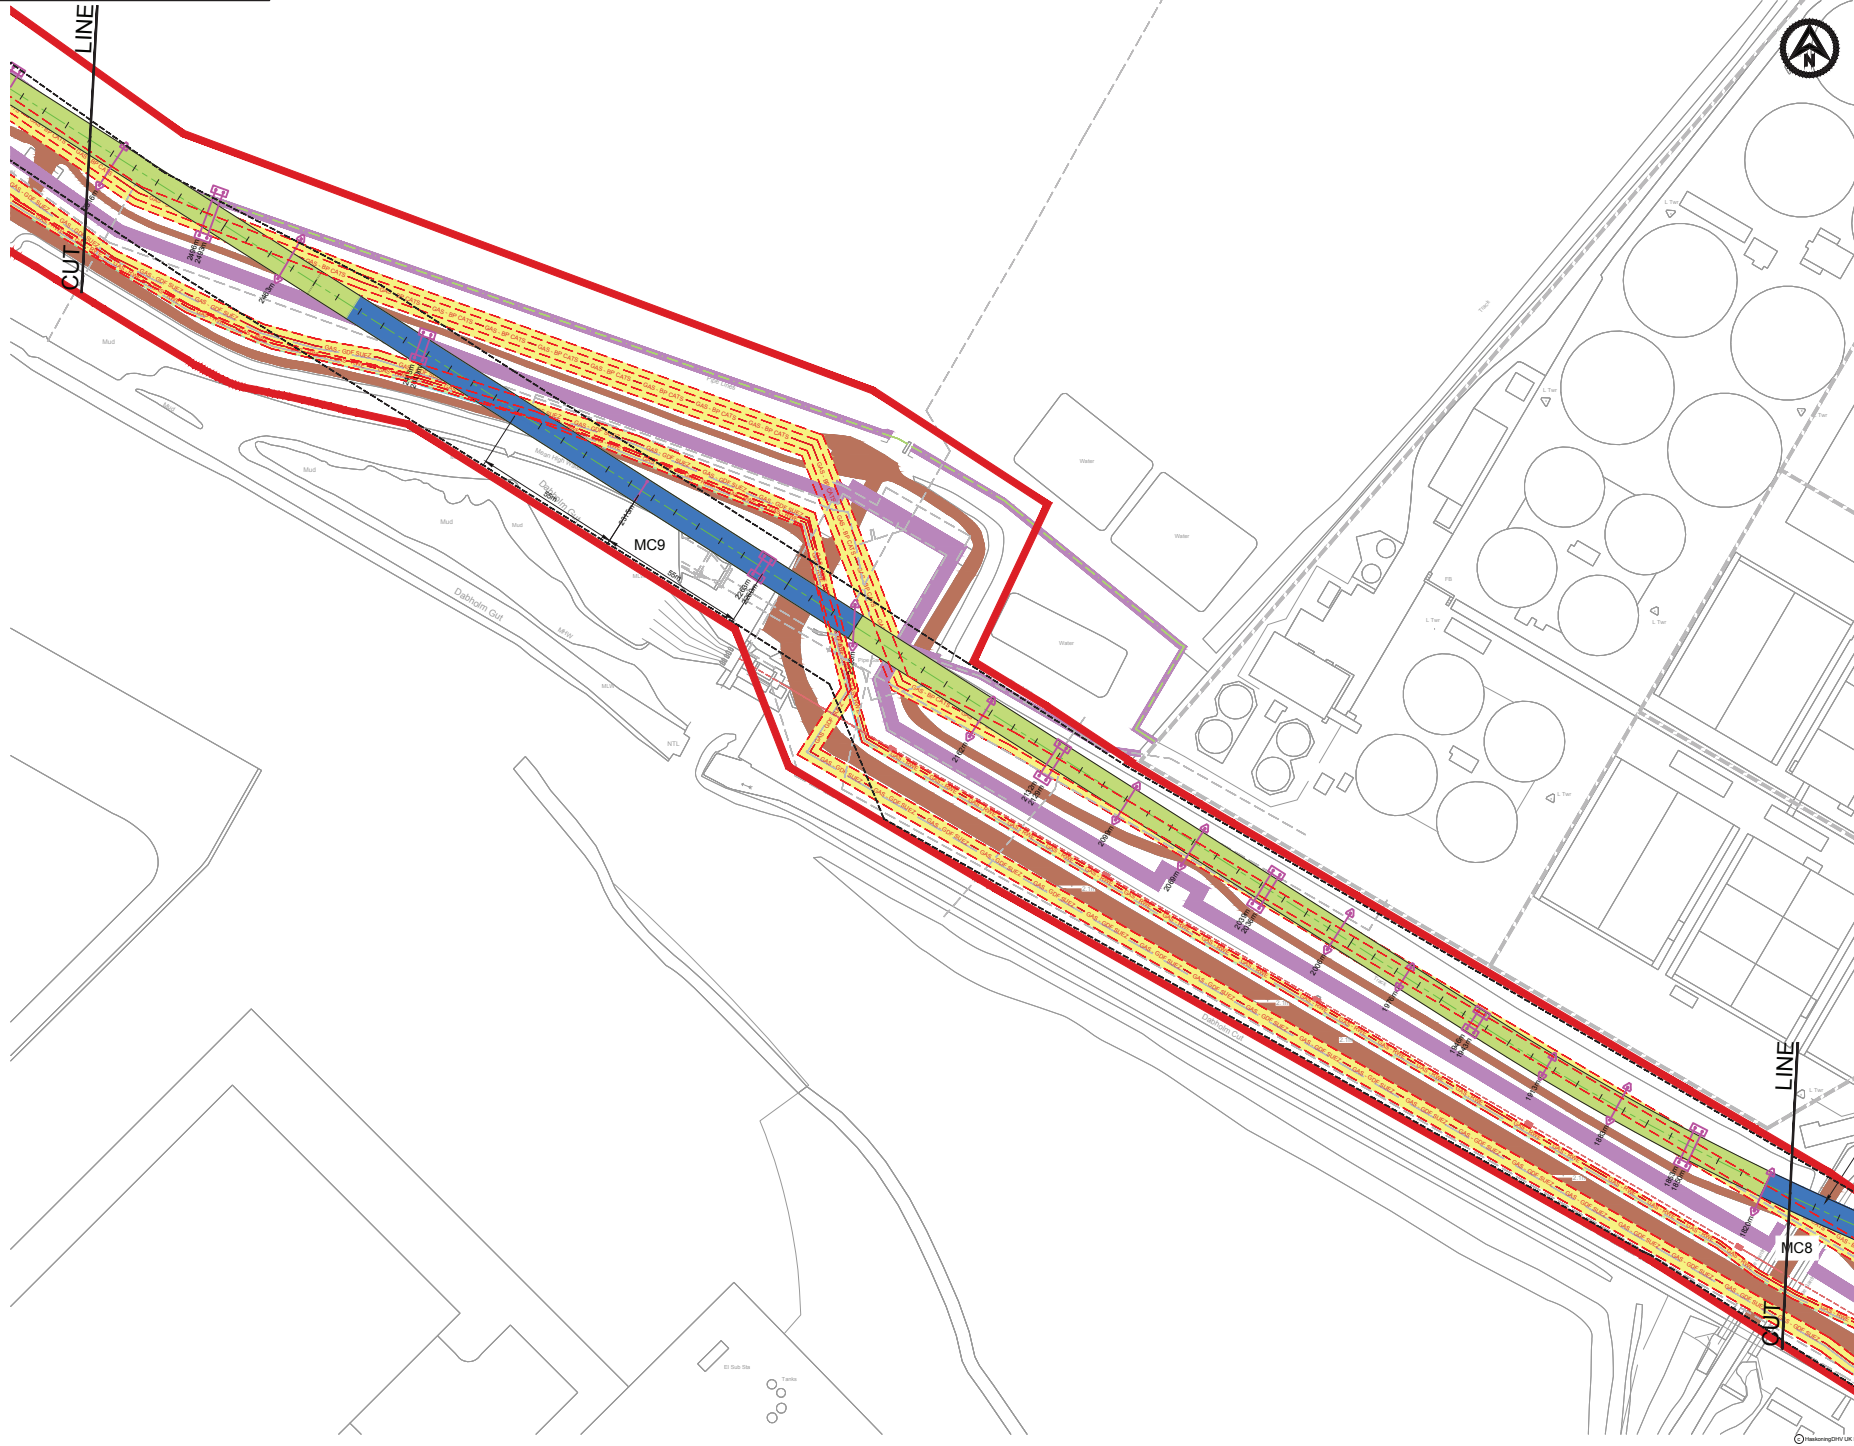

NOTES

- MAJOR CROSSINGS**
- | | |
|----------------------------------|-----------------------------|
| MC 0 : Eastern Boundary Road | - Pass over in bridge |
| MC 1 : Highway A1085 | - Pass over in bridge |
| MC 2 : YPL 1st access road | - Pass over in bridge |
| MC 3 : Hot metal rail | - Pass over in bridge |
| MC 4 : NWL 2nd access road | - Pass over in bridge |
| MC 5 : National power grid lines | - Pass under 10 m clearance |
| MC 6 : SSI road bridge | - Pass over in bridge |
| MC 7 : National rail way | - Pass over in bridge |
| MC 8 : Access NWL W.T.P. | - Pass over in bridge |
| MC 9 : Outfall | - Pass over in bridge |

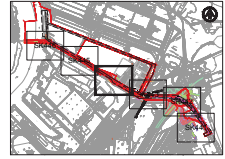

KEY PLAN
SCALE 1:50000

- LEGEND - CONVEYOR**
- TYPE 3 - OPEN CONVEYOR - 2 LEGS
 - TYPE 4 - OVAL ENCLOSED CONVEYOR - 2 LEGS
 - TRANSFER TOWER
 - ACCESS ROADS
 - CONVEYOR FOOTINGS
 - CONVEYOR AT THE QUAY

- LEGEND - EXISTING SERVICES**
- EASEMENT ZONES
 - GAS - BP CATS
 - GAS - GDF SUEZ
 - GAS - RWE
 - FIBRE OPTIC CABLE
 - MISC - DRAINS, CABLES, DUCTS
 - FULL WATER - SEMICORP
 - WATER - NWL
 - GAS - ABANDONED
 - ABOVEGROUND PIPELINE CORRIDOR
 - OVERHEAD POWER CABLES
 - CONVEYOR LIMITS OF DEVIATION

E	11/11/15	PLANNING ISSUE	LW	DGB	MH
D	10/11/15	MINOR REVISIONS	CH	DGB	MH
C	11/11/15	MINOR REVISIONS	LW	DGB	MH
B	10/11/15	ISSUED FOR INFORMATION	TF	DGB	MH
A	10/11/15	ISSUED FOR INFORMATION	LW	DGB	SM
REV	DATE	DESCRIPTION	BY	CHK	APP

REVISIONS



PROJECT
YORK POTASH

TITLE
**THE YORK POTASH
HARBOUR FACILITIES ORDER 201X
CONVEYOR ROUTE PLANS
SOUTHERN ROUTE - SHEET 4
REGULATION 5(2)(a) DOCUMENT 3.3E**



DRAWN	LW	CHECKED	DGB	PASSED	SM
DATE	JAN'15	CLIENTS REF			
SCALE AT A1	1:1000	AUTOCAD REF	PB1586-SK1044		
DRAWING No.	PB1586-SK1044	REVISION			E