



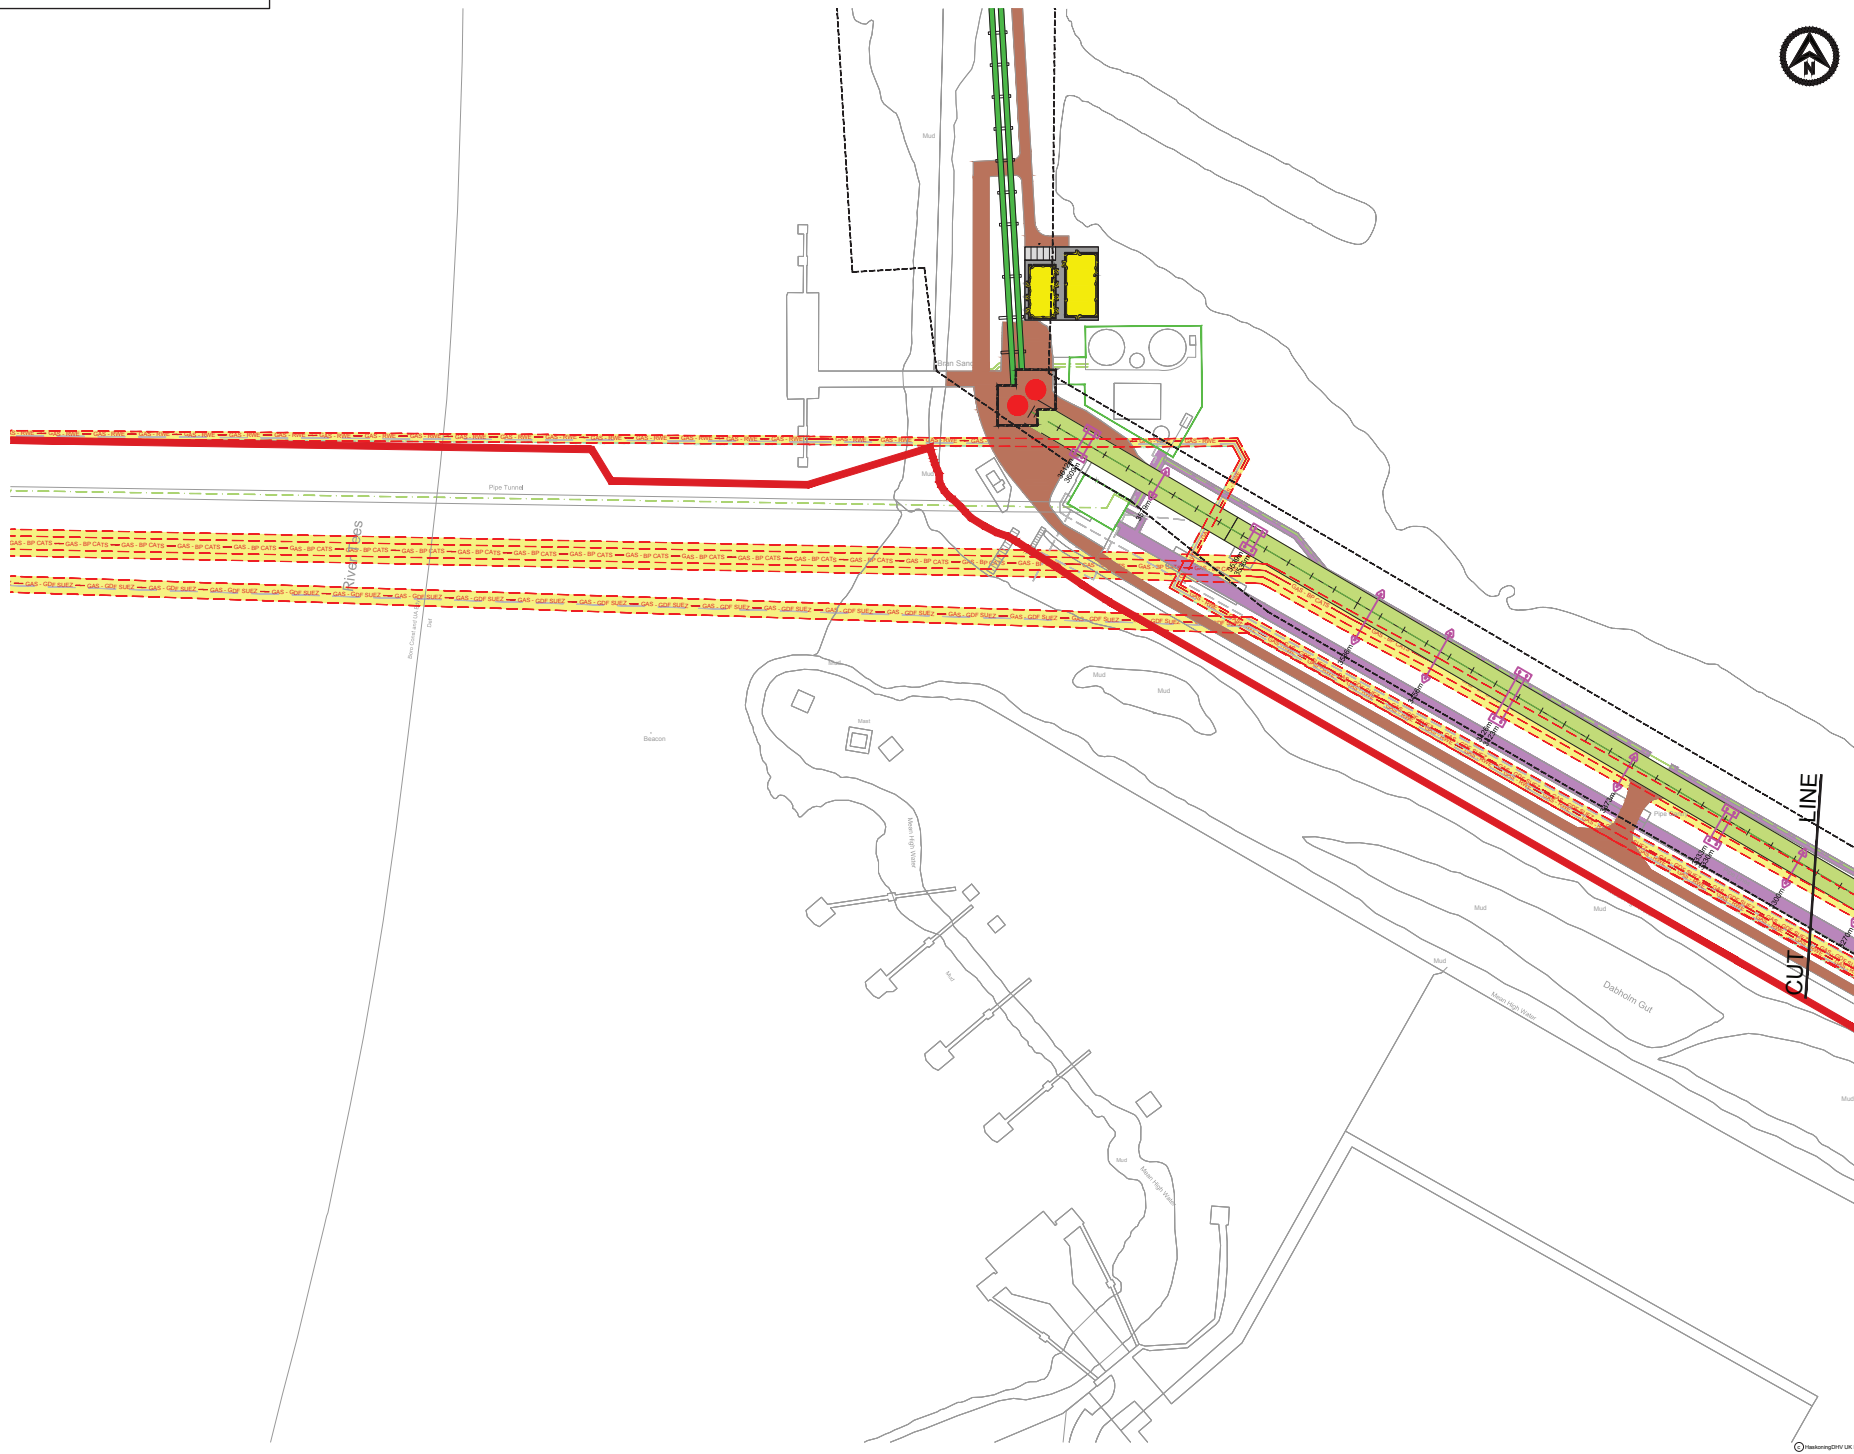

NOTES

MAJOR CROSSINGS

MC 0 : Eastern Boundary Road	- Pass over in bridge
MC 1 : Highway A1085	- Pass over in bridge
MC 2 : VPL 1st access road	- Pass over in bridge
MC 3 : Hot metal rail	- Pass over in bridge
MC 4 : NWL 2nd access road	- Pass over in bridge
MC 5 : National power grid lines	- Pass under 10 m clearance
MC 6 : SSI road bridge	- Pass over in bridge
MC 7 : National rail way	- Pass over in bridge
MC 8 : Access NWL W.T.P.	- Pass over in bridge
MC 9 : Outfall	- Pass over in bridge

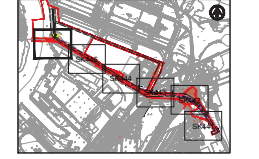

KEY PLAN
SCALE 1:50000

LEGEND - CONVEYOR

- TYPE 3 - OPEN CONVEYOR - 2 LEGS
- TYPE 4 - OVAL ENCLOSED CONVEYOR - 2 LEGS

LEGEND - EXISTING SERVICES

- EASEMENT ZONES
- GAS - BP CATS
- GAS - GDF SUEZ
- GAS - RWE
- FIBRE OPTIC CABLE
- MISC - DRAINS, CABLES, DUCTS
- FOUL WATER - SEMBCORP
- WATER - NWL
- GAS - ABANDONED
- ABOVEGROUND PIPELINE CORRIDOR
- OVERHEAD POWER CABLES
- CONVEYOR FOOTINGS
- CONVEYOR AT THE QUAY
- CONVEYOR LIMITS OF DEVIATION

E	14/11/14	PLANNING ISSUE	LW	DGB	MH
D	04/11/14	MINOR REVISIONS	CH	DGB	MH
C	11/01/15	MINOR REVISIONS	LW	DGB	MH
B	14/01/15	ISSUED FOR INFORMATION	TF	DGB	MH
A	04/01/14	ISSUED FOR INFORMATION	LW	DGB	SM
REV	DATE	DESCRIPTION	BY	CHK	APP



PROJECT

YORK POTASH

TITLE

**THE YORK POTASH
HARBOUR FACILITIES ORDER 201X
CONVEYOR ROUTE PLANS
SOUTHERN ROUTE - SHEET 6
REGULATION 5(2)(g) DOCUMENT 3.3G**

HASKONINGDHV UK LTD
MARITIME & WATERWAYS
Maritime & Waterways
Newcastle upon Tyne NE2 4EJ
+44 (0) 191 211 1300 Telephone
+44 (0) 191 211 1313 Fax
info@haskoningdhv.com E-mail
www.haskoningdhv.com Internet

DRAWN	LW	CHECKED	DGB	PASSED	SM
DATE	JAN'15	CLIENTS REF.			
SCALE AT A1	1:1000	AUTOCAD REF.	PB1586-SK1046		
DRAWING No.	PB1586-SK1046	REVISION	E		