


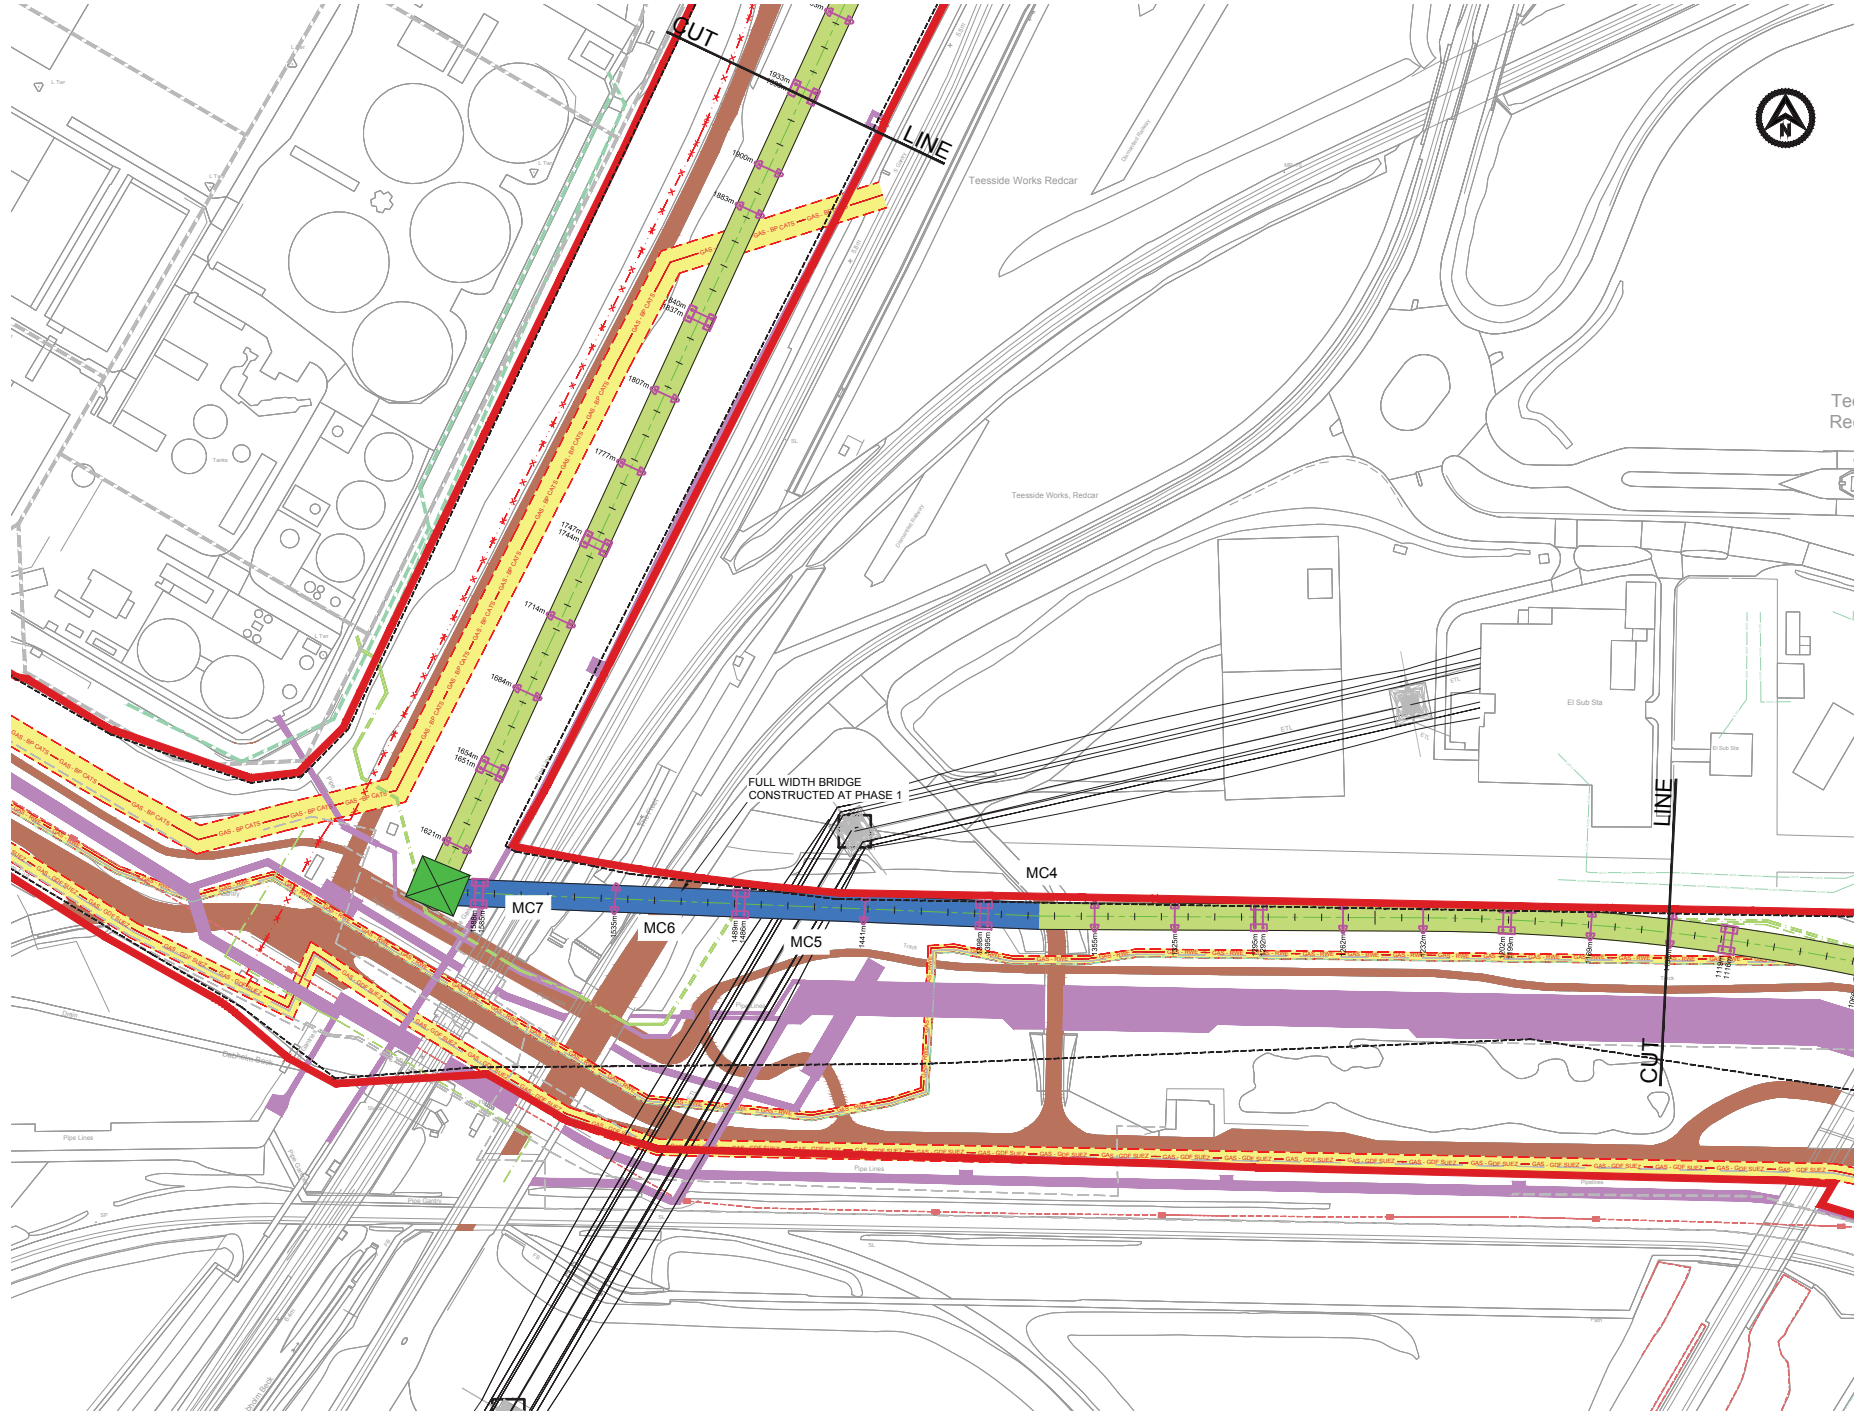

NOTES

MAJOR CROSSINGS

MC 0 : Eastern Boundary Road	- Pass over in bridge
MC 1 : Highway A1085	- Pass over in bridge
MC 2 : VPL 1st access road	- Pass over in bridge
MC 3 : Hot metal rail	- Pass over in bridge
MC 4 : NWL 2nd access road	- Pass over in bridge
MC 5 : National power grid lines	- Pass under 10 m clearance
MC 6 : SSI road bridge	- Pass over in bridge
MC 7 : National rail way	- Pass over in bridge
MC 8 : Access NWL W.T.P.	- Pass over in bridge
MC 9 : Outfall	- Pass over in bridge



LEGEND - CONVEYOR

	TYPE 3 - OPEN CONVEYOR - 2 LEGS
	TYPE 4 - OVAL ENCLOSED CONVEYOR - 2 LEGS
	TRANSFER TOWER
	ACCESS ROUTES
	CONVEYOR FOOTINGS
	CONVEYOR AT THE QUAY

LEGEND - EXISTING SERVICES

	EASEMENT ZONES
	GAS - BP CATS
	GAS - GDF SUEZ
	GAS - RWE
	FIBRE OPTIC CABLE
	MISC - DRAINS, CABLES, DUCTS
	FOUL WATER - SEMICORP
	WATER - NWL
	GAS - ABANDONED
	ABOVEGROUND PIPELINE CORRIDOR
	OVERHEAD POWER CABLES
	CONVEYOR LATERAL LIMITS OF DEVIATION

E	11/01/16	PLANNING ISSUE	LW	DGB	MH
D	11/01/16	MINOR REVISIONS	CH	DGB	MH
C	11/01/16	MINOR REVISIONS	LW	DGB	MH
B	11/01/16	ISSUED FOR APPROVAL	TF	DGB	MH
A	17/01/16	FIRST ISSUE	LW	DGB	RWP
REV	DATE	DESCRIPTION	BY	CHK	APP



PROJECT

YORK POTASH

TITLE

**THE YORK POTASH
HARBOUR FACILITIES ORDER 201X
CONVEYOR ROUTE PLANS
NORTHERN ROUTE - SHEET 3
REGULATION 5(2)(a) DOCUMENT 3.3K**

HASKONINGDHV UK LTD
MARITIME & WATERWAYS
Maritime Quay
Marine Parade
Newcastle upon Tyne NE2 6EE
44 (0) 191 211 1300 Telephone
44 (0) 191 211 1313 Fax
info@haskoningdhv.com E-mail
www.haskoningdhv.com Website

DRAWN	LW	CHECKED	DGB	PASSED	RWP
DATE	FEB'16	CLIENT'S REF.			
SCALE AT A1	1:1000	AUTOCAD REF.	PB1586-SK493		
DRAWING No.	PB1586-SK493	REVISION			E